


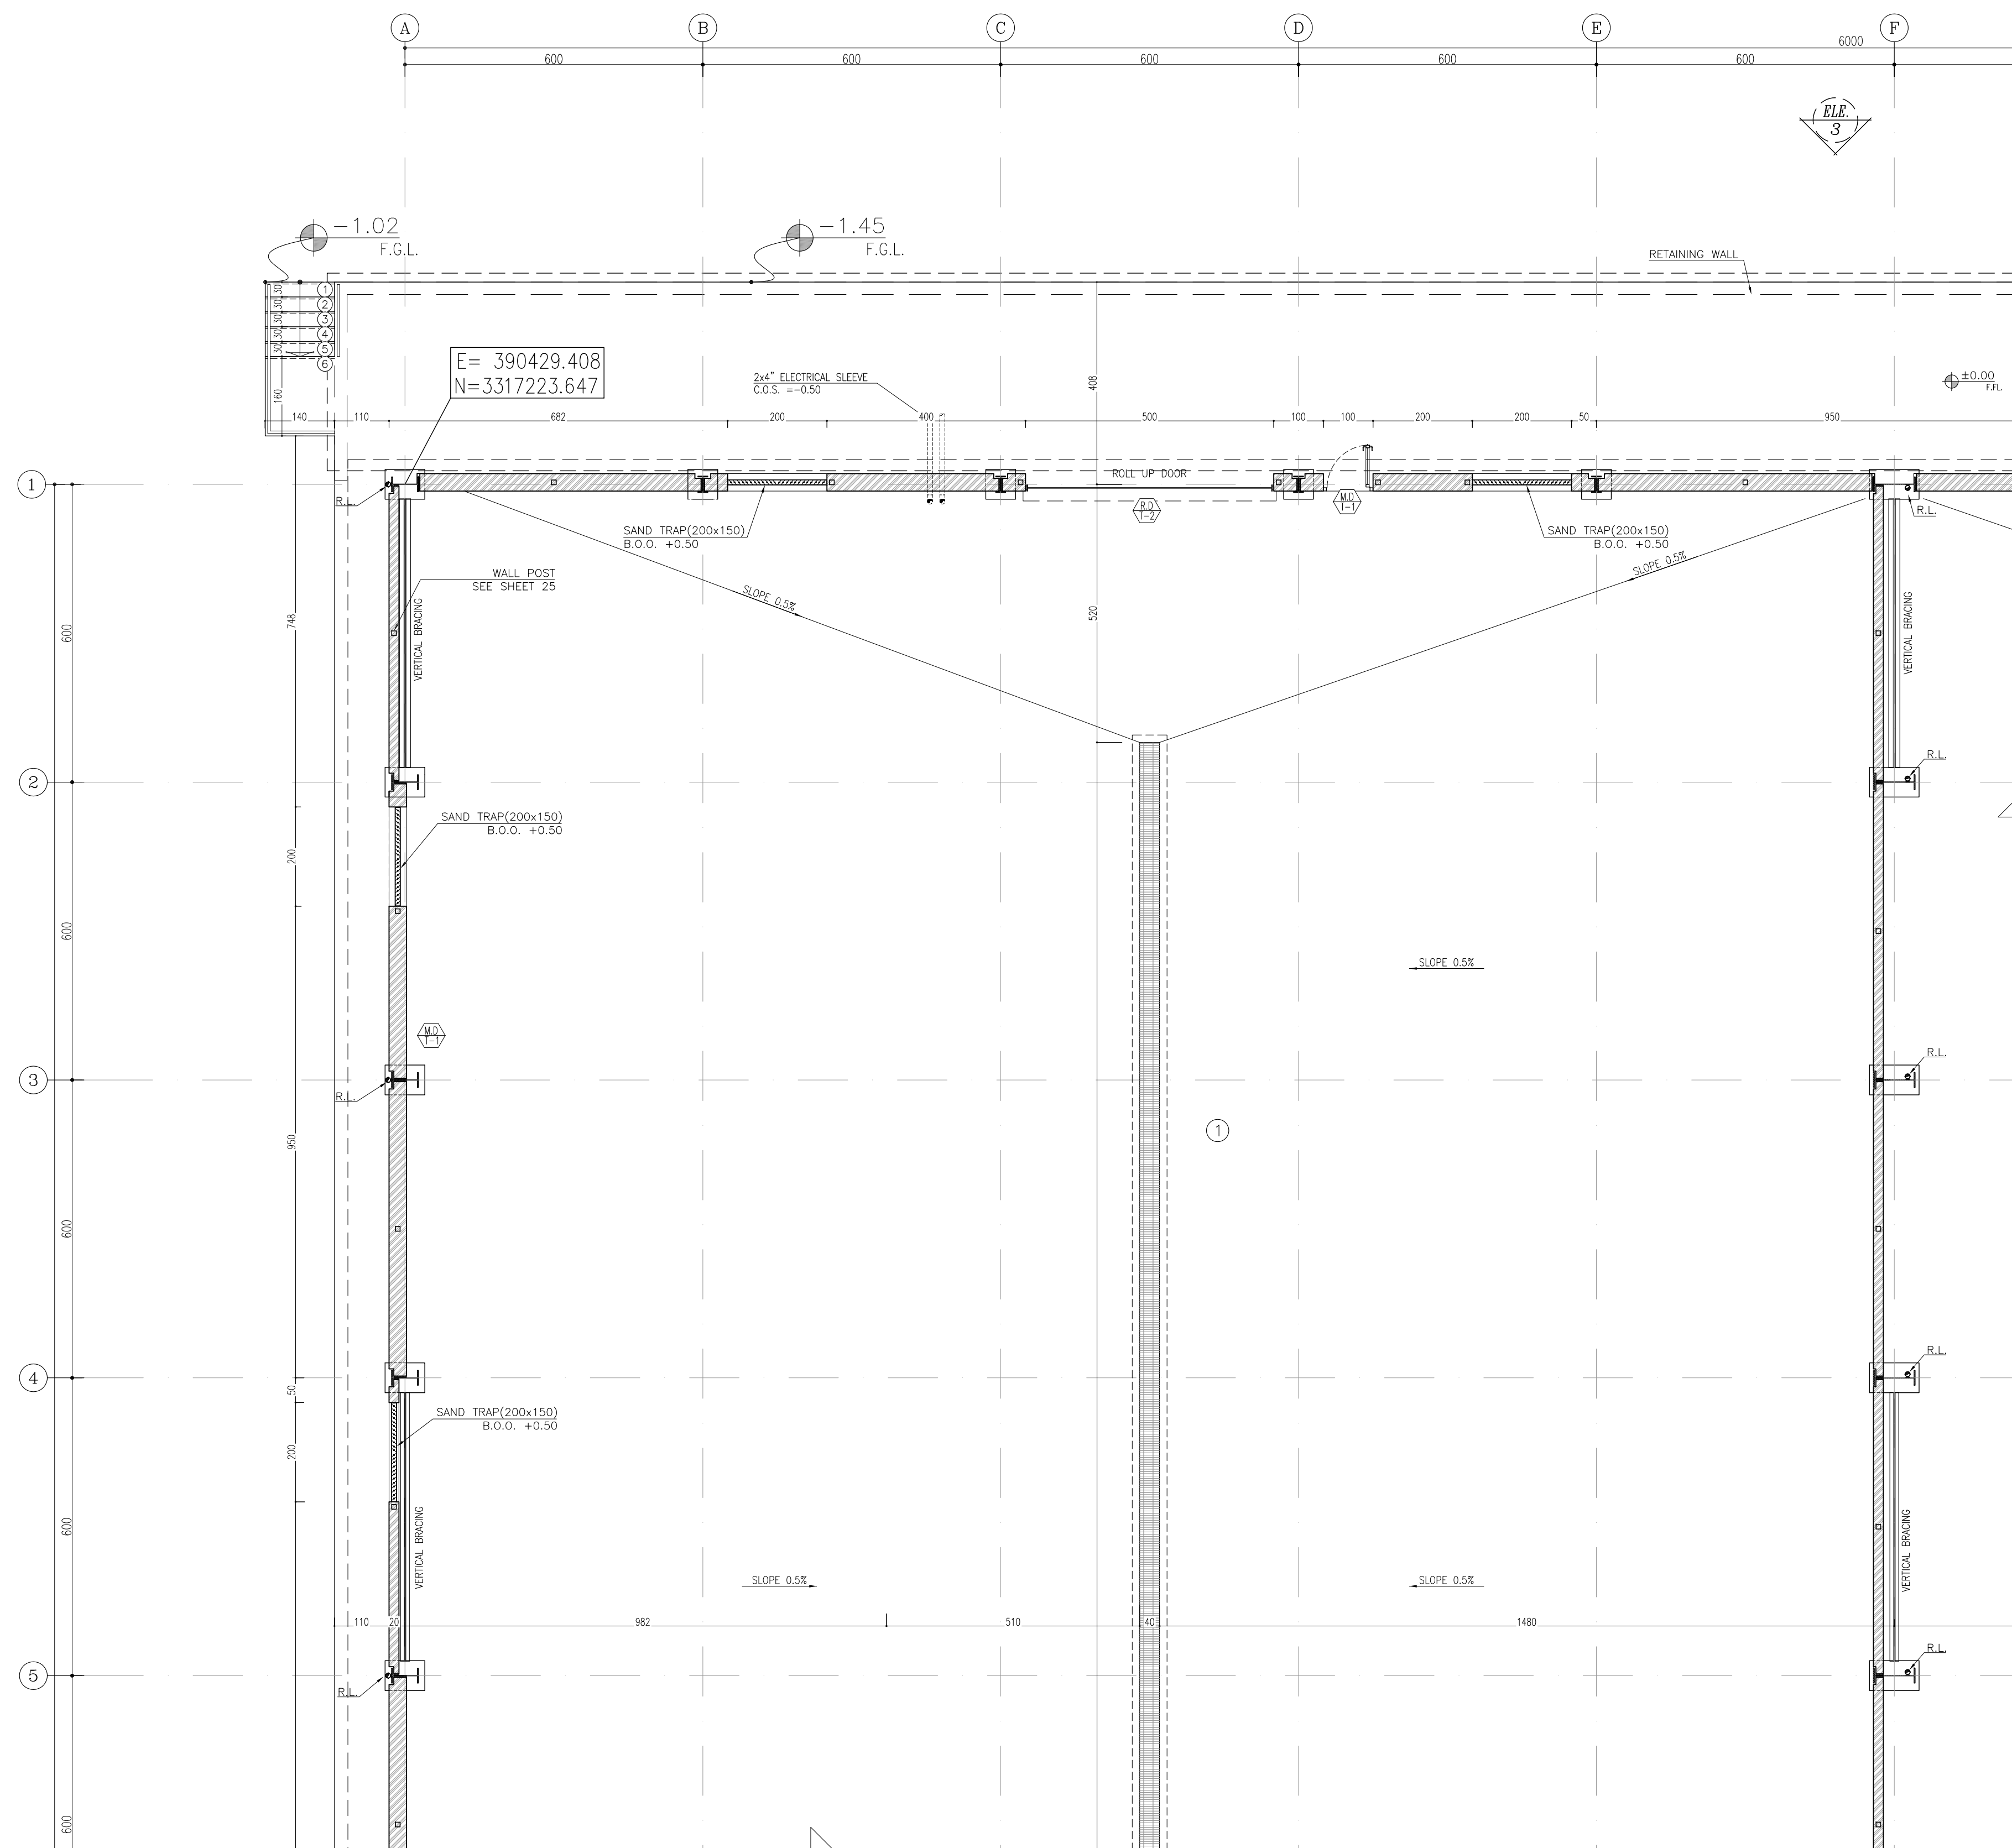


NOTES 1. ALL DIMENSIONS ARE IN CENTIMETER & ALL ELEVATIONS ARE IN METER. 2. ALL DIMENSIONS AND ELEVATIONS SHALL BE CHECKED BY THE CONTRACTOR PRIOR TO CONSTRUCTION. 3. F.F.L. IN ARCHITECTURAL DOCUMENT IS EQUALS TO 2518.50 4. CONTRACTOR SHALL COMPARE ALL ARCHITECTURAL, MECHANICAL, ELECTRICAL, PIPING AND STRUCTURAL DRAWINGS AND IN CASE OF ANY CONFLICTS OR DISCREPANCY, INFORM THE ENGINEER. 5. ALL OPENINGS FOR PIPING/CABLING SHALL BE CONSIDERED AS PER RELATED DRAWINGS BEFORE CONSTRUCTION.		B

KEY PLAN

WAREHOUSES NO. 2-3

02	30.05.2023	ISSUED FOR CONSTRUCTION	M.MA&M.KH	M.AHMADI	H.NOROUZI	-			
01	23.05.2023	ISSUED FOR APPROVAL	M.MA&M.KH	M.AHMADI	H.NOROUZI	-			
00	09.02.2023	ISSUED FOR REVIEW AND COMMENT	M.MA&M.KH	M.AHMADI	H.NOROUZI	-			
REV.	DATE	DESCRIPTION	PREPARED	CHECKED	APPROVED	AUTHORIZED			
Client:			MC:						
 NICICO NATIONAL IRANIAN COPPER INDUSTRIES Co.			 Shargan Consultant Engineers						
Consultant:			Contractor:						
 Mobina Engineering Co.			 						
Project:									
Sarcheshmeh Copper Concentrator Expansion Plant (Phase.3)									
Title:									
ARCHITECTURAL DETAIL DESIGN FOR SARCHESHMEH WAREHOUSES NO. 2-3									
Document Number:			DATE	SIZE	SCALE	SHEET NO.	REV.		
12003-D-AR-DWG-312-WHS-002			30.05.2023	A1	AS SHOWN	2 OF 25	CLIENT	VENDOR	
							02	02	

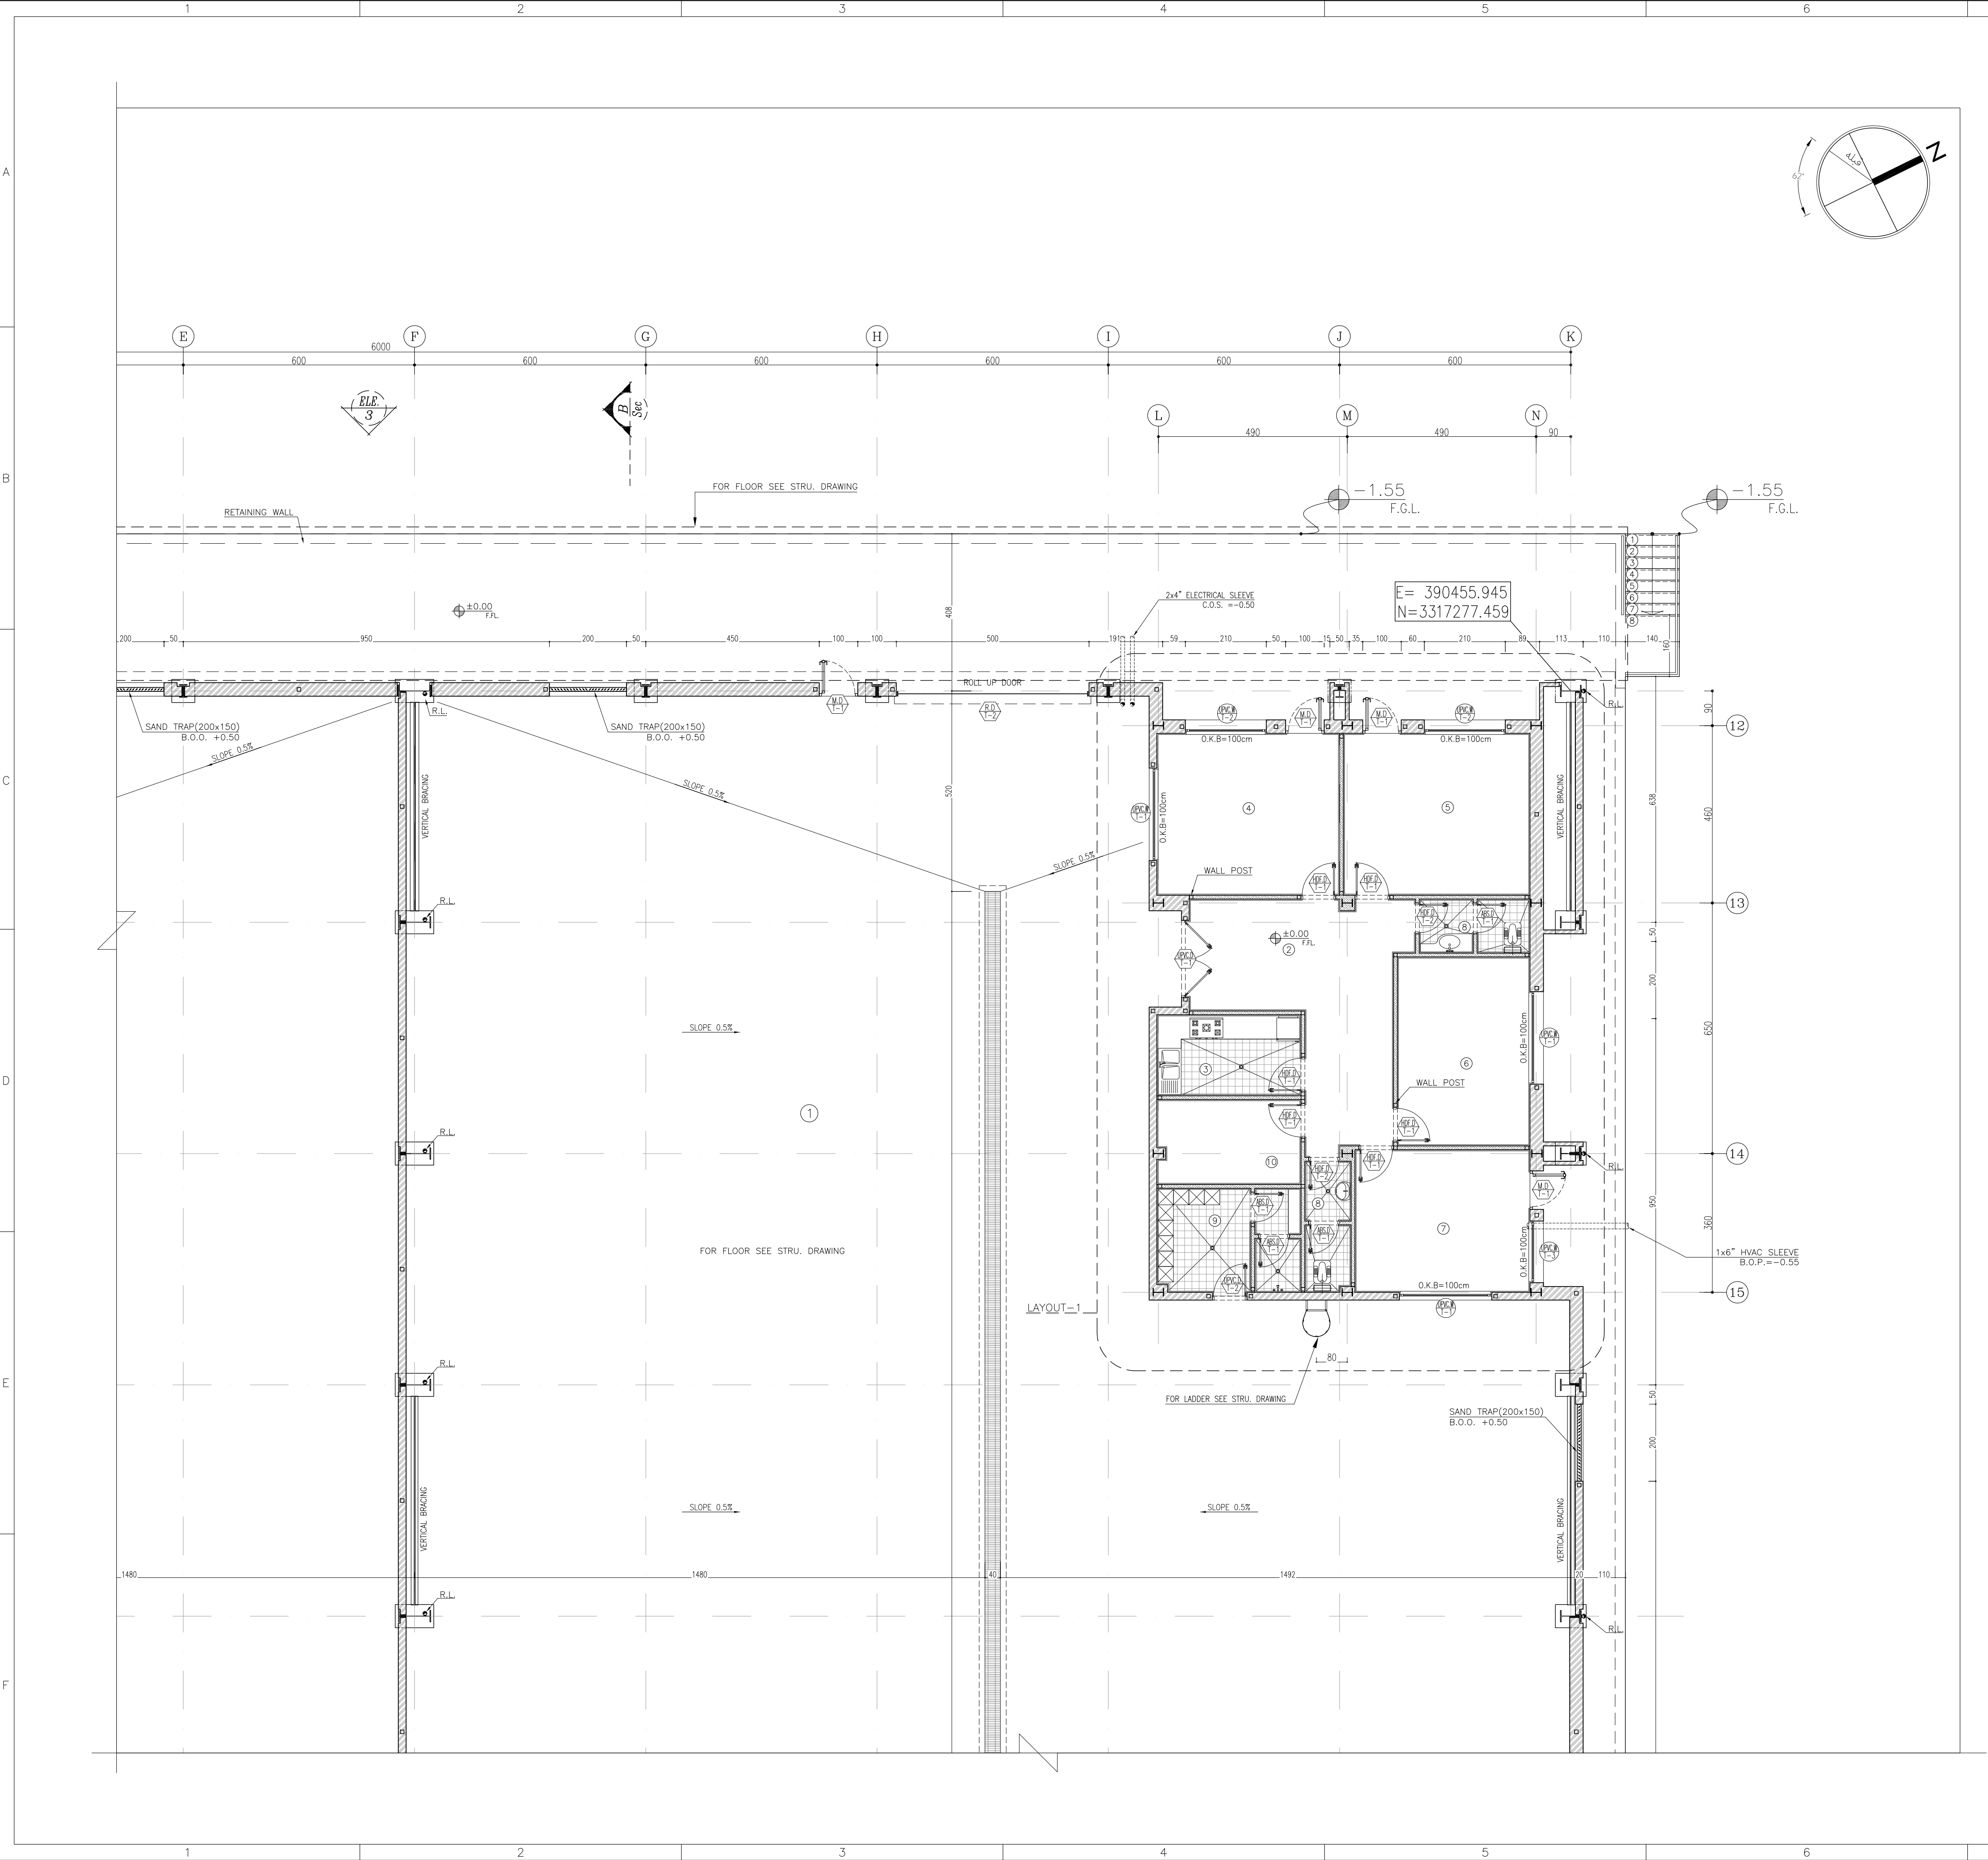

REFERENCE

REFERENCE. TITLE	REFERENCE. No.
FOUNDATION DRAWING	12003-D-ST-DWG-312-WHS-003
STRUCTURE DRAWING	12003-D-ST-DWG-312-WHS-004

NOTES

1. ALL DIMENSIONS ARE IN CENTIMETER & ALL ELEVATIONS ARE IN METER.
2. ALL DIMENSIONS AND ELEVATIONS SHALL BE CHECKED BY THE CONTRACTOR PRIOR TO CONSTRUCTION.
3. F.F.L. IN ARCHITECTURAL DOCUMENT IS EQUALS TO 2518.50
4. CONTRACTOR SHALL COMPARE ALL ARCHITECTURAL, MECHANICAL, ELECTRICAL, PIPING AND STRUCTURAL DRAWINGS AND IN CASE OF ANY CONFLICTS OR DISCREPANCY, INFORM THE ENGINEER.
5. ALL OPENINGS FOR PIPING/CABLING SHALL BE CONSIDERED AS PER RELATED DRAWINGS BEFORE CONSTRUCTION.

LEGEND

AREA NAME :

① WAREHOUSE	⑥ LOUNGE ROOM
② ENTRANCE	⑦ SUPERVISOR ROOM
③ PANTRY	⑧ W.C
④ MANAGER ROOM	⑨ LOCKER & SHOWER
⑤ PAYMENT ORDER ROOM	⑩ PRAYER ROOM

KEY PLAN

02	30.05.2023	ISSUED FOR CONSTRUCTION	M.MA&M.KH	M.AHMADI	H.NOROUZI	-
01	23.05.2023	ISSUED FOR APPROVAL	M.MA&M.KH	M.AHMADI	H.NOROUZI	-
00	09.02.2023	ISSUED FOR REVIEW AND COMMENT	M.MA&M.KH	M.AHMADI	H.NOROUZI	-
REV.	DATE	DESCRIPTION	PREPARED	CHECKED	APPROVED	AUTHORIZED

Client: NICICO NATIONAL IRANIAN COPPER INDUSTRIES Co.

MC: Shargan Consultant Engineers

Consultant: mobina Mobina Engineering Co.

Contractor: NIPEC

Project: **Sarcheshmeh Copper Concentrator Expansion Plant (Phase.3)**

Title: **ARCHITECTURAL DETAIL DESIGN FOR SARCHESHMEH WAREHOUSES NO. 2-3**


Document Number:	DATE	SIZE	SCALE	SHEET NO.	REV.
12003-D-AR-DWG-312-WHS-002	30.05.2023	A1	AS SHOWN	3 OF 25	02



1. ALL DIMENSIONS ARE IN CENTIMETER & ALL ELEVATIONS ARE IN METER.	
2. ALL DIMENSIONS AND ELEVATIONS SHALL BE CHECKED BY THE CONTRACTOR PRIOR TO CONSTRUCTION.	
3. F.F.L. IN ARCHITECTURAL DOCUMENT IS EQUALS TO 2518.50	
4. CONTRACTOR SHALL COMPARE ALL ARCHITECTURAL, MECHANICAL, ELECTRICAL, PIPING AND STRUCTURAL DRAWINGS AND IN CASE OF ANY CONFLICTS OR DISCREPANCY, INFORM THE ENGINEER.	
5. ALL OPENINGS FOR PIPING/CABLING SHALL BE CONSIDERED AS PER RELATED DRAWINGS BEFORE CONSTRUCTION.	B

AREA NAME	
① WAREHOUSE	⑥ LOUNGE ROOM
② ENTRANCE	⑦ SUPERVISOR ROOM
③ PANTRY	⑧ W.C
④ MANAGER ROOM	⑨ LOCKER & SHOWER
⑤ PAYMENT ORDER ROOM	⑩ PRAYER ROOM

Document Number: 12003-D-AR-DWG-312-WHS-002	DATE	SIZE	SCALE	SHEET NO.	REV.	
	30.05.2023	A1	AS SHOWN	5 OF 25	CLIENT	VENDOR
7			8			

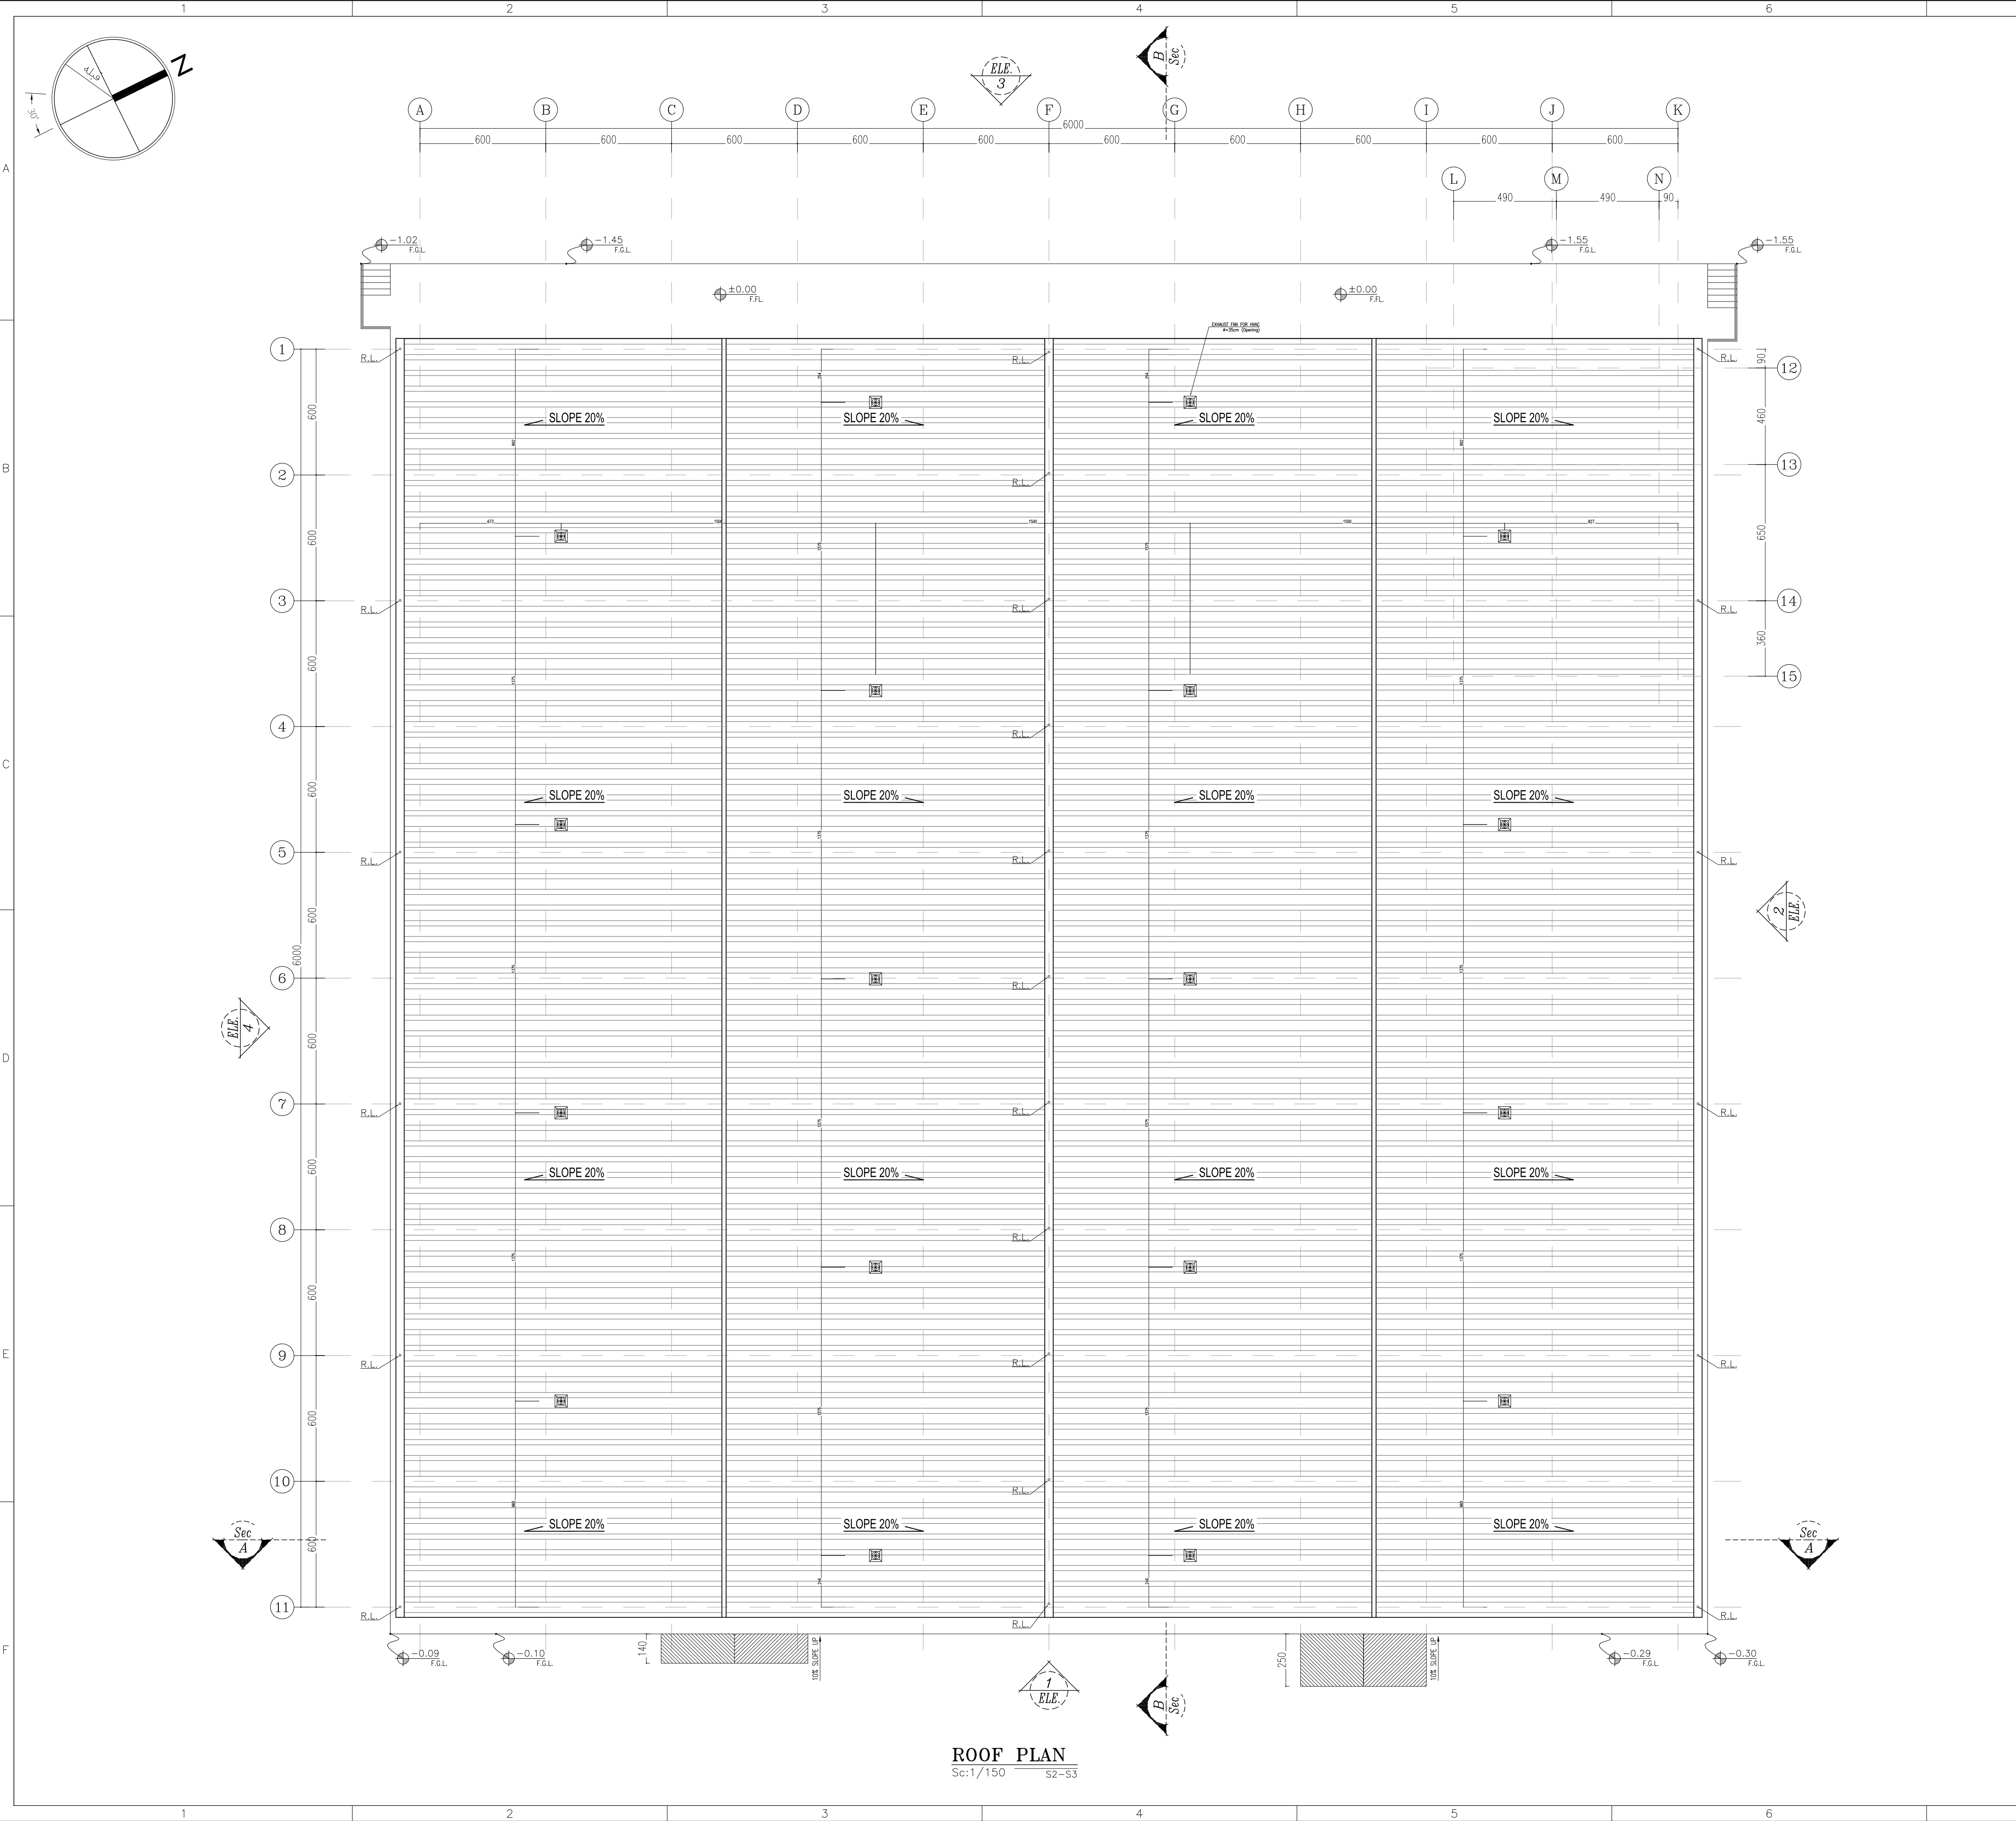

ROOF PLAN
Sc:1/150 S2-S3

REFERENCE

REFERENCE. TITLE	REFERENCE. No.
FOUNDATION DRAWING	12003-D-ST-DWG-312-WHS-003
STRUCTURE DRAWING	12003-D-ST-DWG-312-WHS-004

NOTES

1. ALL DIMENSIONS ARE IN CENTIMETER & ALL ELEVATIONS ARE IN METER.
2. ALL DIMENSIONS AND ELEVATIONS SHALL BE CHECKED BY THE CONTRACTOR PRIOR TO CONSTRUCTION.
3. F.F.L. IN ARCHITECTURAL DOCUMENT IS EQUALS TO 2518.50
4. CONTRACTOR SHALL COMPARE ALL ARCHITECTURAL, MECHANICAL, ELECTRICAL, PIPING AND STRUCTURAL DRAWINGS AND IN CASE OF ANY CONFLICTS OR DISCREPANCY, INFORM THE ENGINEER.
5. ALL OPENINGS FOR PIPING/CABLING SHALL BE CONSIDERED AS PER RELATED DRAWINGS BEFORE CONSTRUCTION.

LEGEND

AREA NAME :

① WAREHOUSE	⑥ LOUNGE ROOM
② ENTRANCE	⑦ SUPERVISOR ROOM
③ PANTRY	⑧ W.C
④ MANAGER ROOM	⑨ LOCKER & SHOWER
⑤ PAYMENT ORDER ROOM	⑩ PRAYER ROOM

KEY PLAN

02	30.05.2023	ISSUED FOR CONSTRUCTION	M.MA&M.KH	M.AHMADI	H.NOROUZI	-
01	23.05.2023	ISSUED FOR APPROVAL	M.MA&M.KH	M.AHMADI	H.NOROUZI	-
00	09.02.2023	ISSUED FOR REVIEW AND COMMENT	M.MA&M.KH	M.AHMADI	H.NOROUZI	-
REV.	DATE	DESCRIPTION	PREPARED	CHECKED	APPROVED	AUTHORIZED

Client: NICICO NATIONAL IRANIAN COPPER INDUSTRIES Co.

MC: Shargan Consultant Engineers


Consultant: Mobina Engineering Co.

Contractor: NIPEC


Project: **Sarcheshmeh Copper Concentrator Expansion Plant (Phase.3)**

Title: **ARCHITECTURAL DETAIL DESIGN FOR SARCHESHMEH WAREHOUSES NO. 2-3**

Document Number:	DATE	SIZE	SCALE	SHEET NO.	REV.
12003-D-AR-DWG-312-WHS-002	30.05.2023	A1	AS SHOWN	6 OF 25	CLIENT VENDOR
					02 02

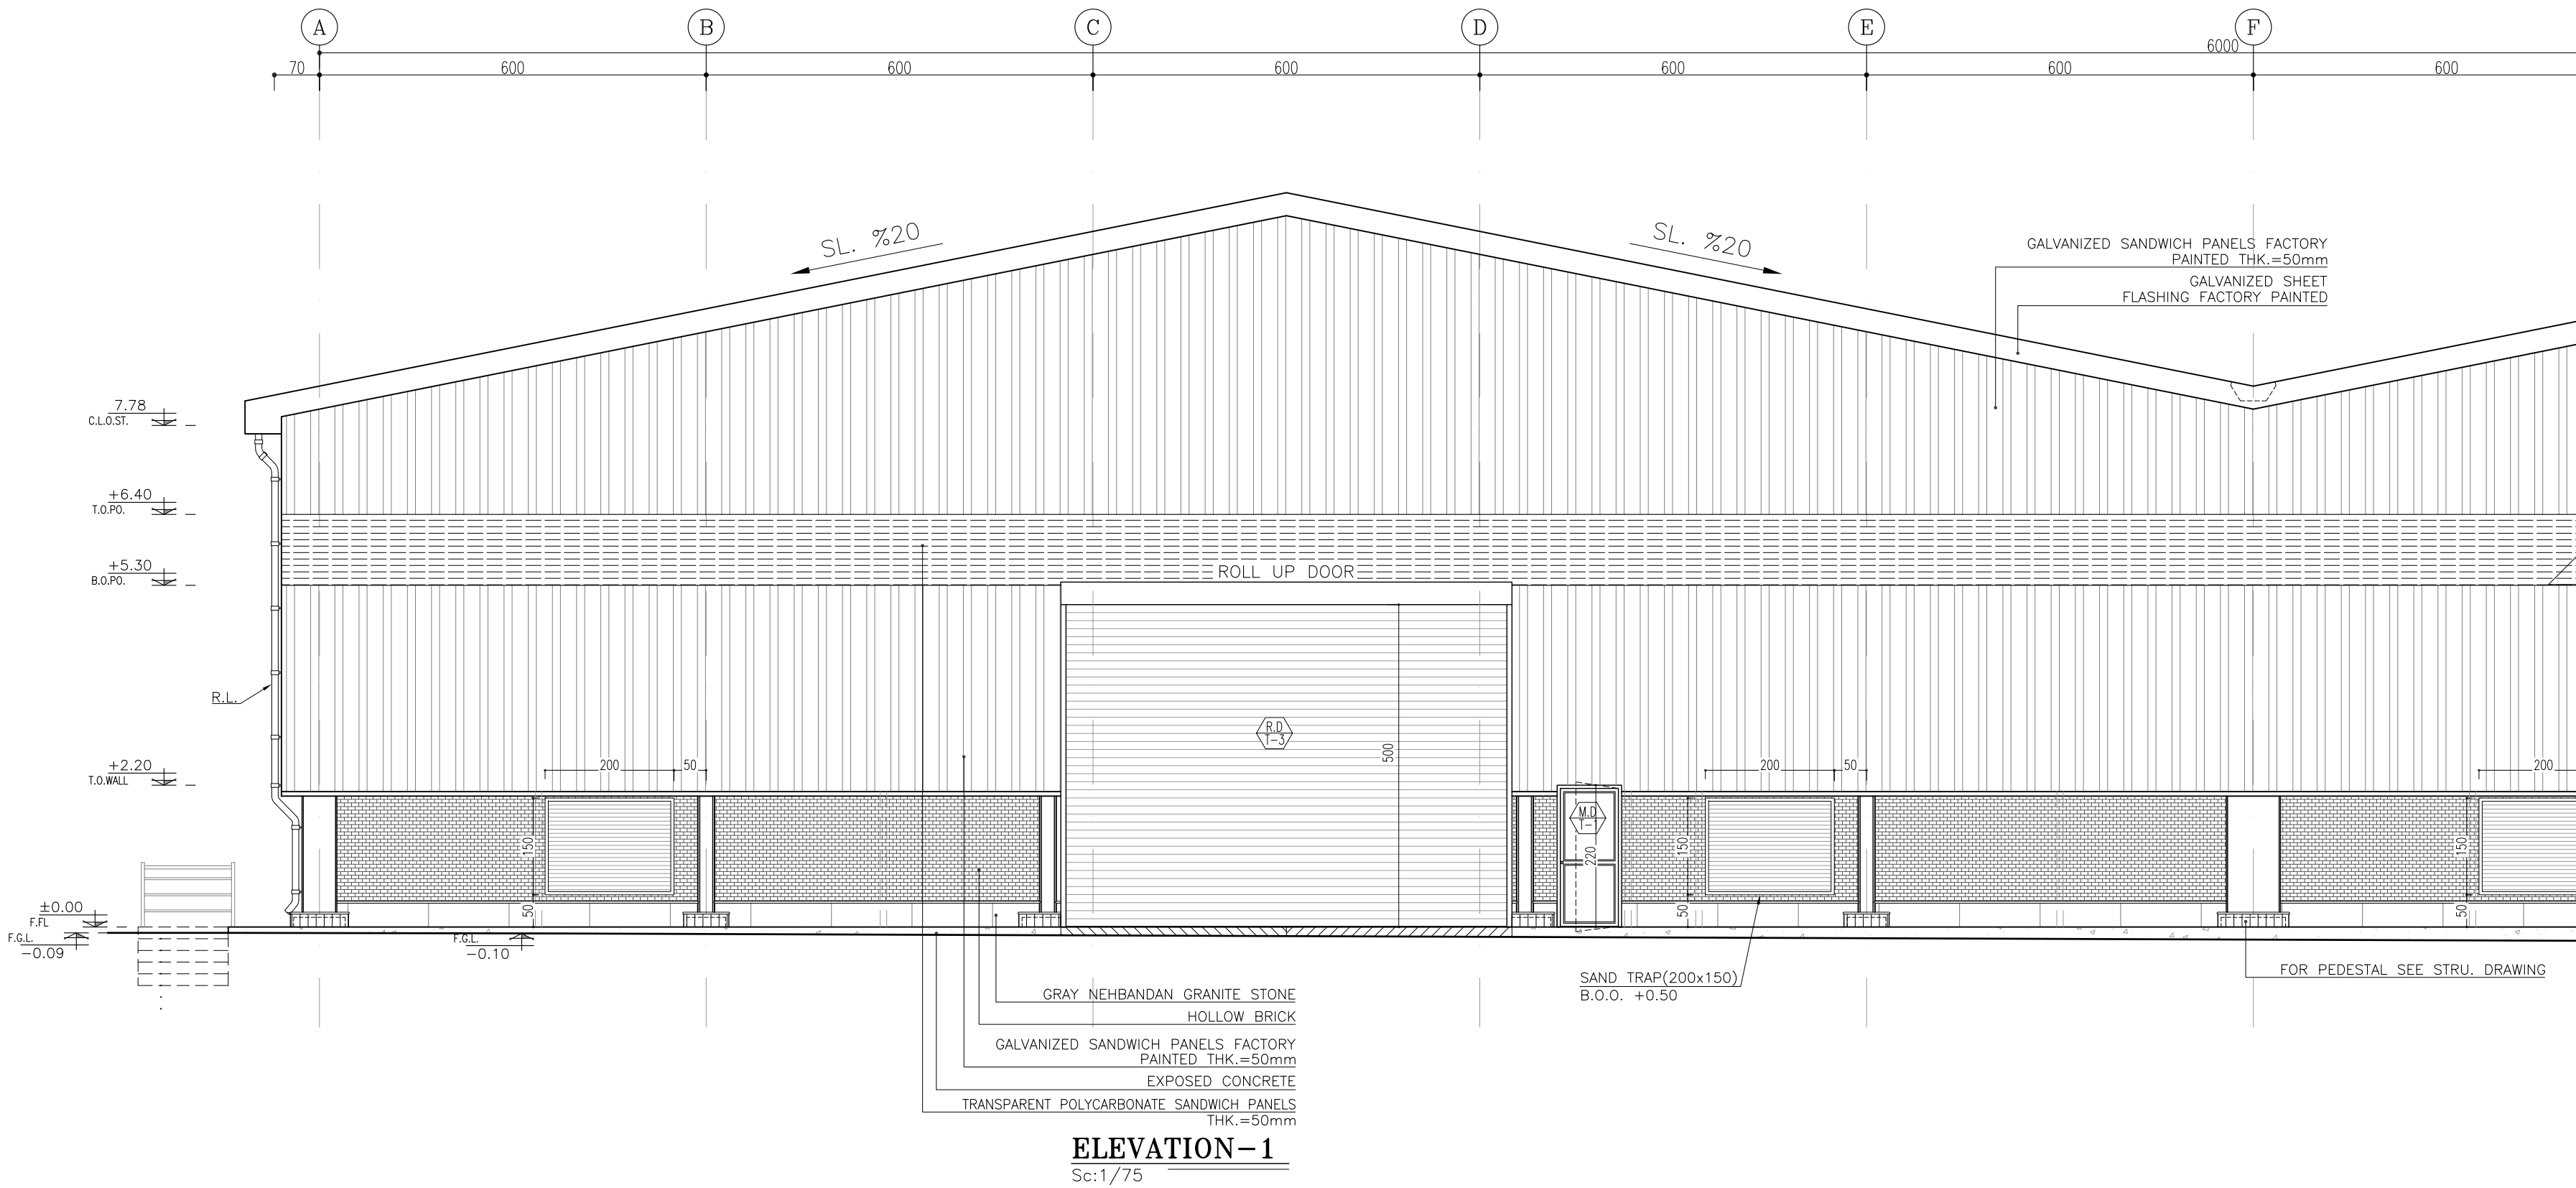

ELEVATION-1
Sc:1/75

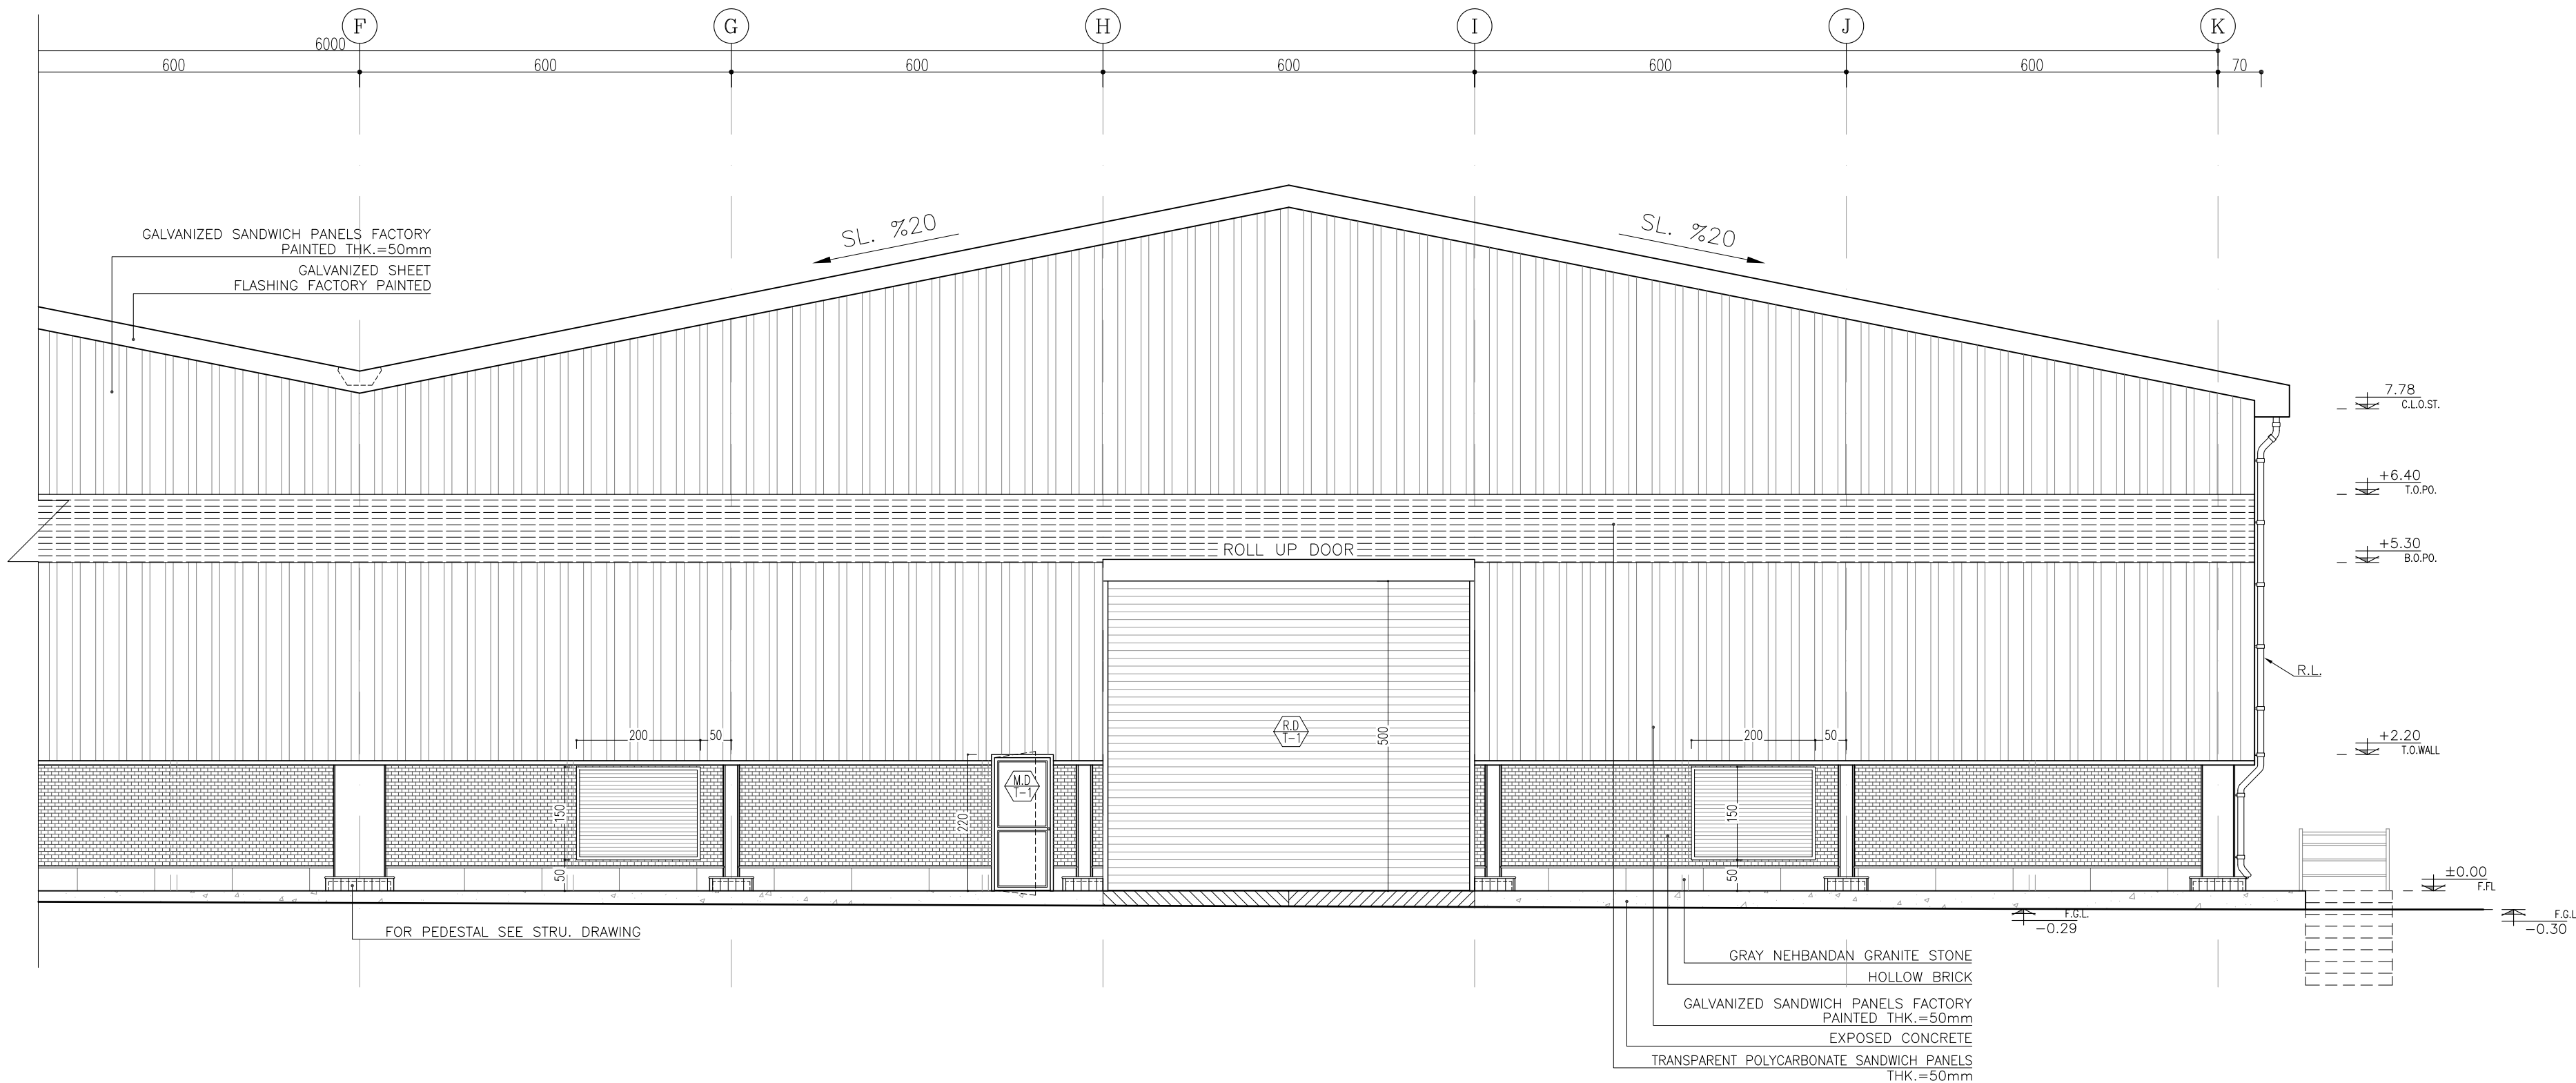

ELEVATION-1
Sc:1/75

REFERENCE

REFERENCE. TITLE	REFERENCE. No.
FOUNDATION DRAWING	12003-D-ST-DWG-312-WHS-003
STRUCTURE DRAWING	12003-D-ST-DWG-312-WHS-004

NOTES


1. ALL DIMENSIONS ARE IN CENTIMETER & ALL ELEVATIONS ARE IN METER.
2. ALL DIMENSIONS AND ELEVATIONS SHALL BE CHECKED BY THE CONTRACTOR PRIOR TO CONSTRUCTION.
3. F.F.L. IN ARCHITECTURAL DOCUMENT IS EQUALS TO 2518.50
4. CONTRACTOR SHALL COMPARE ALL ARCHITECTURAL, MECHANICAL, ELECTRICAL, PIPING AND STRUCTURAL DRAWINGS AND IN CASE OF ANY CONFLICTS OR DISCREPANCY, INFORM THE ENGINEER.
5. ALL OPENINGS FOR PIPING/CABLING SHALL BE CONSIDERED AS PER RELATED DRAWINGS BEFORE CONSTRUCTION.

LEGEND

AREA NAME :

- | | |
|----------------------|-------------------|
| ① WAREHOUSE | ⑥ LOUNGE ROOM |
| ② ENTRANCE | ⑦ SUPERVISOR ROOM |
| ③ PANTRY | ⑧ W.C |
| ④ MANAGER ROOM | ⑨ LOCKER & SHOWER |
| ⑤ PAYMENT ORDER ROOM | ⑩ PRAYER ROOM |

KEY PLAN

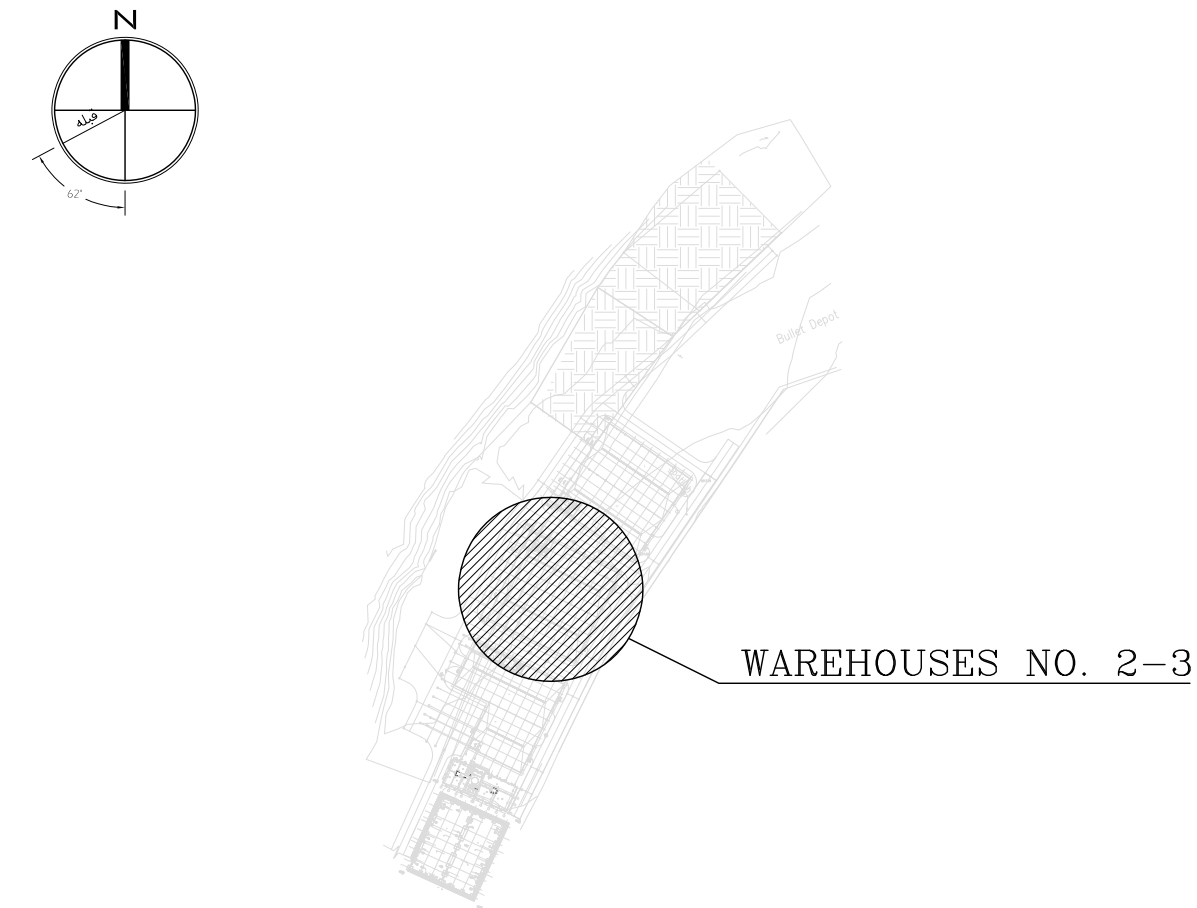

REV.	DATE	DESCRIPTION	PREPARED	CHECKED	APPROVED	AUTHORIZED
02	30.05.2023	ISSUED FOR CONSTRUCTION	M.MA&M.KH	M.AHMADI	H.NOROUZI	-
01	23.05.2023	ISSUED FOR APPROVAL	M.MA&M.KH	M.AHMADI	H.NOROUZI	-
00	09.02.2023	ISSUED FOR REVIEW AND COMMENT	M.MA&M.KH	M.AHMADI	H.NOROUZI	-

Client:



NICICO
NATIONAL IRANIAN
COPPER INDUSTRIES Co.

MC:



Shargan
Consultant Engineers

Consultant:



mobina
Mobina Engineering Co.

Contractor:




NIPEC


Project: **Sarcheshmeh Copper Concentrator Expansion Plant (Phase.3)**

Title: **ARCHITECTURAL DETAIL DESIGN FOR SARCHESHMEH WAREHOUSES NO. 2-3**

Document Number:	DATE	SIZE	SCALE	SHEET NO.	REV.
12003-D-AR-DWG-312-WHS-002	30.05.2023	A1	AS SHOWN	7 OF 25	02

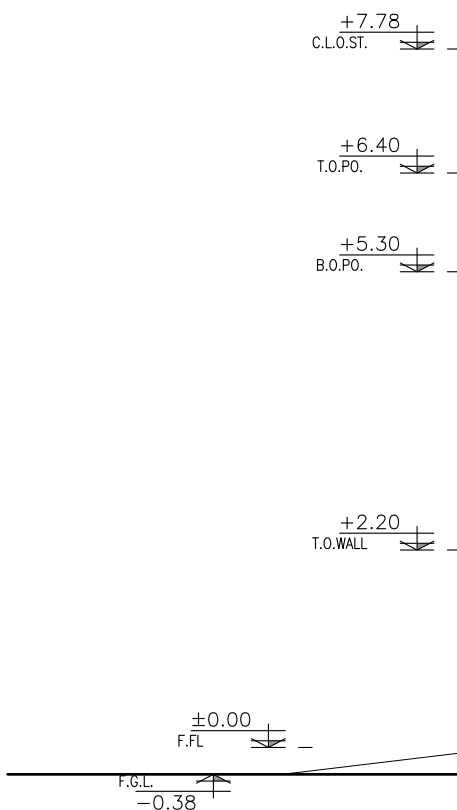

Sc:1/75

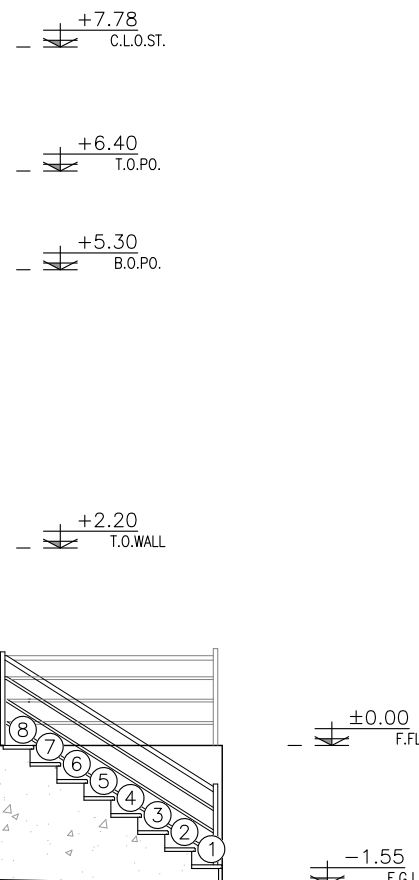


Sc:1/75

1. ALL DIMENSIONS ARE IN CENTIMETER & ALL ELEVATIONS ARE IN METER.
2. ALL DIMENSIONS AND ELEVATIONS SHALL BE CHECKED BY THE CONTRACTOR PRIOR TO CONSTRUCTION.
3. F.F.L. IN ARCHITECTURAL DOCUMENT IS EQUALS TO 2518.50
4. CONTRACTOR SHALL COMPARE ALL ARCHITECTURAL, MECHANICAL, ELECTRICAL, PIPING AND STRUCTURAL DRAWINGS AND IN CASE OF ANY CONFLICTS OR DISCREPANCY, INFORM THE ENGINEER.
5. ALL OPENINGS FOR PIPING/CABLING SHALL BE CONSIDERED AS PER RELATED DRAWINGS BEFORE CONSTRUCTION.

① WAREHOUSE	⑥ LOUNGE ROOM
② ENTRANCE	⑦ SUPERVISOR ROOM
③ PANTRY	⑧ W.C
④ MANAGER ROOM	⑨ LOCKER & SHOWER
⑤ PAYMENT ORDER ROOM	⑩ PRAYER ROOM


Document Number: 12003-D-AR-DWG-312-WHS-002	DATE	SIZE	SCALE	SHEET NO.	REV.	
	30.05.2023	A1	AS SHOWN	8 OF 25	CLIENT	VENDOR
					02	02

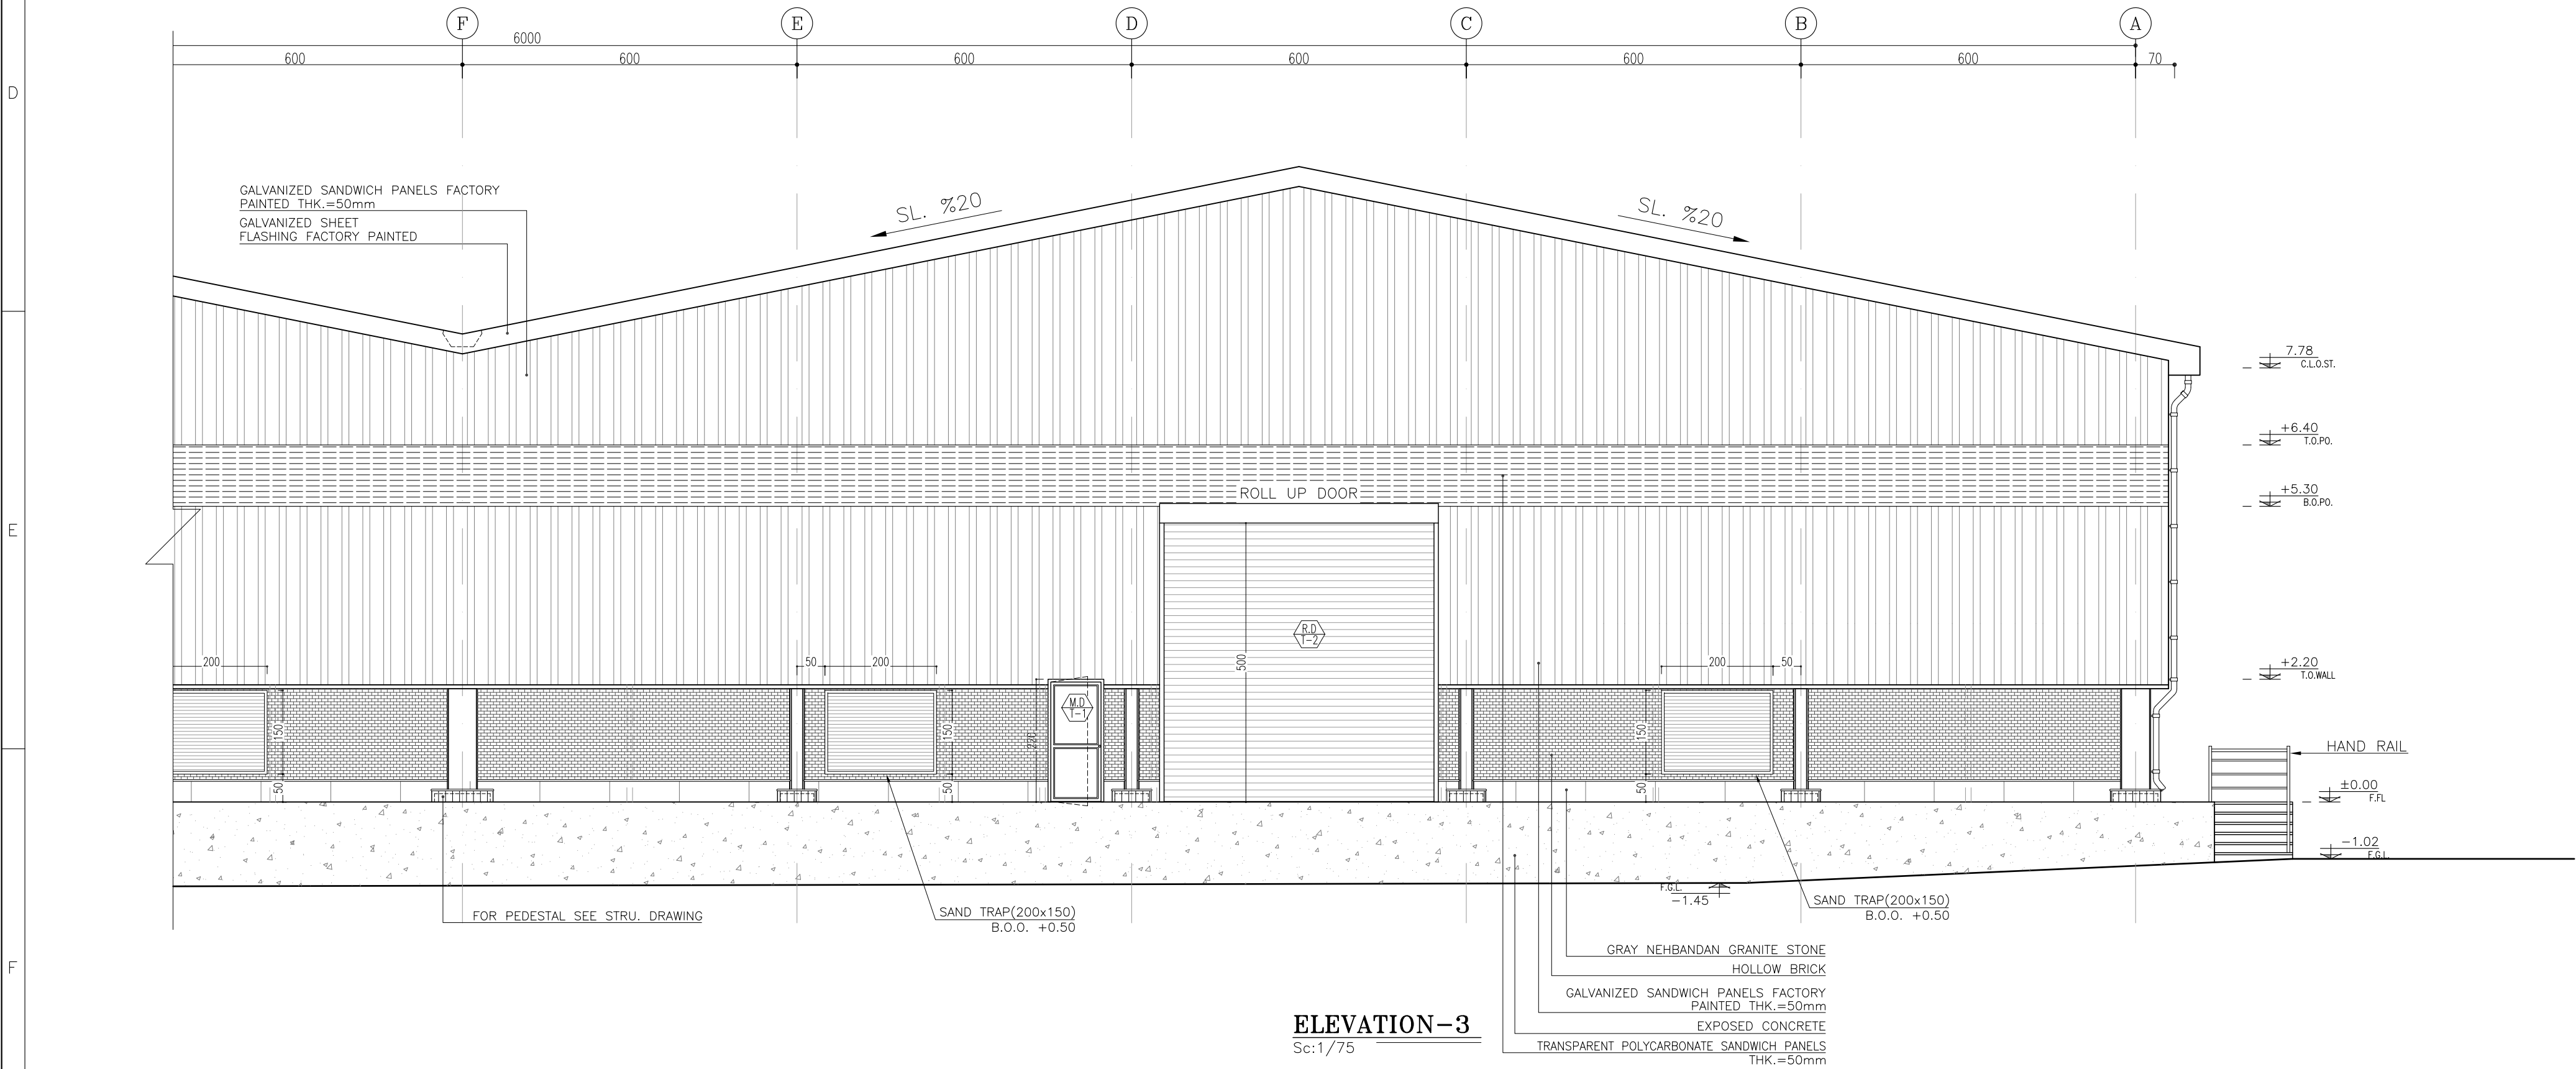



REFERENCE	
REFERENCE. TITLE	REFERENCE. No.
FOUNDATION DRAWING	12003-D-ST-DWG-312-WHS-003
STRUCTURE DRAWING	12003-D-ST-DWG-312-WHS-004

NOTES	
1. ALL DIMENSIONS ARE IN CENTIMETER & ALL ELEVATIONS ARE IN METER.	
2. ALL DIMENSIONS AND ELEVATIONS SHALL BE CHECKED BY THE CONTRACTOR PRIOR TO CONSTRUCTION.	
3. F.F.L. IN ARCHITECTURAL DOCUMENT IS EQUALS TO 2518.50	
4. CONTRACTOR SHALL COMPARE ALL ARCHITECTURAL, MECHANICAL, ELECTRICAL, PIPING AND STRUCTURAL DRAWINGS AND IN CASE OF ANY CONFLICTS OR DISCREPANCY, INFORM THE ENGINEER.	
5. ALL OPENINGS FOR PIPING/CABLING SHALL BE CONSIDERED AS PER RELATED DRAWINGS BEFORE CONSTRUCTION.	

LEGEND	
AREA NAME :	
① WAREHOUSE	⑥ LOUNGE ROOM
② ENTRANCE	⑦ SUPERVISOR ROOM
③ PANTRY	⑧ W.C
④ MANAGER ROOM	⑨ LOCKER & SHOWER
⑤ PAYMENT ORDER ROOM	⑩ PRAYER ROOM

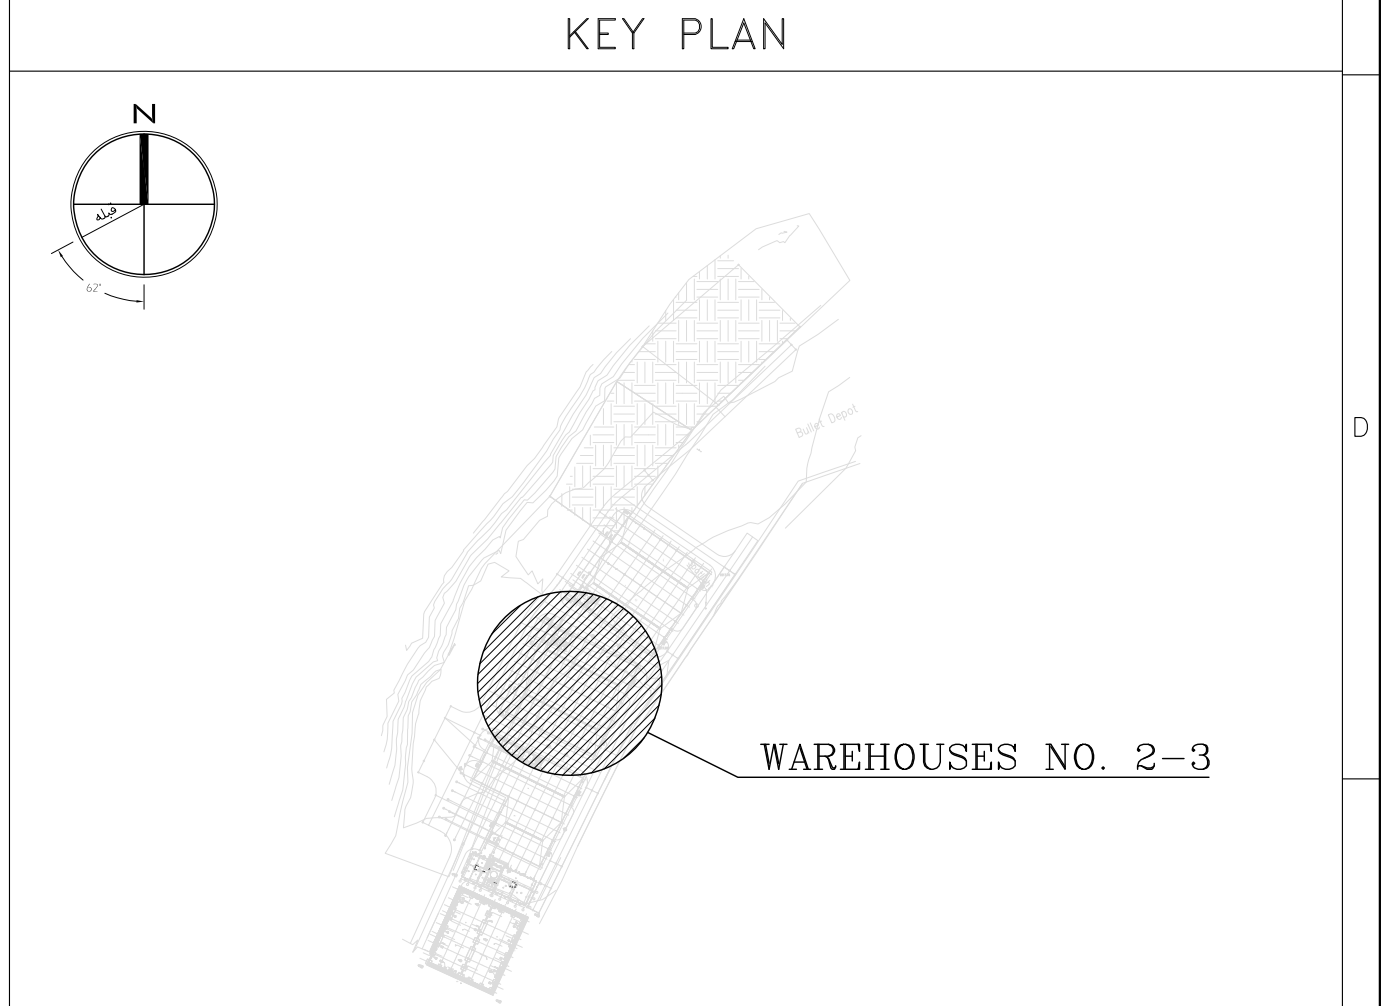

02	30.05.2023	ISSUED FOR CONSTRUCTION	M.MA&M.KH	M.AHMADI	H.NOROUZI	-	
01	23.05.2023	ISSUED FOR APPROVAL	M.MA&M.KH	M.AHMADI	H.NOROUZI	-	
00	09.02.2023	ISSUED FOR REVIEW AND COMMENT	M.MA&M.KH	M.AHMADI	H.NOROUZI	-	
REV.	DATE	DESCRIPTION	PREPARED	CHECKED	APPROVED	AUTHORIZED	
Client:  NICICO NATIONAL IRANIAN COPPER INDUSTRIES Co.			MC:  Shargan Consultant Engineers				
Consultant:  mobina Mobina Engineering Co.			Contractor:  NIPEC				
Project: Sarcheshmeh Copper Concentrator Expansion Plant (Phase.3)							
Title: ARCHITECTURAL DETAIL DESIGN FOR SARCHESHMEH WAREHOUSES NO. 2-3							
Document Number: 12003-D-AR-DWG-312-WHS-002			DATE 30.05.2023	SIZE A1	SCALE AS SHOWN	SHEET NO. 9 OF 25	REV. CLIENT VENDOR 02 02
7			8				

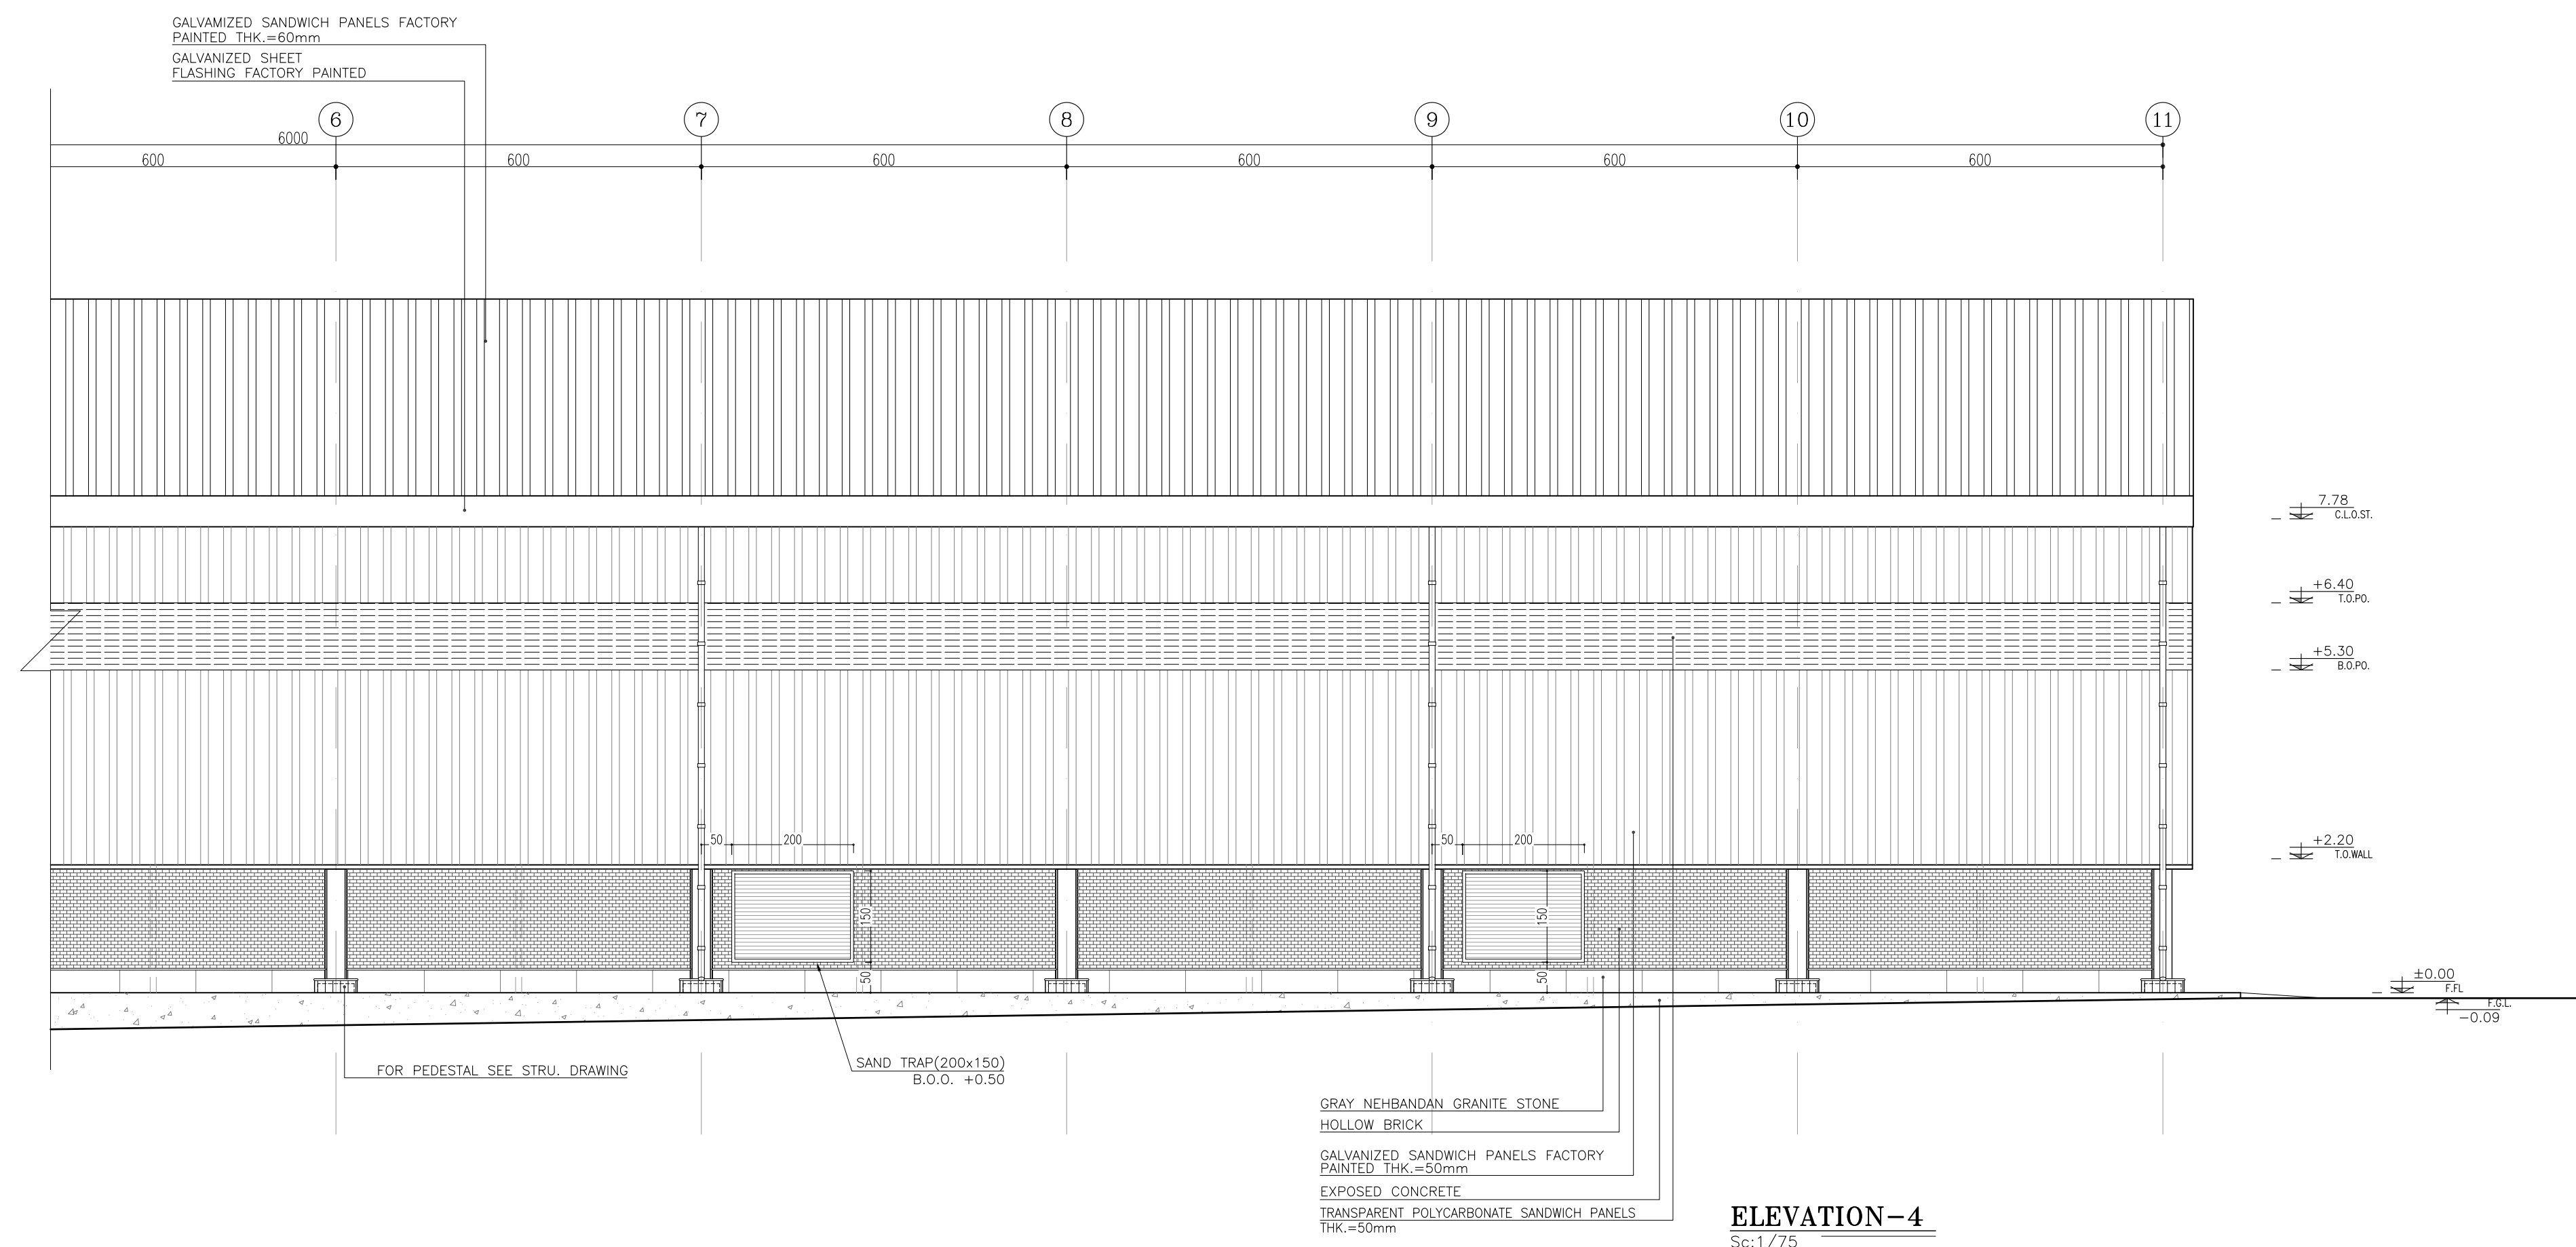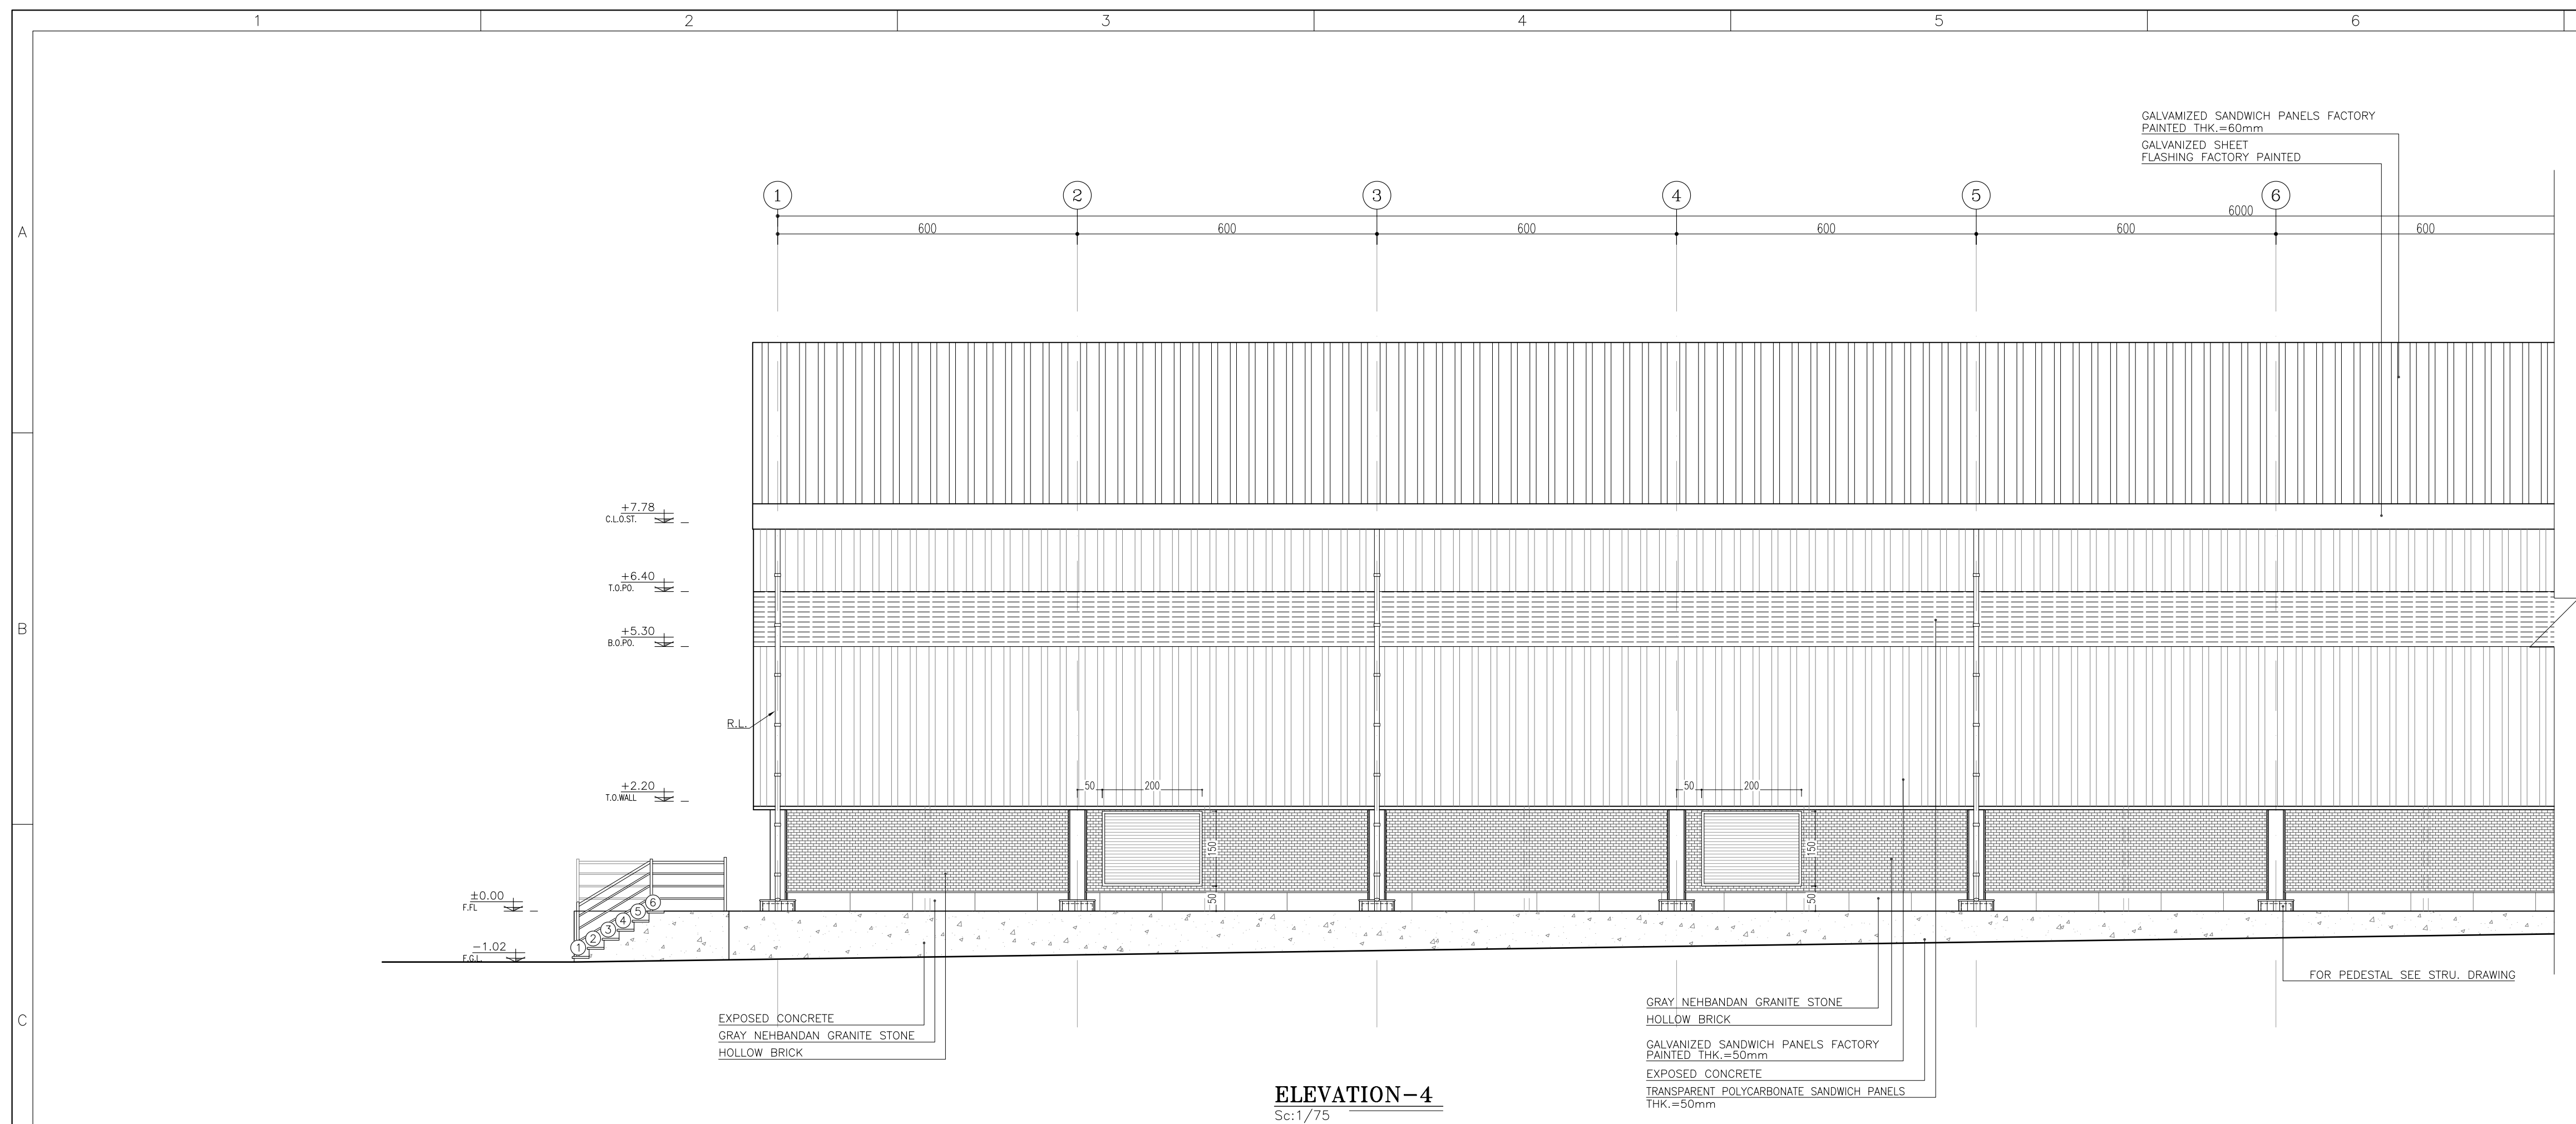


ELEVATION-4
Sc:1/75


REFERENCE	
REFERENCE. TITLE	REFERENCE. No.
FOUNDATION DRAWING	12003-D-ST-DWG-312-WHS-003
STRUCTURE DRAWING	12003-D-ST-DWG-312-WHS-004

NOTES 1. ALL DIMENSIONS ARE IN CENTIMETER & ALL ELEVATIONS ARE IN METER. 2. ALL DIMENSIONS AND ELEVATIONS SHALL BE CHECKED BY THE CONTRACTOR PRIOR TO CONSTRUCTION. 3. F.F.L. IN ARCHITECTURAL DOCUMENT IS EQUALS TO 2518.50 4. CONTRACTOR SHALL COMPARE ALL ARCHITECTURAL, MECHANICAL, ELECTRICAL, PIPING AND STRUCTURAL DRAWINGS AND IN CASE OF ANY CONFLICTS OR DISCREPANCY, INFORM THE ENGINEER. 5. ALL OPENINGS FOR PIPING/CABLING SHALL BE CONSIDERED AS PER RELATED DRAWINGS BEFORE CONSTRUCTION.		B


LEGEND	
AREA NAME :	
① WAREHOUSE	⑥ LOUNGE ROOM
② ENTRANCE	⑦ SUPERVISOR ROOM
③ PANTRY	⑧ W.C
④ MANAGER ROOM	⑨ LOCKER & SHOWER
⑤ PAYMENT ORDER ROOM	⑩ PRAYER ROOM

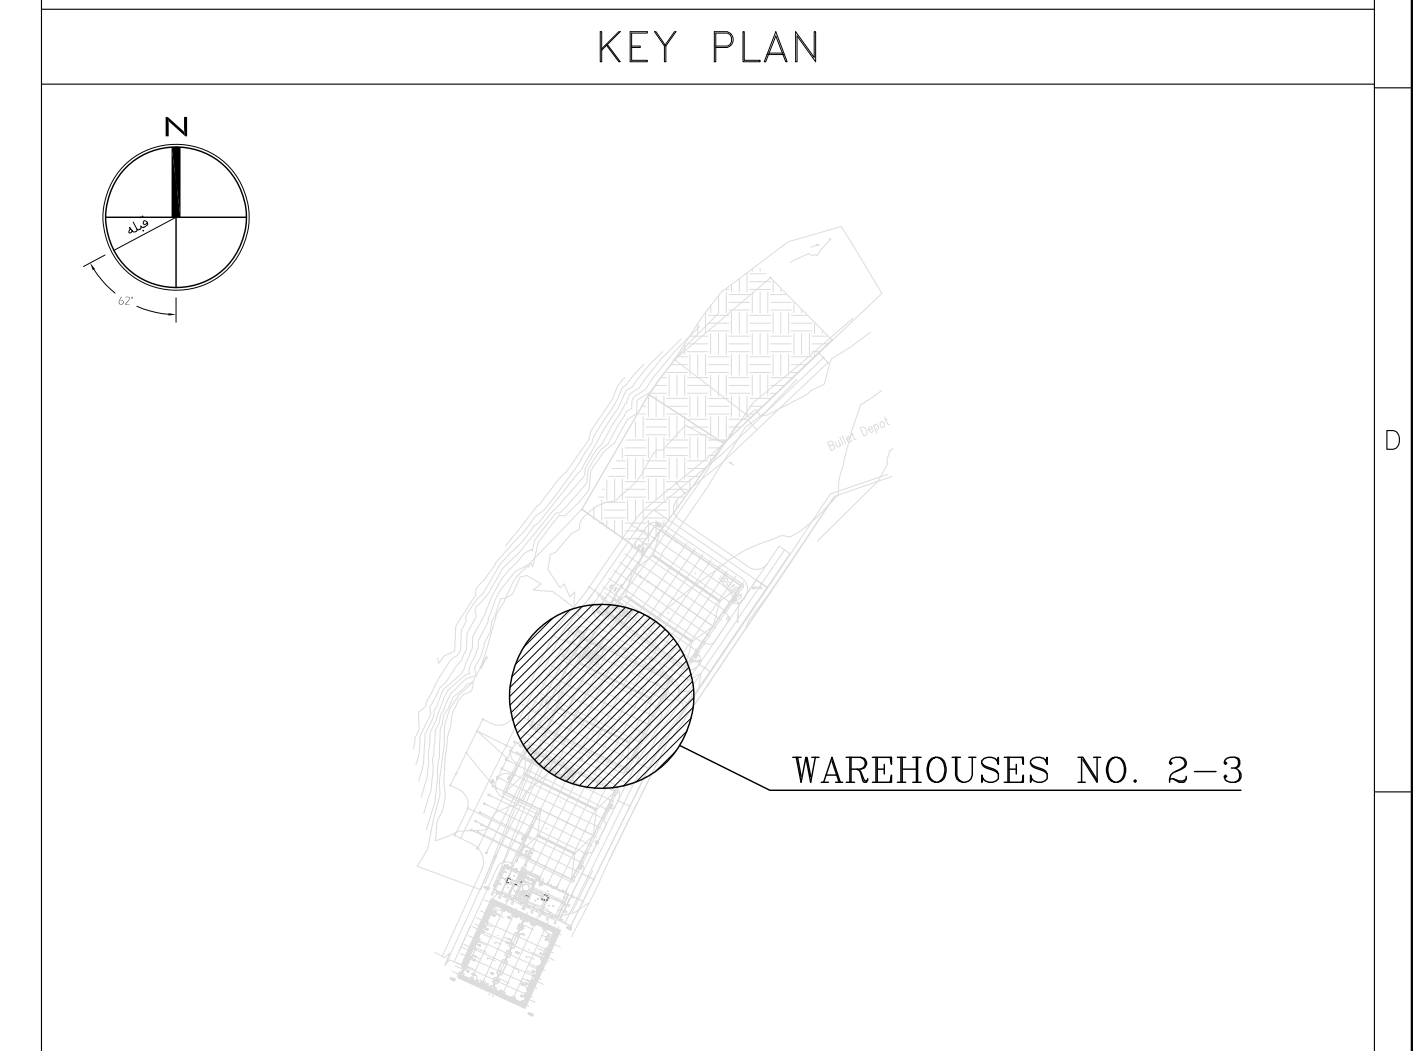

02	30.05.2023	ISSUED FOR CONSTRUCTION	M.MA&M.KH	M.AHMADI	H.NOROUZI	-			
01	23.05.2023	ISSUED FOR APPROVAL	M.MA&M.KH	M.AHMADI	H.NOROUZI	-			
00	09.02.2023	ISSUED FOR REVIEW AND COMMENT	M.MA&M.KH	M.AHMADI	H.NOROUZI	-			
REV.	DATE	DESCRIPTION	PREPARED	CHECKED	APPROVED	AUTHORIZED			
Client:			 NICICO NATIONAL IRANIAN COPPER INDUSTRIES CO.						
Consultant:			 Shargan Consultant Engineers						
 Mobina Engineering Co.			Contractor: 						
Project: Sarcheshmeh Copper Concentrator Expansion Plant (Phase.3)									
Title: ARCHITECTURAL DETAIL DESIGN FOR SARCHESHMEH WAREHOUSES NO. 2-3									
Document Number:			DATE	SIZE	SCALE	SHEET NO.	REV.		
12003-D-AR-DWG-312-WHS-002			30.05.2023	A1	AS SHOWN	10 OF 25	02	02	

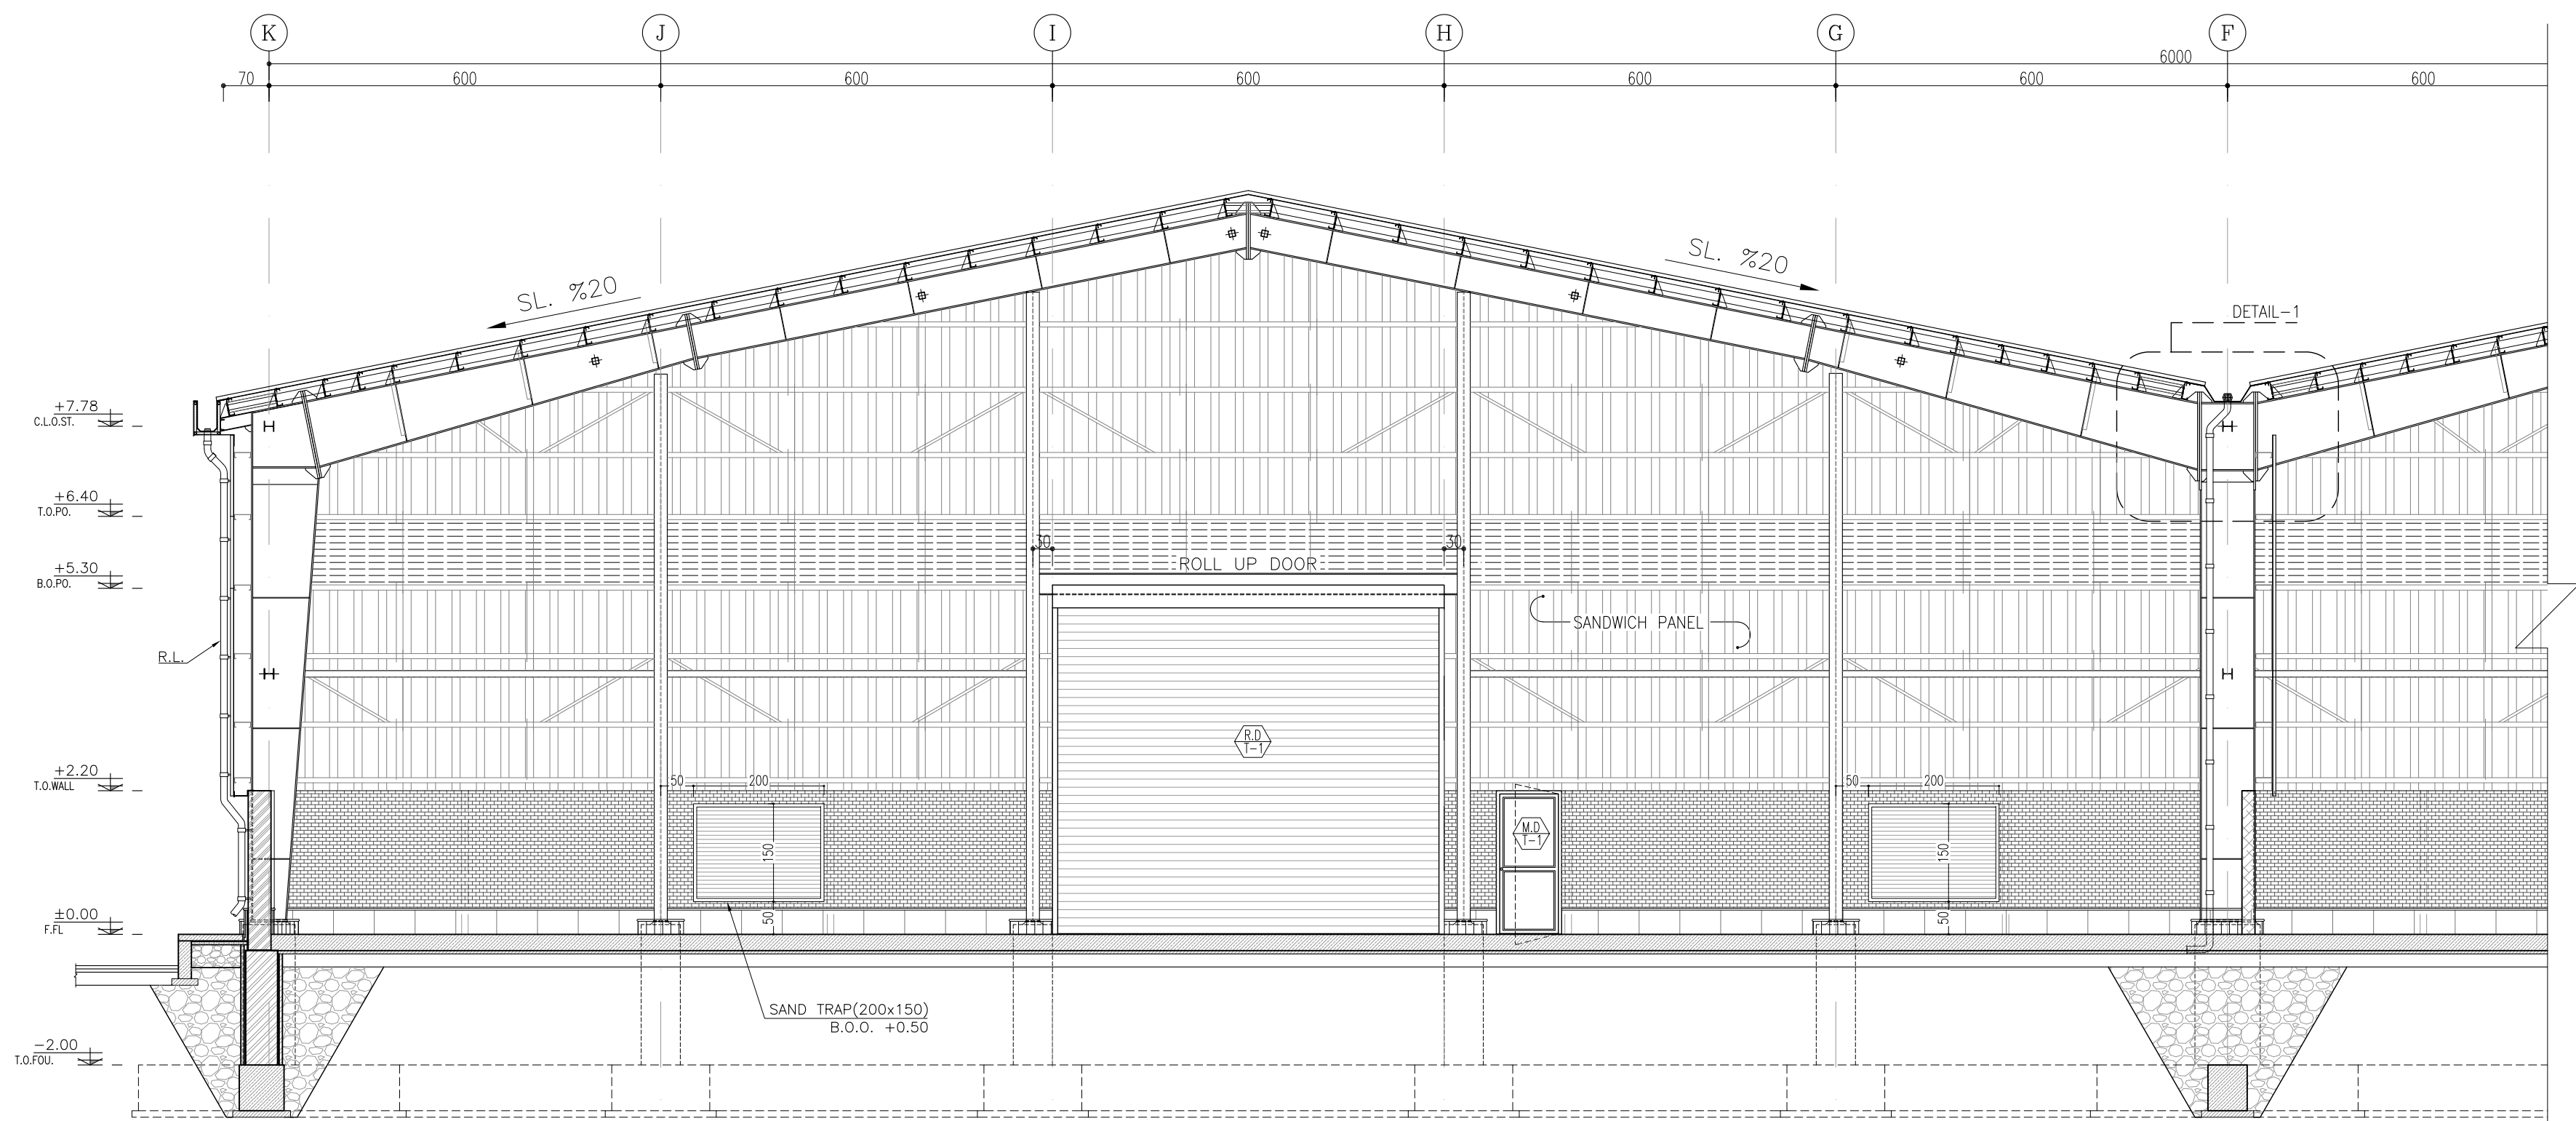

SECTION A-A
Sc:1/75

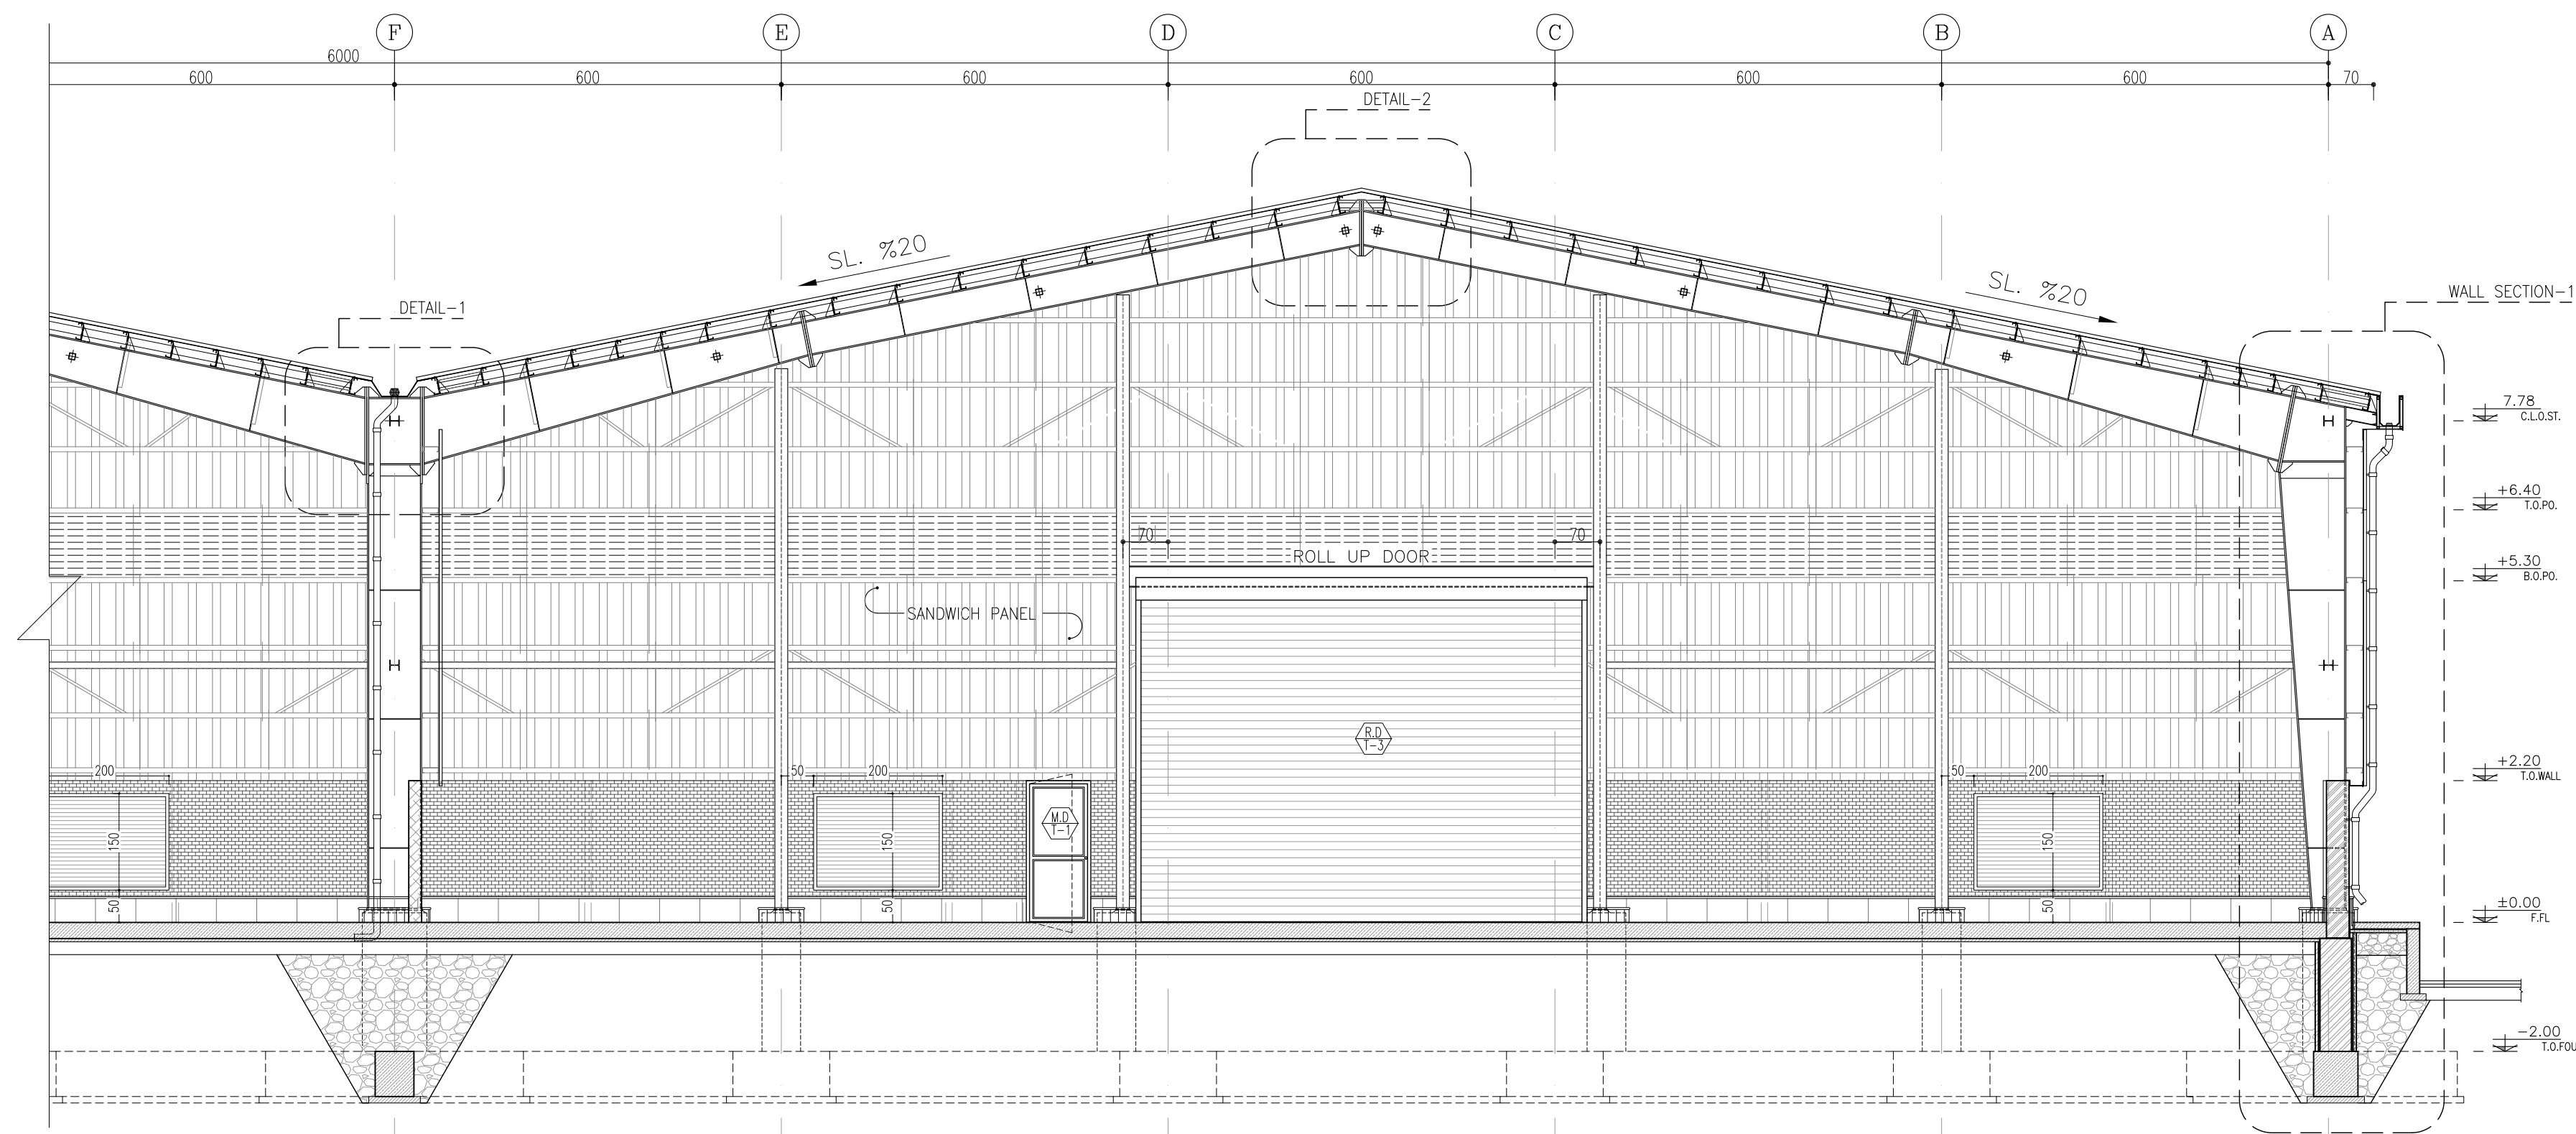

SECTION A-A
Sc:1/75

REFERENCE

REFERENCE. TITLE	REFERENCE. No.
FOUNDATION DRAWING	12003-D-ST-DWG-312-WHS-003
STRUCTURE DRAWING	12003-D-ST-DWG-312-WHS-004

NOTES


1. ALL DIMENSIONS ARE IN CENTIMETER & ALL ELEVATIONS ARE IN METER.
2. ALL DIMENSIONS AND ELEVATIONS SHALL BE CHECKED BY THE CONTRACTOR PRIOR TO CONSTRUCTION.
3. F.F.L. IN ARCHITECTURAL DOCUMENT IS EQUALS TO 2518.50
4. CONTRACTOR SHALL COMPARE ALL ARCHITECTURAL, MECHANICAL, ELECTRICAL, PIPING AND STRUCTURAL DRAWINGS AND IN CASE OF ANY CONFLICTS OR DISCREPANCY, INFORM THE ENGINEER.
5. ALL OPENINGS FOR PIPING/CABLING SHALL BE CONSIDERED AS PER RELATED DRAWINGS BEFORE CONSTRUCTION.

LEGEND

AREA NAME :

- | | |
|----------------------|-------------------|
| ① WAREHOUSE | ⑥ LOUNGE ROOM |
| ② ENTRANCE | ⑦ SUPERVISOR ROOM |
| ③ PANTRY | ⑧ W.C |
| ④ MANAGER ROOM | ⑨ LOCKER & SHOWER |
| ⑤ PAYMENT ORDER ROOM | ⑩ PRAYER ROOM |

KEY PLAN


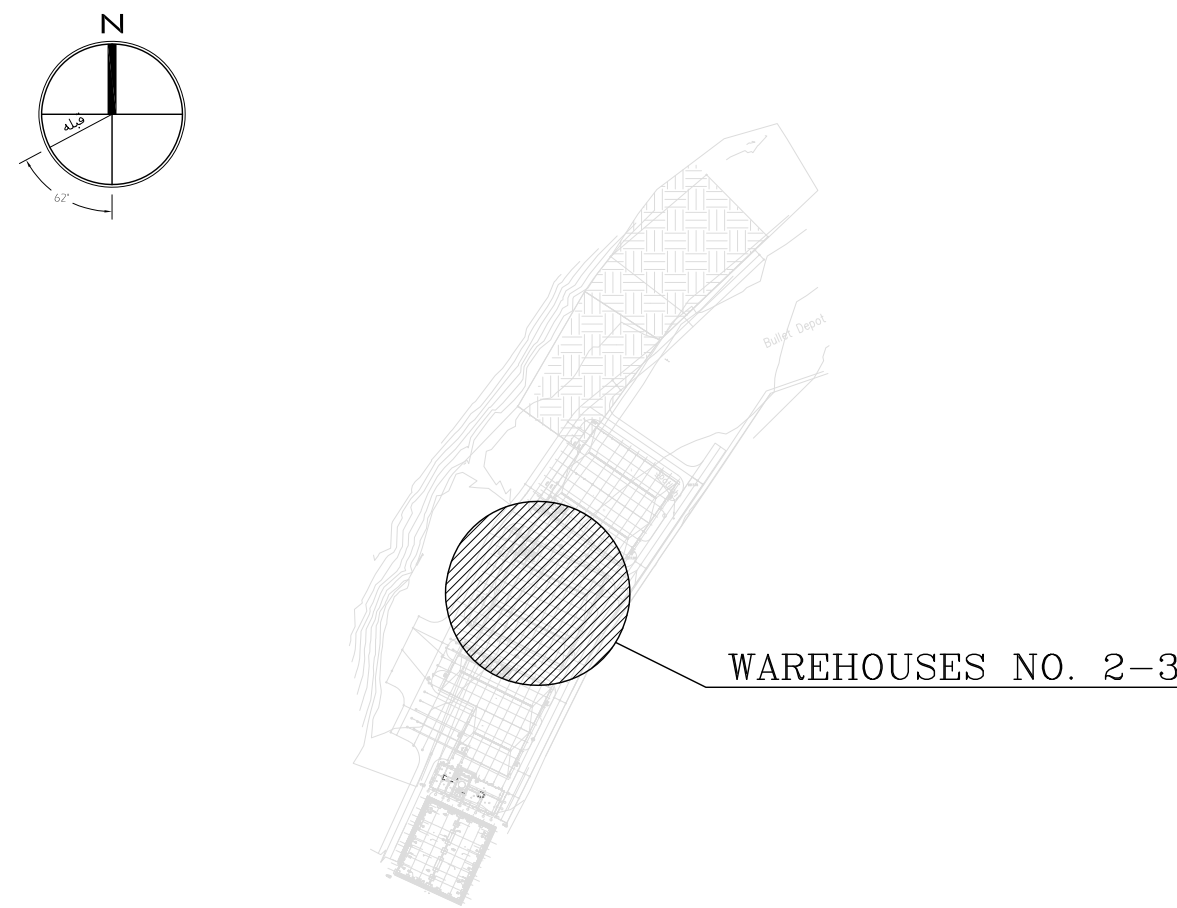


REV.	DATE	DESCRIPTION	PREPARED	CHECKED	APPROVED	AUTHORIZED
02	30.05.2023	ISSUED FOR CONSTRUCTION	M.MA&M.KH	M.AHMADI	H.NOROUZI	-
01	23.05.2023	ISSUED FOR APPROVAL	M.MA&M.KH	M.AHMADI	H.NOROUZI	-
00	09.02.2023	ISSUED FOR REVIEW AND COMMENT	M.MA&M.KH	M.AHMADI	H.NOROUZI	-

Client:	 NICICO NATIONAL IRANIAN COPPER INDUSTRIES Co.	MC:	 Shargan Consultant Engineers
Consultant:	 mobina Mobina Engineering Co.	Contractor:	 NIPEC

Project:	Sarcheshmeh Copper Concentrator Expansion Plant (Phase.3)
Title:	ARCHITECTURAL DETAIL DESIGN FOR SARCHESHMEH WAREHOUSES NO. 2-3


Document Number:	DATE	SIZE	SCALE	SHEET NO.	REV.
12003-D-AR-DWG-312-WHS-002	30.05.2023	A1	AS SHOWN	11 OF 25	02

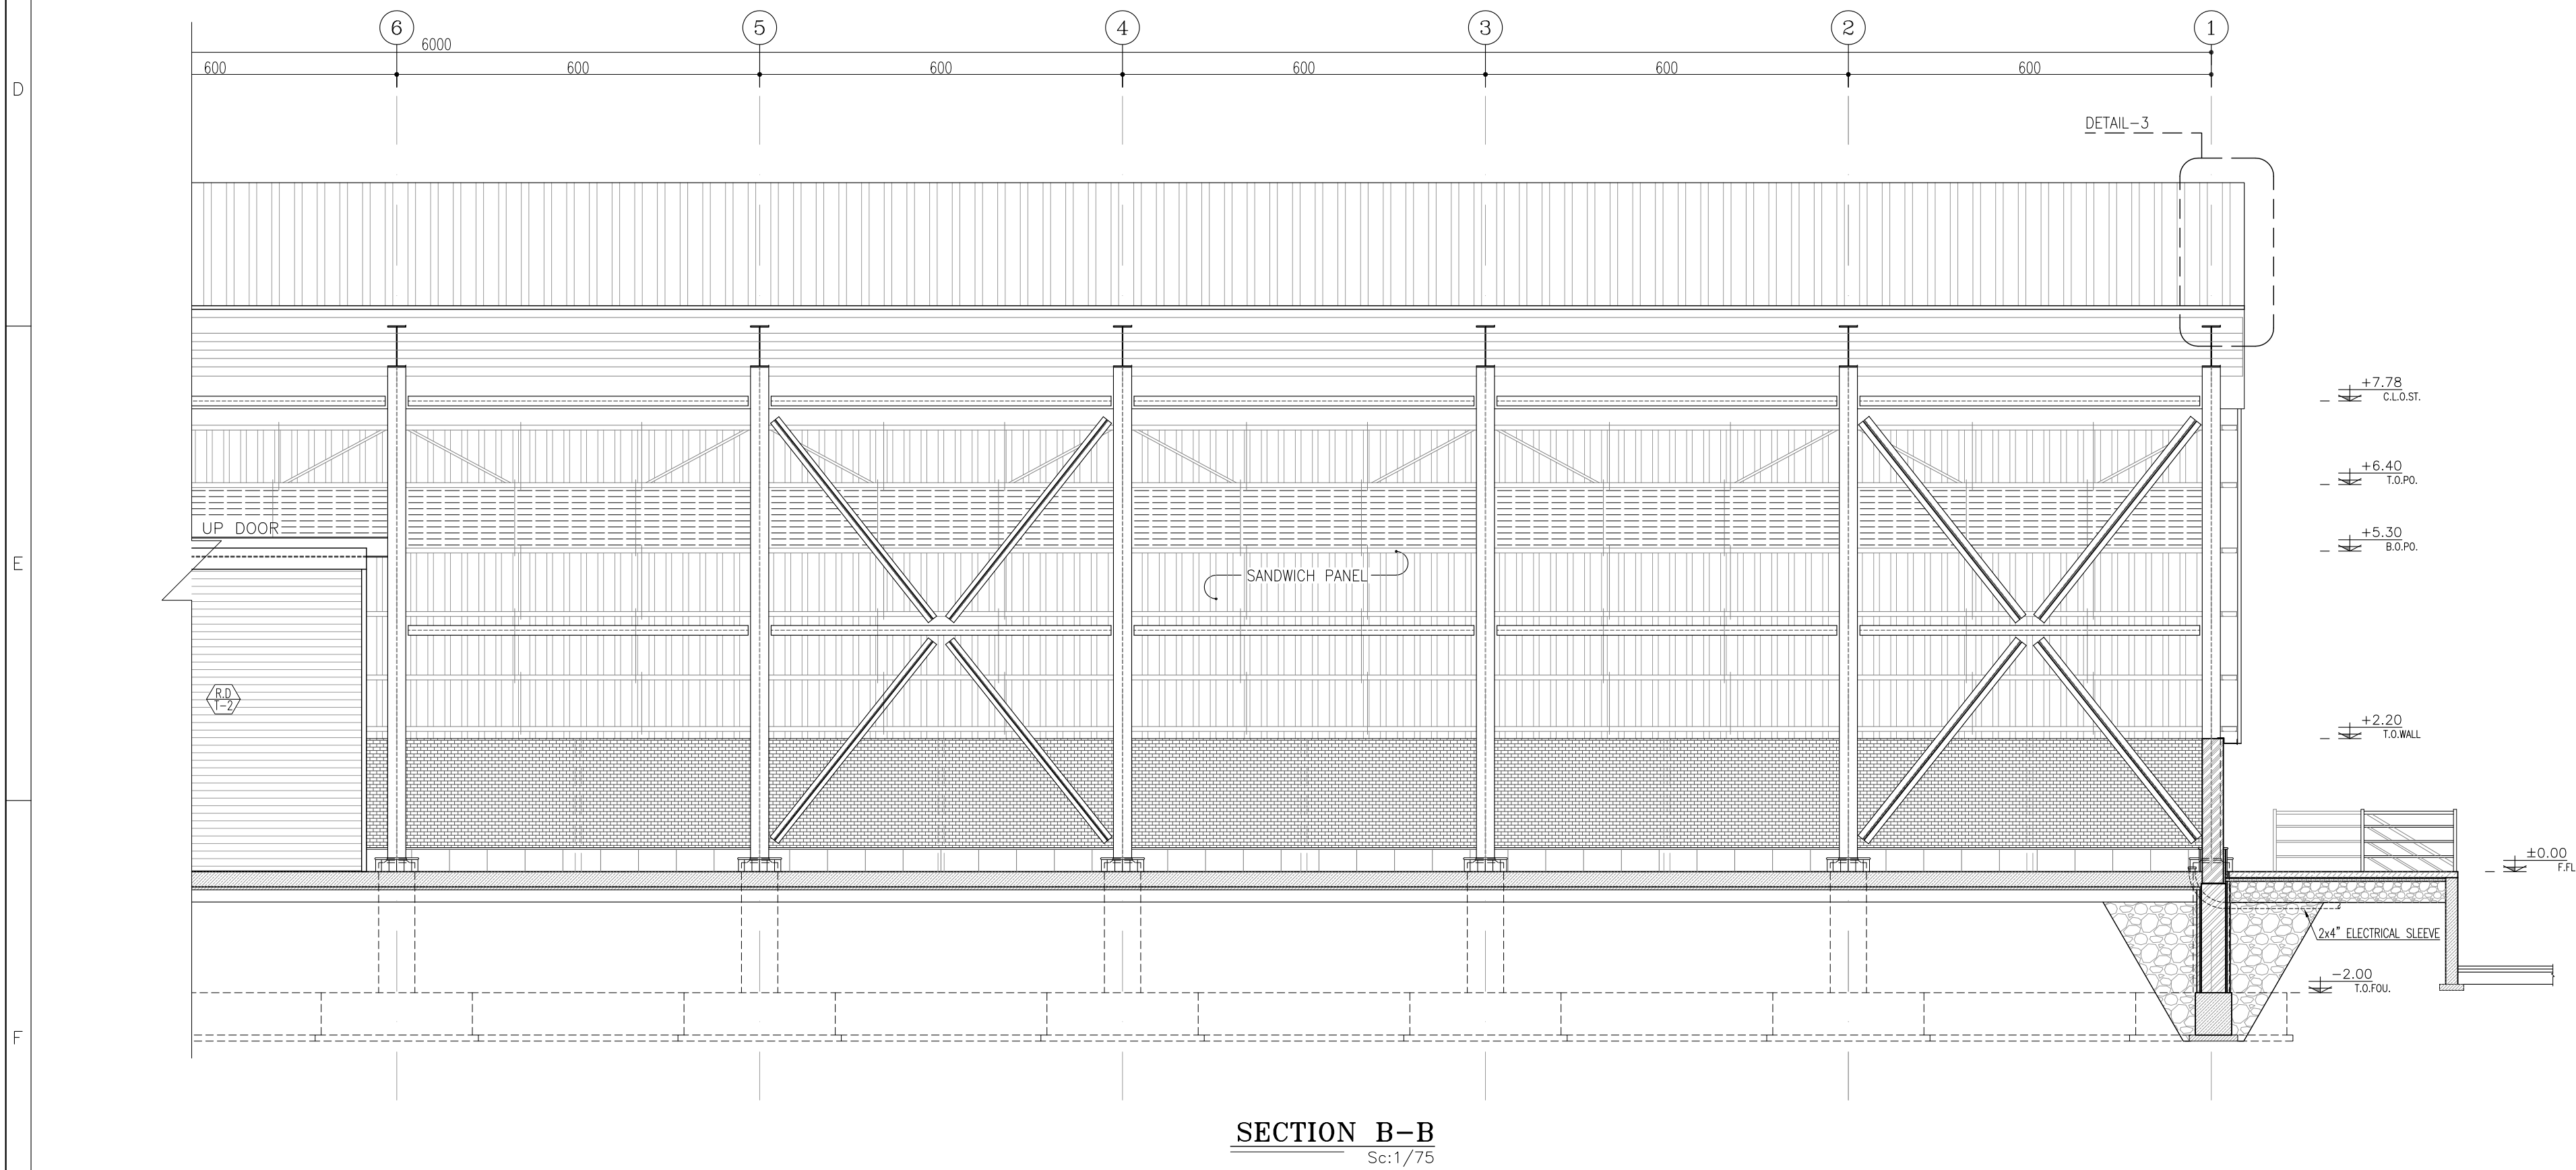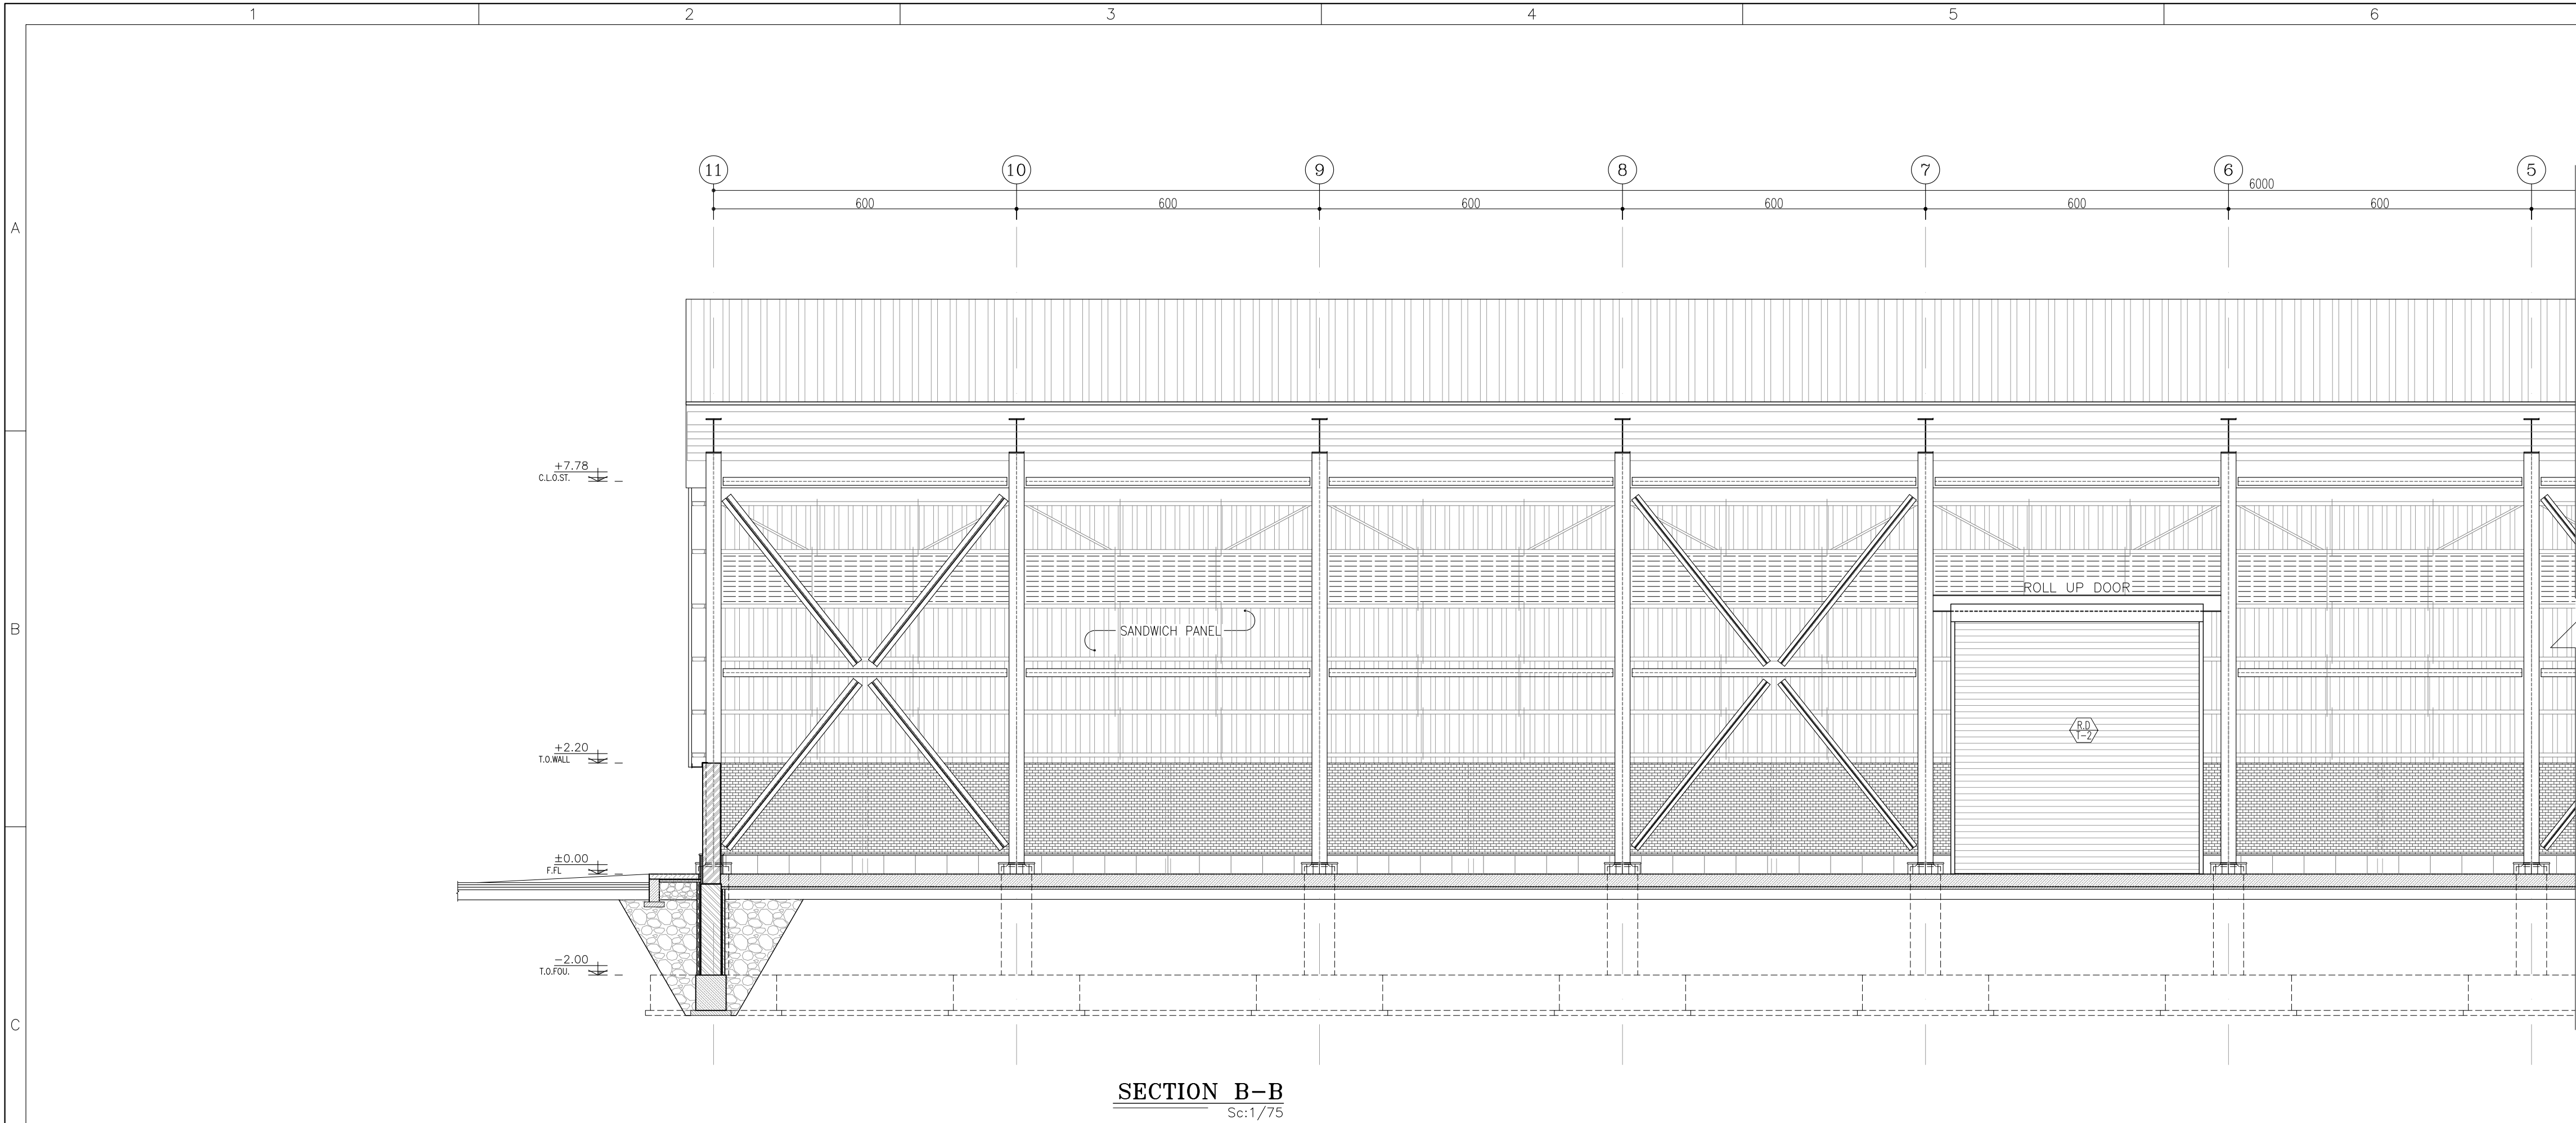


REFERENCE	
REFERENCE. TITLE	REFERENCE. No.
FOUNDATION DRAWING	12003-D-ST-DWG-312-WHS-003
STRUCTURE DRAWING	12003-D-ST-DWG-312-WHS-004

NOTES	
1. ALL DIMENSIONS ARE IN CENTIMETER & ALL ELEVATIONS ARE IN METER.	
2. ALL DIMENSIONS AND ELEVATIONS SHALL BE CHECKED BY THE CONTRACTOR PRIOR TO CONSTRUCTION.	
3. F.F.L. IN ARCHITECTURAL DOCUMENT IS EQUALS TO 2518.50	
4. CONTRACTOR SHALL COMPARE ALL ARCHITECTURAL, MECHANICAL, ELECTRICAL, PIPING AND STRUCTURAL DRAWINGS AND IN CASE OF ANY CONFLICTS OR DISCREPANCY, INFORM THE ENGINEER.	
5. ALL OPENINGS FOR PIPING/CABLING SHALL BE CONSIDERED AS PER RELATED DRAWINGS BEFORE CONSTRUCTION.	


LEGEND	
AREA NAME :	
① WAREHOUSE	⑥ LOUNGE ROOM
② ENTRANCE	⑦ SUPERVISOR ROOM
③ PANTRY	⑧ W.C
④ MANAGER ROOM	⑨ LOCKER & SHOWER
⑤ PAYMENT ORDER ROOM	⑩ PRAYER ROOM

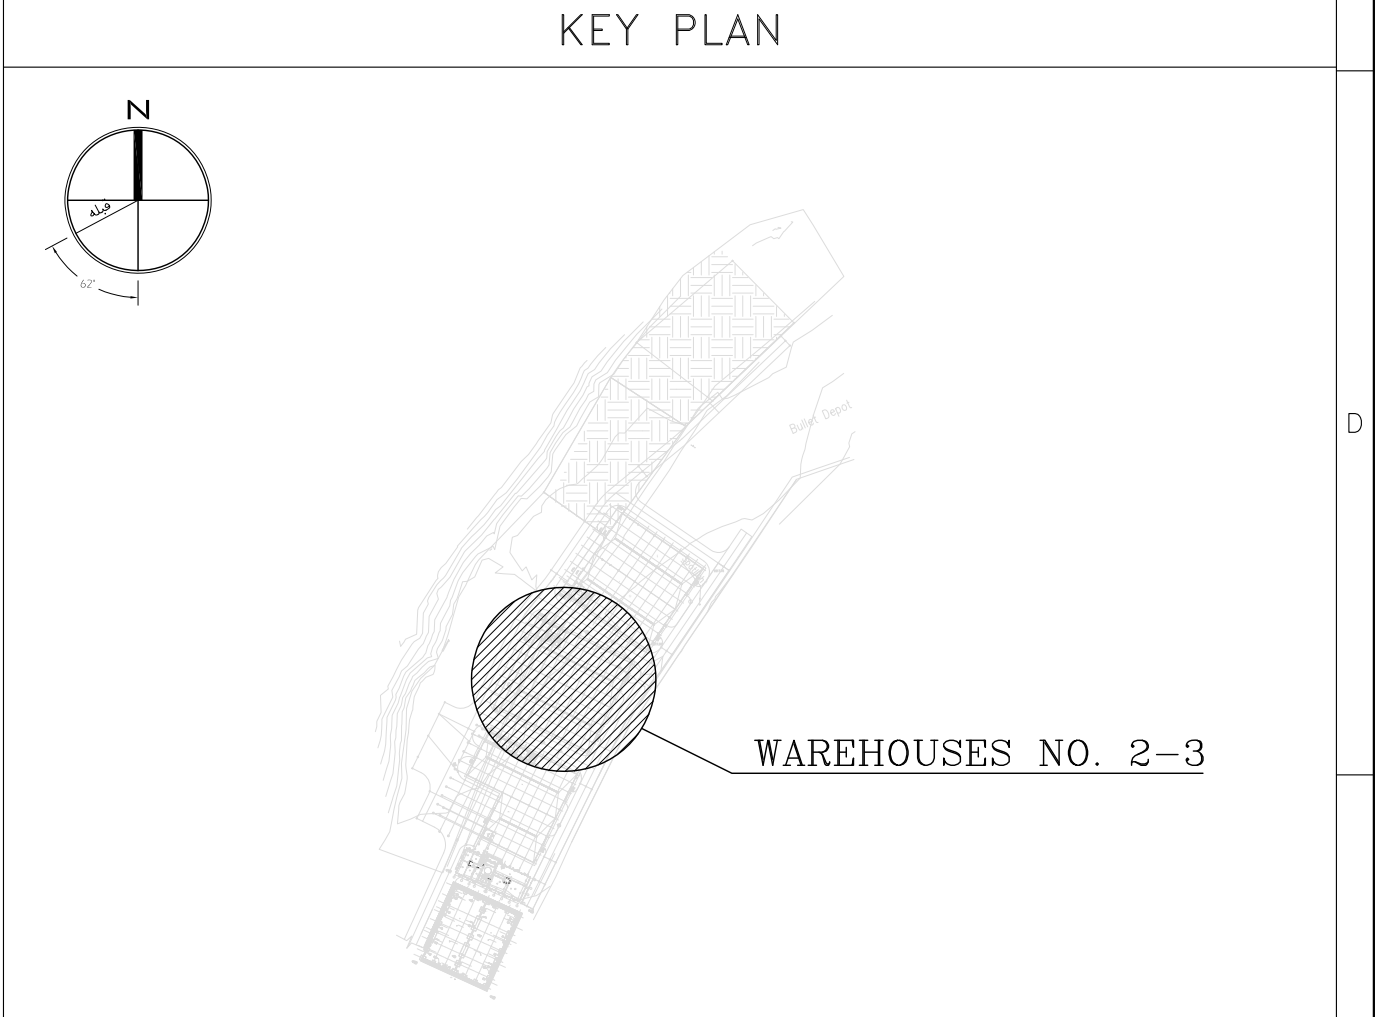


02	30.05.2023	ISSUED FOR CONSTRUCTION	M.MA&M.KH	M.AHMADI	H.NOROUZI	-	
01	23.05.2023	ISSUED FOR APPROVAL	M.MA&M.KH	M.AHMADI	H.NOROUZI	-	
00	09.02.2023	ISSUED FOR REVIEW AND COMMENT	M.MA&M.KH	M.AHMADI	H.NOROUZI	-	
REV.	DATE	DESCRIPTION	PREPARED	CHECKED	APPROVED	AUTHORIZED	
Client:			MC:				
 NICICO NATIONAL IRANIAN COPPER INDUSTRIES Co.			 Shargan Consultant Engineers				
Consultant:			Contractor:				
 Mobina Engineering Co.			 NIPEC				
Project:							
Sarcheshmeh Copper Concentrator Expansion Plant (Phase.3)							
Title:							
ARCHITECTURAL DETAIL DESIGN FOR SARCHESHMEH WAREHOUSES NO. 2-3							
Document Number:			DATE	SIZE	SCALE	SHEET NO.	REV.
12003-D-AR-DWG-312-WHS-002			30.05.2023	A1	AS SHOWN	12 OF 25	02 02

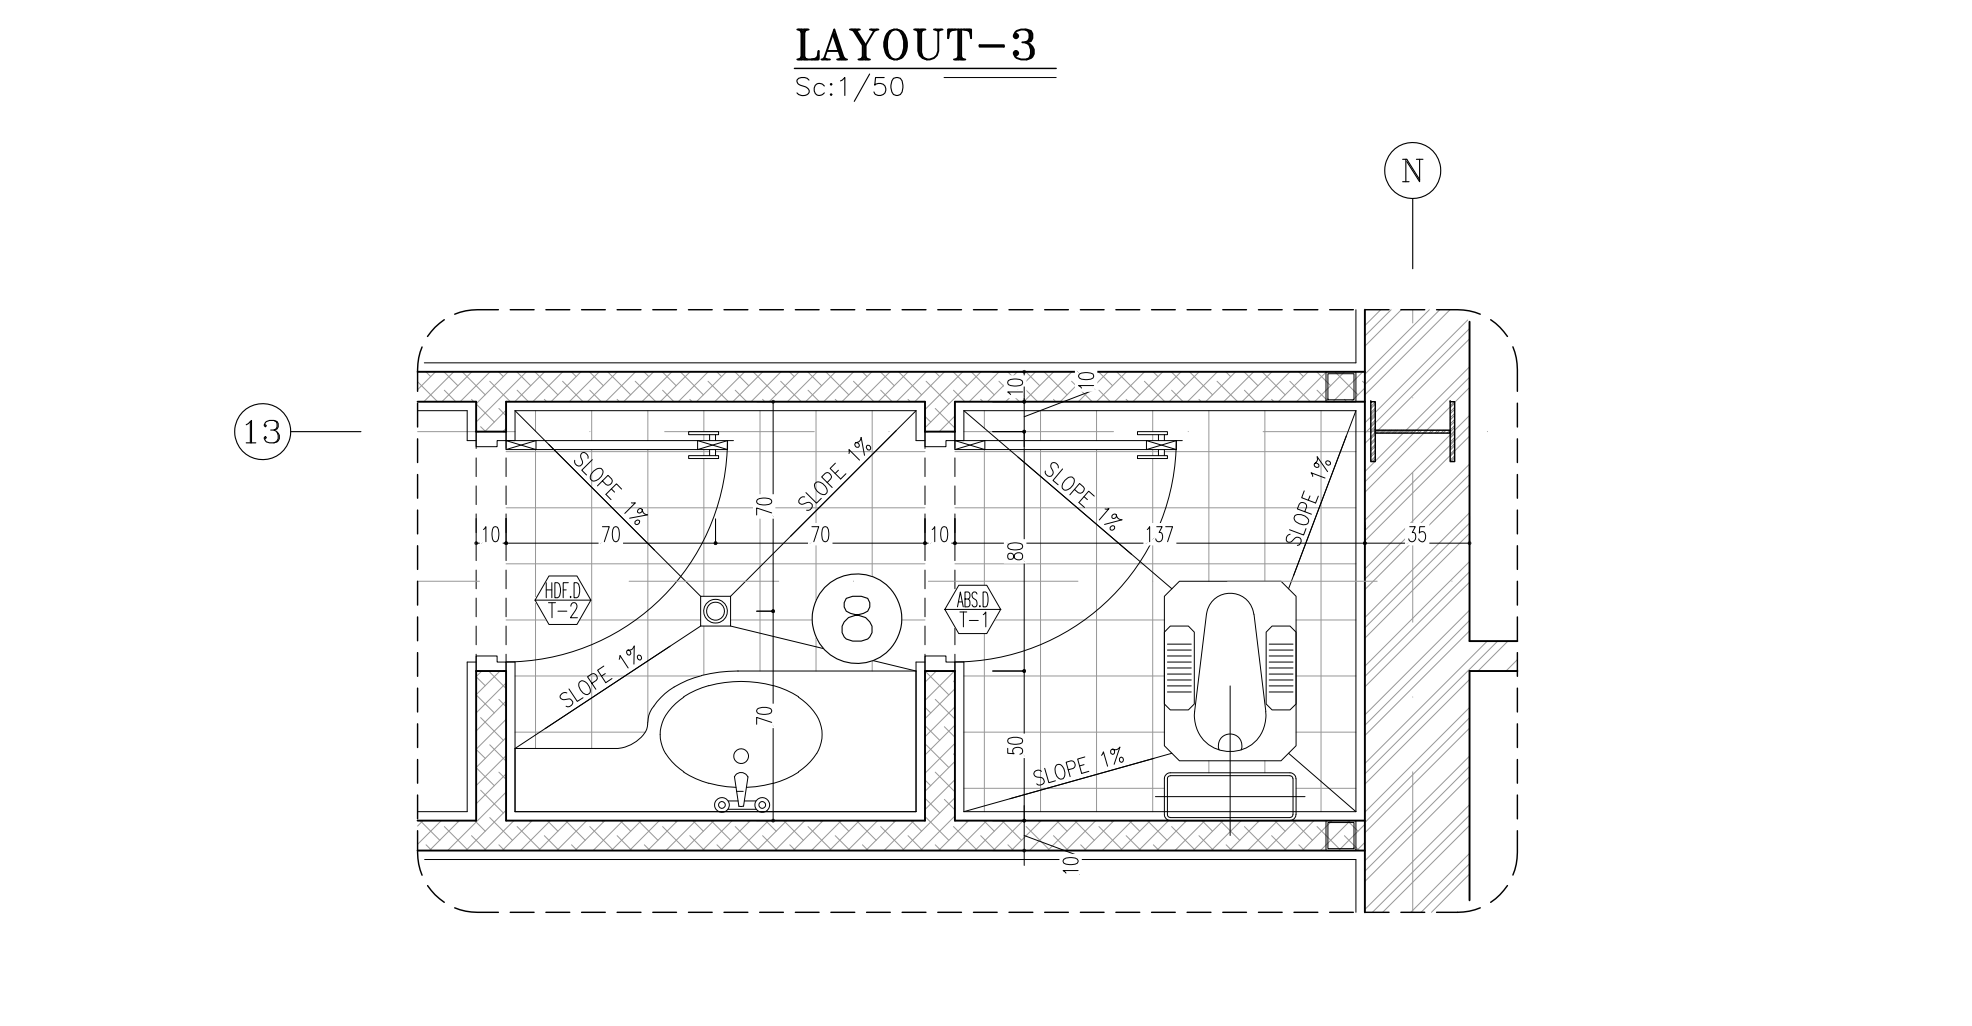

7			8		
REFERENCE					
REFERENCE. TITLE			REFERENCE. No.		
FOUNDATION DRAWING			12003-D-ST-DWG-312-WHS-003		
STRUCTURE DRAWING			12003-D-ST-DWG-312-WHS-004		
NOTES					
1. ALL DIMENSIONS ARE IN CENTIMETER & ALL ELEVATIONS ARE IN METER.					
2. ALL DIMENSIONS AND ELEVATIONS SHALL BE CHECKED BY THE CONTRACTOR PRIOR TO CONSTRUCTION.					
3. F.F.L. IN ARCHITECTURAL DOCUMENT IS EQUALS TO 2518.50					
4. CONTRACTOR SHALL COMPARE ALL ARCHITECTURAL, MECHANICAL, ELECTRICAL, PIPING AND STRUCTURAL DRAWINGS AND IN CASE OF ANY CONFLICTS OR DISCREPANCY, INFORM THE ENGINEER.					
5. ALL OPENINGS FOR PIPING/CABLING SHALL BE CONSIDERED AS PER RELATED DRAWINGS BEFORE CONSTRUCTION.					
LEGEND					
AREA NAME :					
① WAREHOUSE			⑥ LOUNGE ROOM		
② ENTRANCE			⑦ SUPERVISOR ROOM		
③ PANTRY			⑧ W.C		
④ MANAGER ROOM			⑨ LOCKER & SHOWER		
⑤ PAYMENT ORDER ROOM			⑩ PRAYER ROOM		
KEY PLAN					
<					

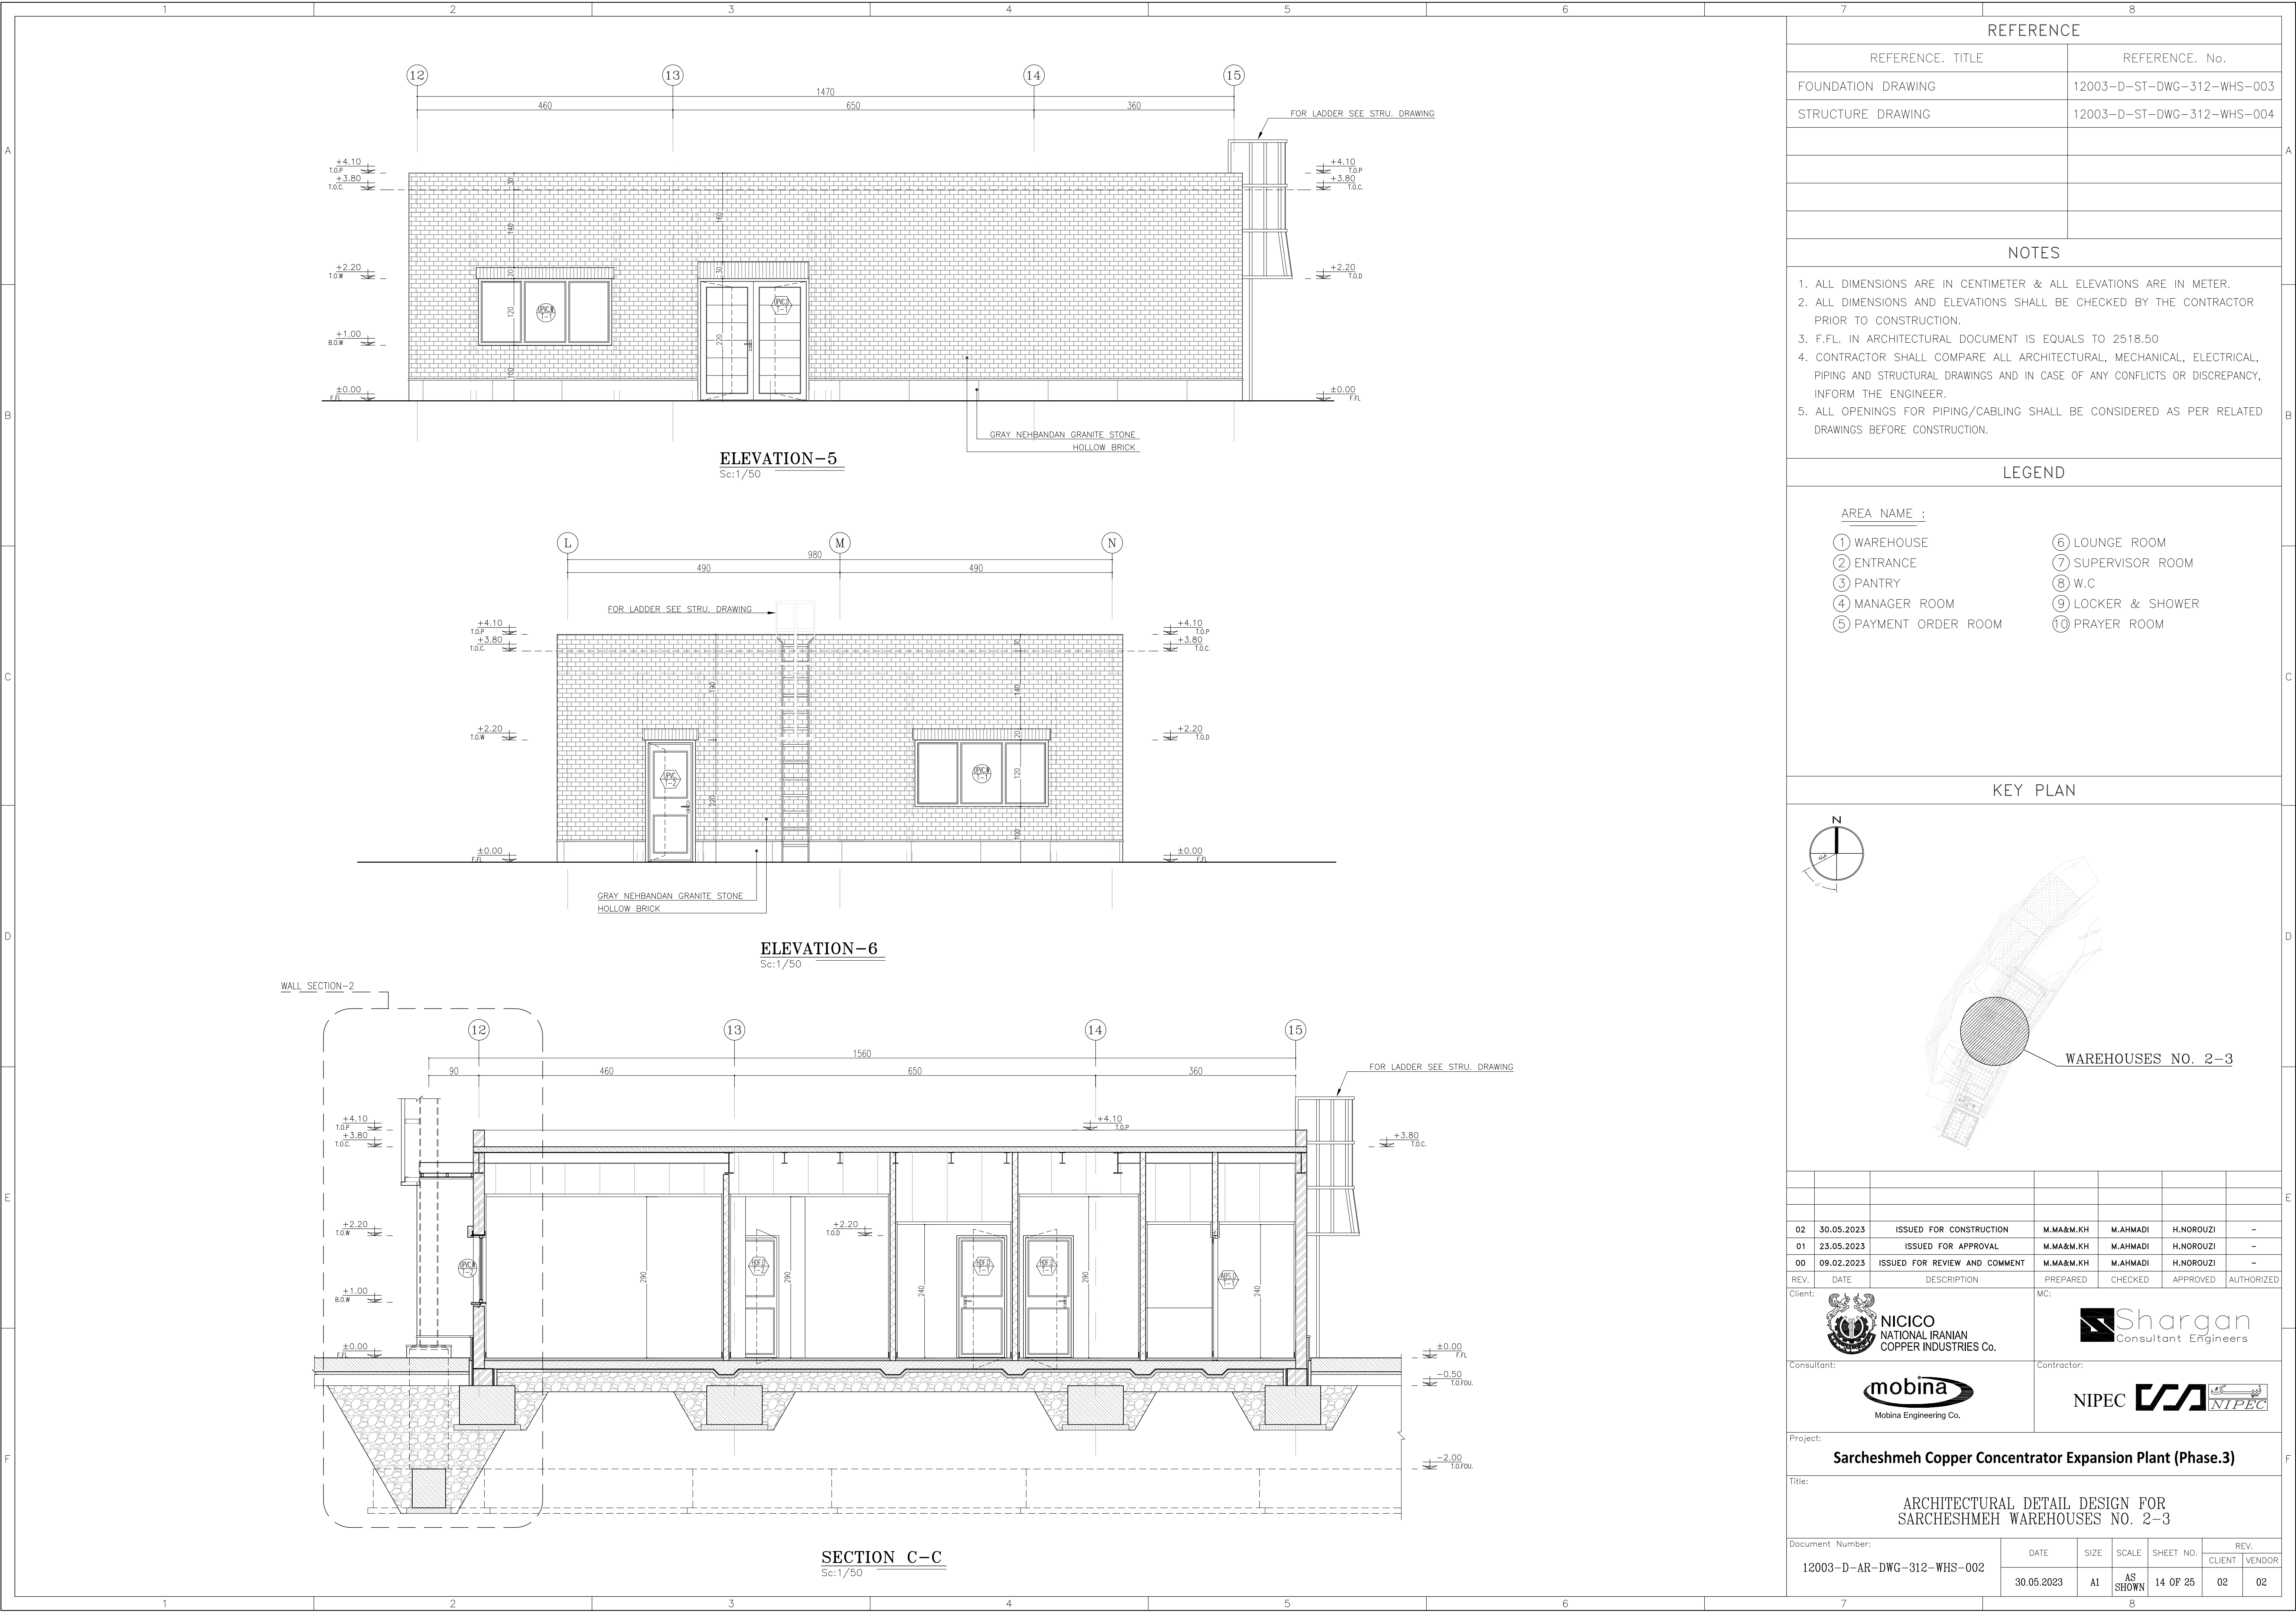

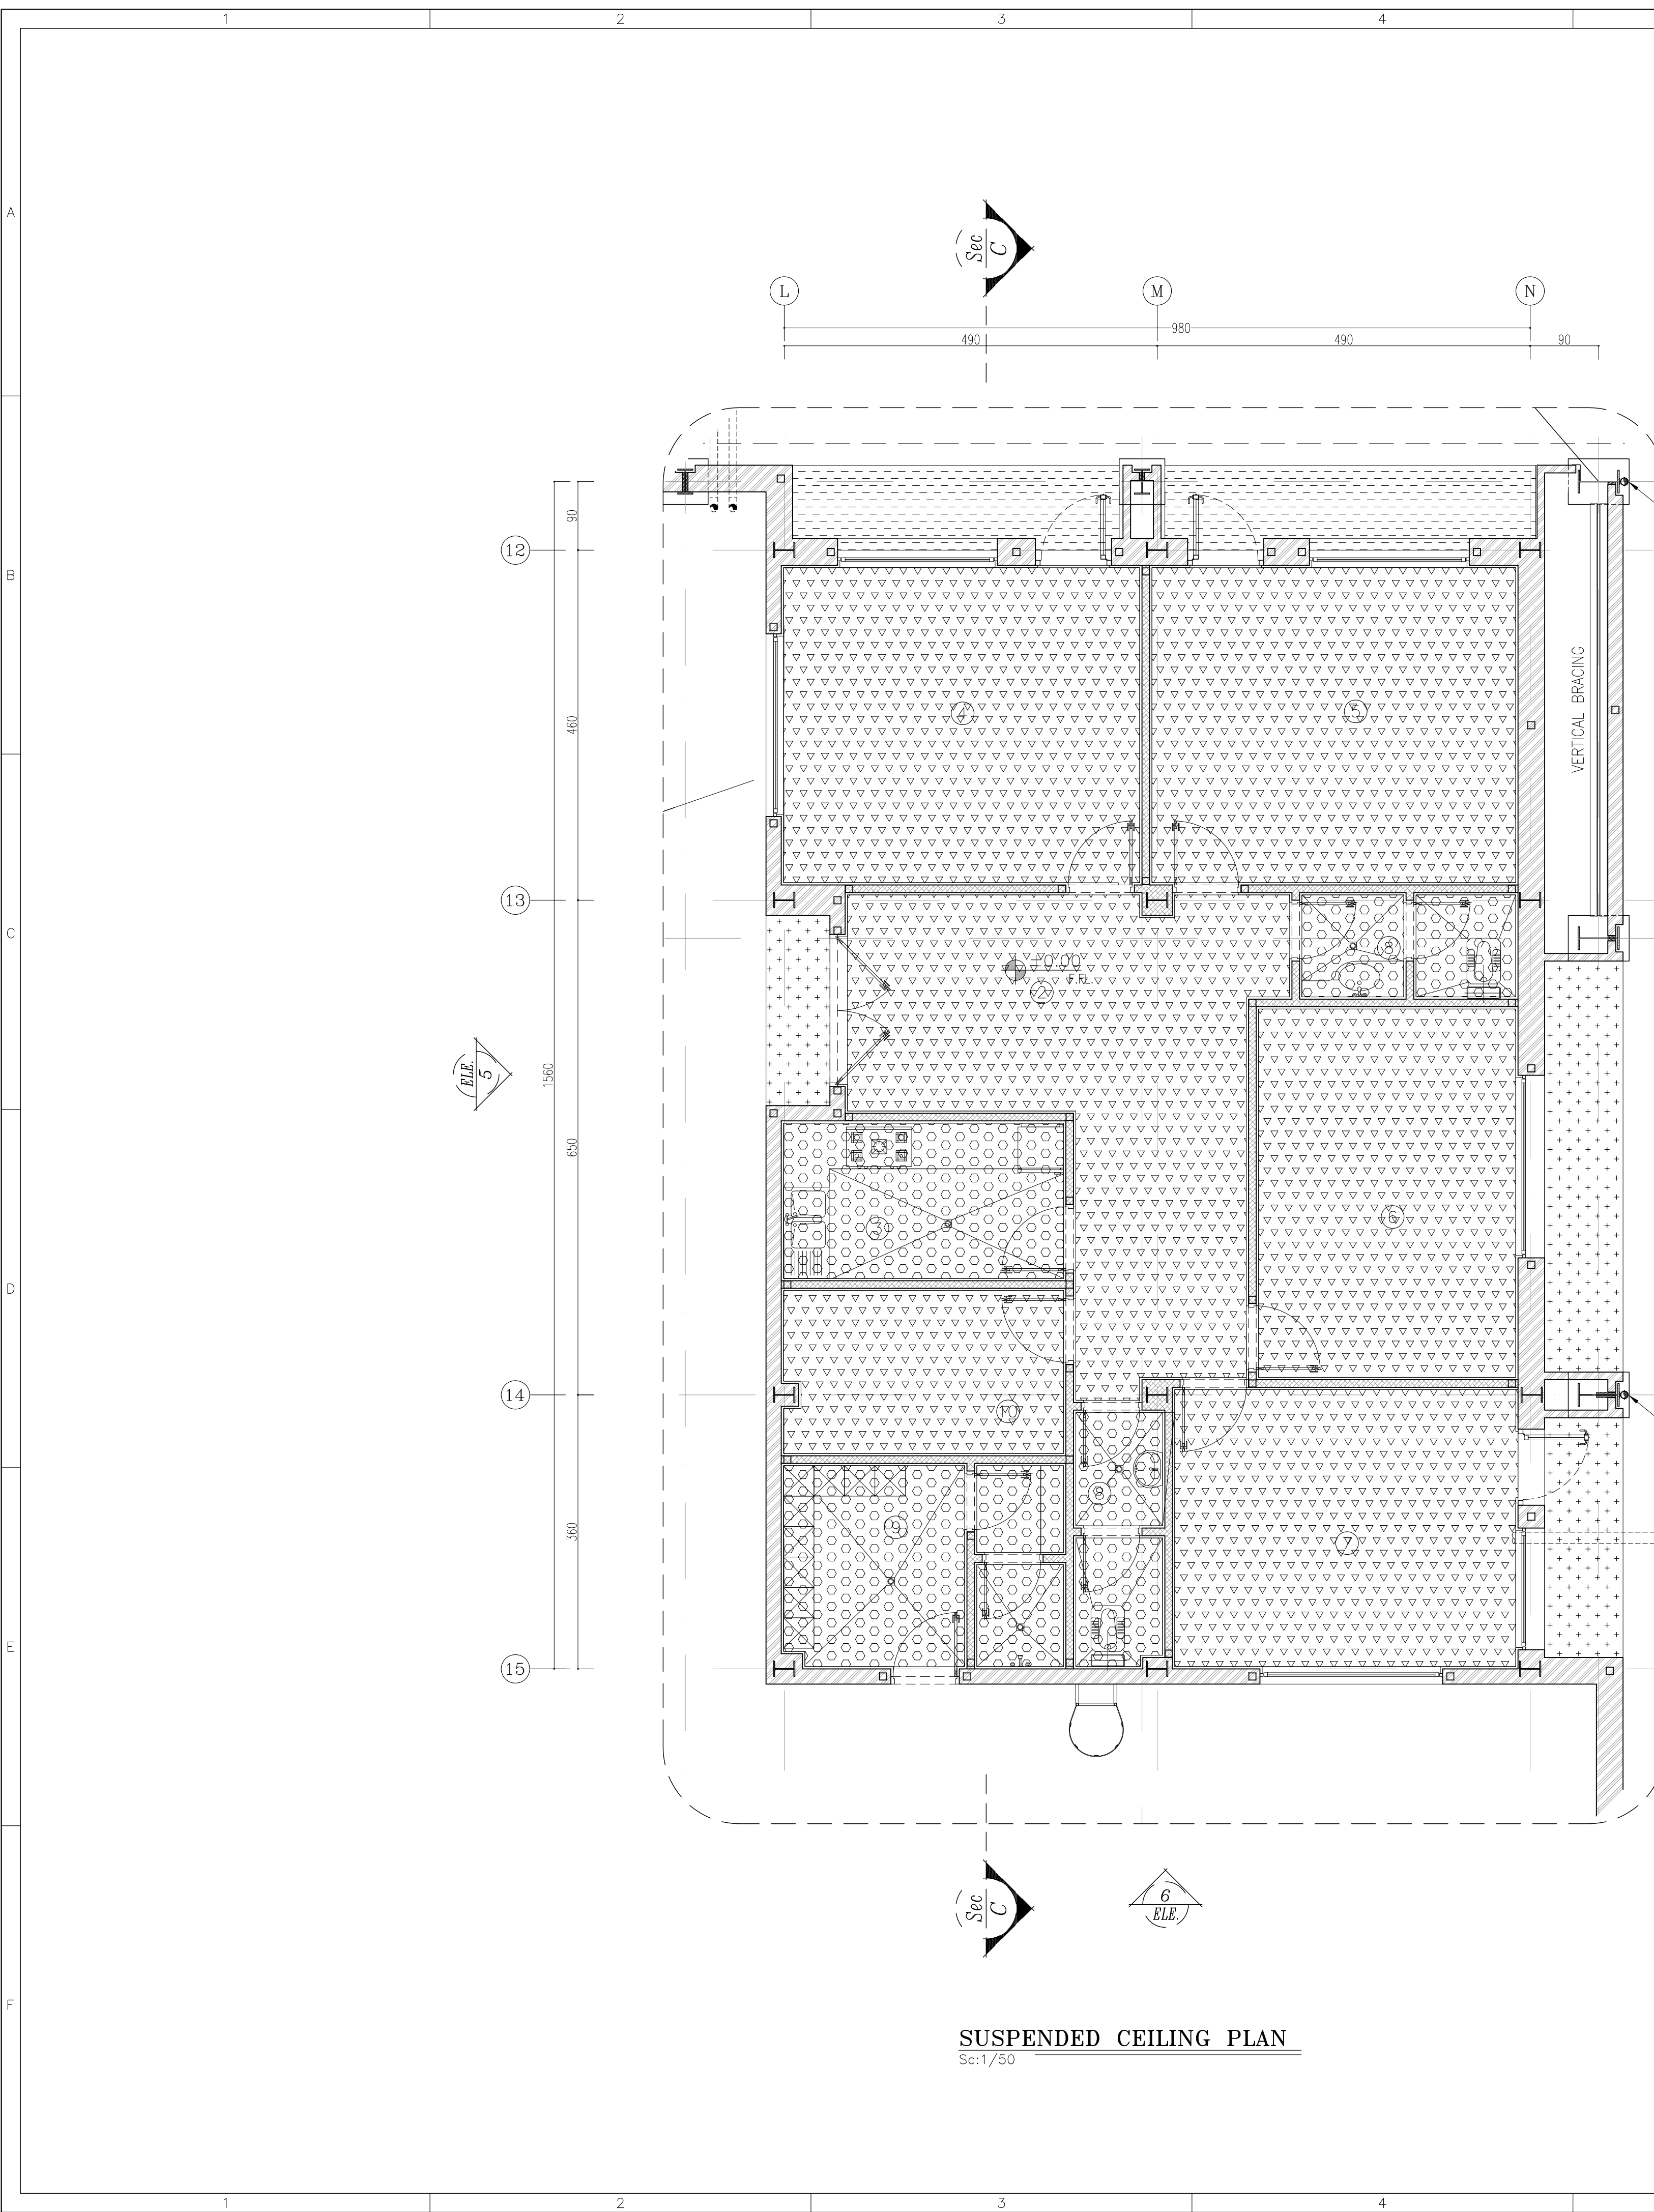

REFERENCE					
REFERENCE. TITLE			REFERENCE. No.		
FOUNDATION DRAWING			12003-D-ST-DWG-312-WHS-003		
STRUCTURE DRAWING			12003-D-ST-DWG-312-WHS-004		
NOTES					
1. ALL DIMENSIONS ARE IN CENTIMETER & ALL ELEVATIONS ARE IN METER.					
2. ALL DIMENSIONS AND ELEVATIONS SHALL BE CHECKED BY THE CONTRACTOR PRIOR TO CONSTRUCTION.					
3. F.F.L. IN ARCHITECTURAL DOCUMENT IS EQUALS TO 2518.50					
4. CONTRACTOR SHALL COMPARE ALL ARCHITECTURAL, MECHANICAL, ELECTRICAL, PIPING AND STRUCTURAL DRAWINGS AND IN CASE OF ANY CONFLICTS OR DISCREPANCY, INFORM THE ENGINEER.					
5. ALL OPENINGS FOR PIPING/CABLING SHALL BE CONSIDERED AS PER RELATED DRAWINGS BEFORE CONSTRUCTION.					
LEGEND					
AREA NAME :					
① WAREHOUSE			⑥ LOUNGE ROOM		
② ENTRANCE			⑦ SUPERVISOR ROOM		
③ PANTRY			⑧ W.C		
④ MANAGER ROOM			⑨ LOCKER & SHOWER		
⑤ PAYMENT ORDER ROOM			⑩ PRAYER ROOM		
KEY PLAN					




NOTES

- ## LEGEND

AREA NAME :

- ## KEY PLAN

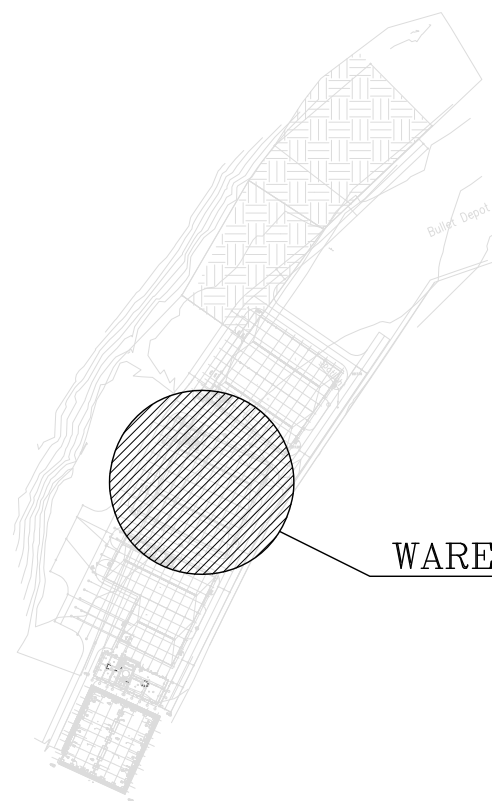

Client: 



Consultant:

Contractor:



Mobina Engineering Co.

NIPEC  


Project:

Sarcheshmeh Copper Concentrator Expansion Plant (Phase.3)

Title:

ARCHITECTURAL DETAIL DESIGN FOR SARCHESHMEH WAREHOUSES NO. 2-3

Document Number: 12003-D-AR-DWG-312-WHS-002	DATE	SIZE	SCALE	SHEET NO.	REV.	
	30.05.2023	A1	AS SHOWN	16 OF 25	CLIENT	VENDOR

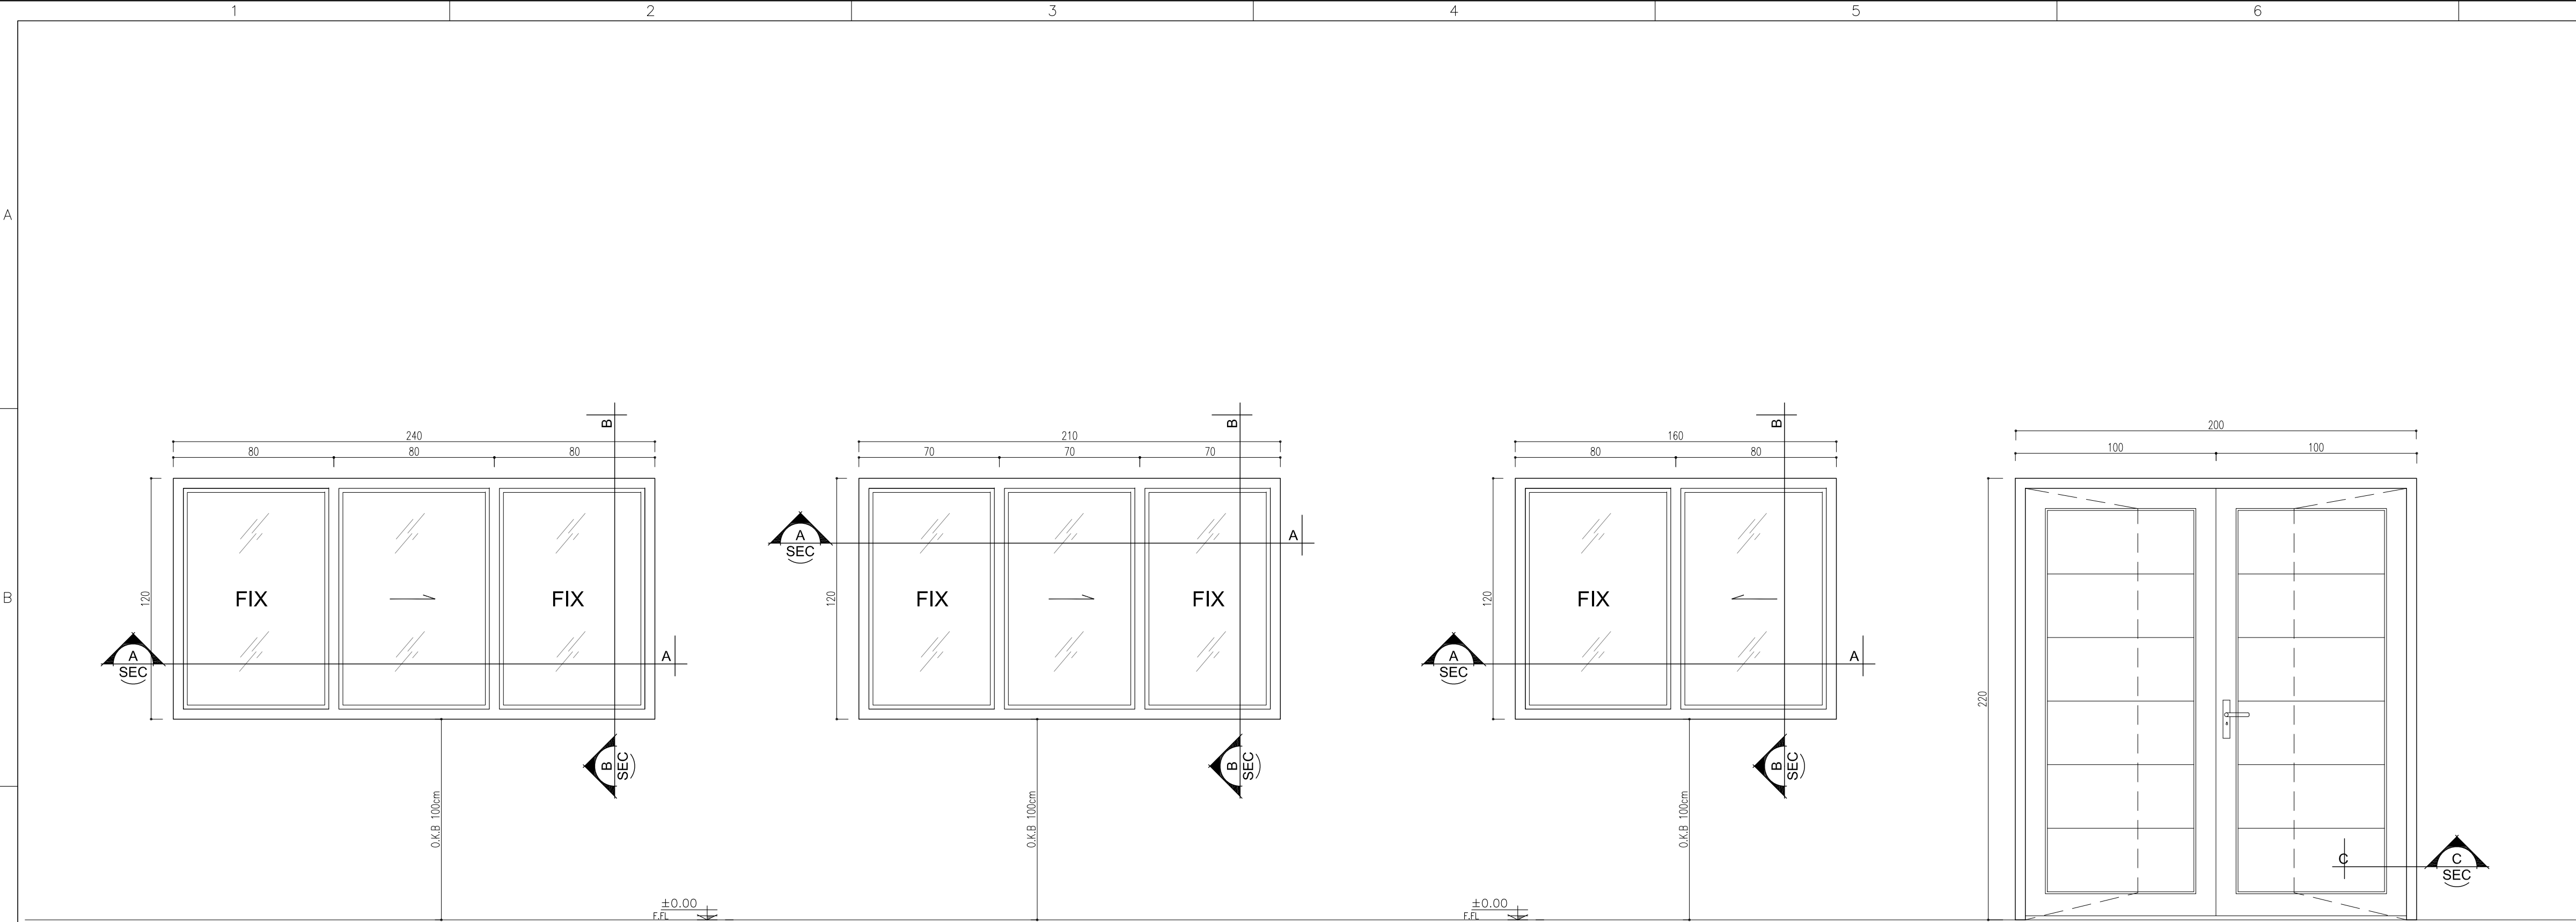

UPVC WINDOW – Type 1

NUMBER: 3
Sc:1/20
** DOUBLE-GLAZED WINDOW



UPVC WINDOW – Type 2

NUMBER: 2
Sc:1/20
** DOUBLE-GLAZED WINDOW




UPVC WINDOW – Type 3

NUMBER: 1
Sc:1/20
** DOUBLE-GLAZED WINDOW




UPVC DOOR – Type 1

NUMBER: 1
RIGHT HANDED: –
LEFT HANDED: –
Sc:1/20

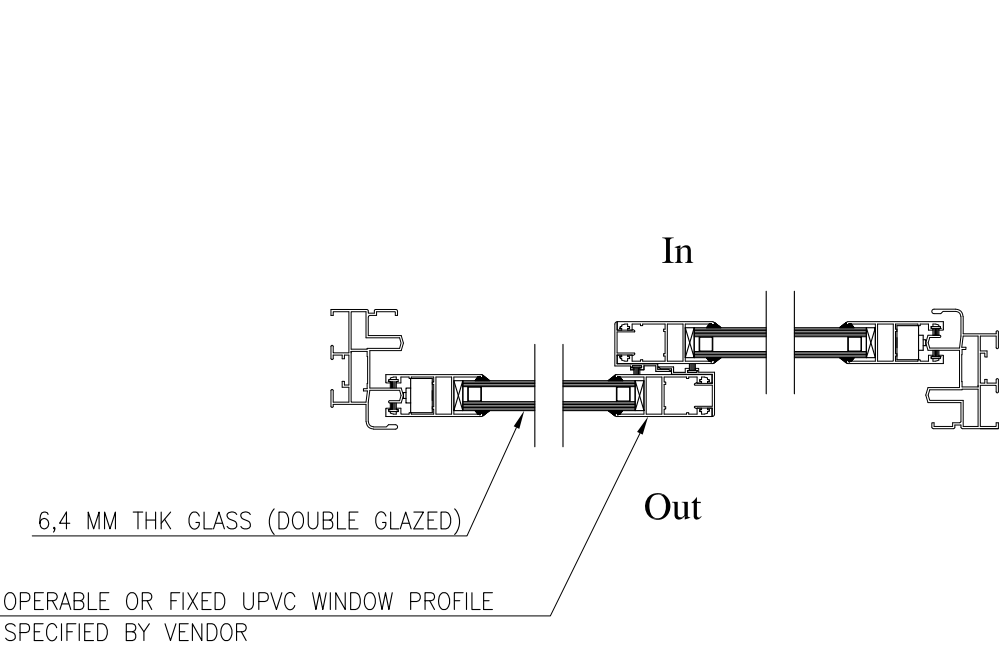


SECTION A–A

Sc:1/5

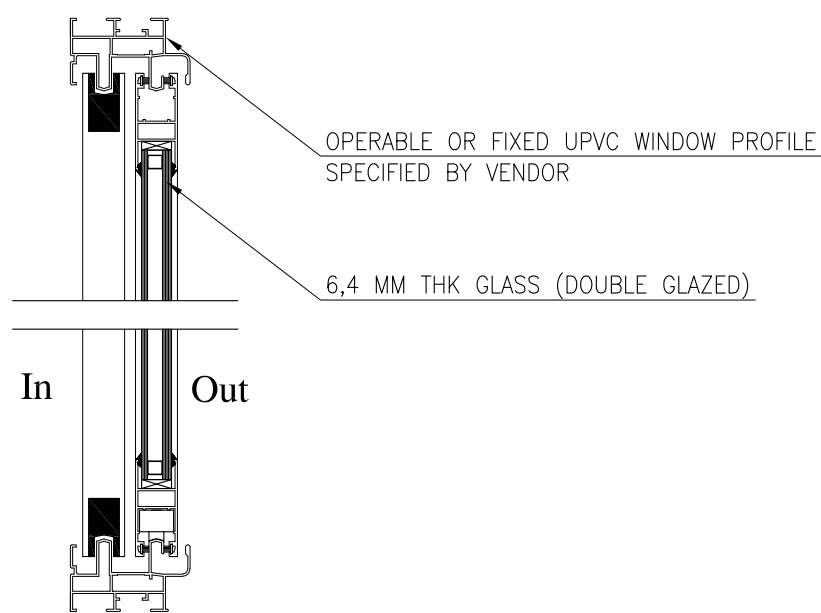


SECTION B–B

Sc:1/5

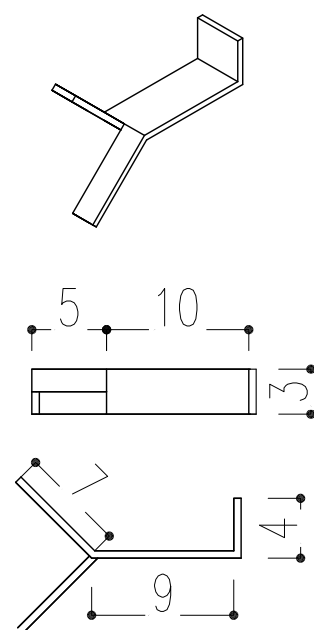

SECTION C–C

Sc:1/5

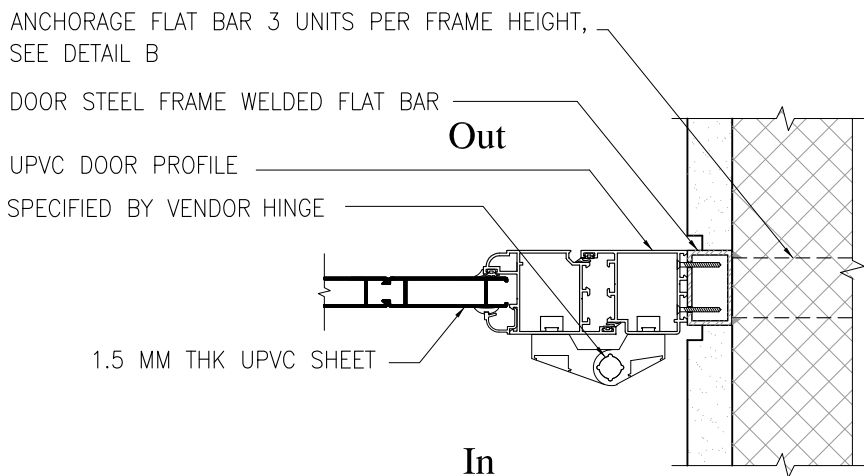

REFERENCE

REFERENCE. TITLE	REFERENCE. No.
FOUNDATION DRAWING	12003–D–ST–DWG–312–WHS–003
STRUCTURE DRAWING	12003–D–ST–DWG–312–WHS–004

NOTES


1. ALL DIMENSIONS ARE IN CENTIMETER & ALL ELEVATIONS ARE IN METER.
2. ALL DIMENSIONS AND ELEVATIONS SHALL BE CHECKED BY THE CONTRACTOR PRIOR TO CONSTRUCTION.
3. F.F.L. IN ARCHITECTURAL DOCUMENT IS EQUALS TO 2518.50
4. CONTRACTOR SHALL COMPARE ALL ARCHITECTURAL, MECHANICAL, ELECTRICAL, PIPING AND STRUCTURAL DRAWINGS AND IN CASE OF ANY CONFLICTS OR DISCREPANCY, INFORM THE ENGINEER.
5. ALL OPENINGS FOR PIPING/CABLING SHALL BE CONSIDERED AS PER RELATED DRAWINGS BEFORE CONSTRUCTION.

LEGEND

AREA NAME :

- | | |
|----------------------|-------------------|
| ① WAREHOUSE | ⑥ LOUNGE ROOM |
| ② ENTRANCE | ⑦ SUPERVISOR ROOM |
| ③ PANTRY | ⑧ W.C |
| ④ MANAGER ROOM | ⑨ LOCKER & SHOWER |
| ⑤ PAYMENT ORDER ROOM | ⑩ PRAYER ROOM |

KEY PLAN

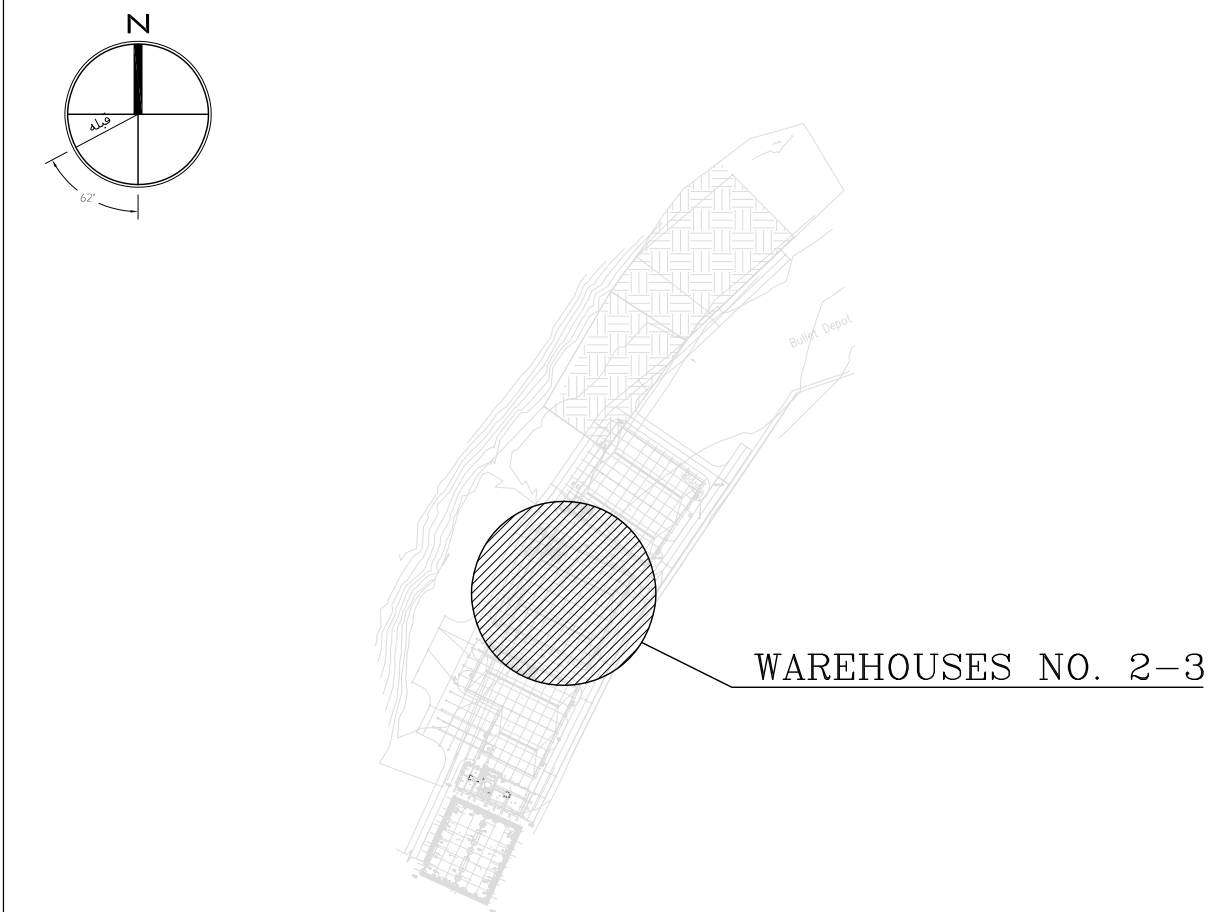


REV.	DATE	DESCRIPTION	PREPARED	CHECKED	APPROVED	AUTHORIZED
02	30.05.2023	ISSUED FOR CONSTRUCTION	M.MA&M.KH	M.AHMADI	H.NOROUZI	–
01	23.05.2023	ISSUED FOR APPROVAL	M.MA&M.KH	M.AHMADI	H.NOROUZI	–
00	09.02.2023	ISSUED FOR REVIEW AND COMMENT	M.MA&M.KH	M.AHMADI	H.NOROUZI	–

Client:	NICICO NATIONAL IRANIAN COPPER INDUSTRIES Co.	MC:	Shargan Consultant Engineers
Consultant:	mobina Mobina Engineering Co.	Contractor:	NIPEC

Project:	Sarcheshmeh Copper Concentrator Expansion Plant (Phase.3)
Title:	ARCHITECTURAL DETAIL DESIGN FOR SARCHESHMEH WAREHOUSES NO. 2–3

Document Number:	DATE	SIZE	SCALE	SHEET NO.	REV.
12003–D–AR–DWG–312–WHS–002	30.05.2023	A1	AS SHOWN	17 OF 25	CLIENT VENDOR
					02 02

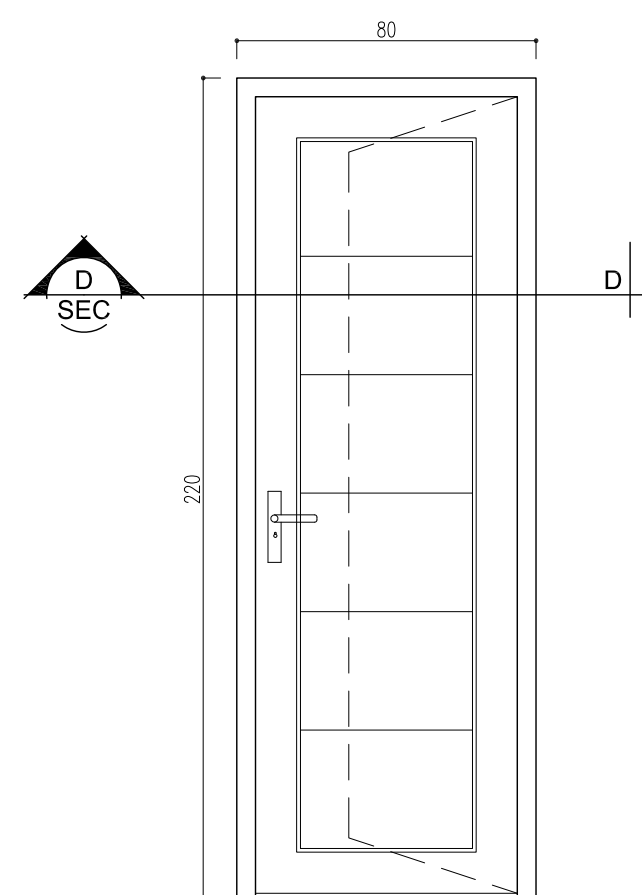

ABS DOOR – Type 1


NUMBER: 4

RIGHT HANDED: 1


LEFT HANDED: 3

Sc:1/20

ABS.D

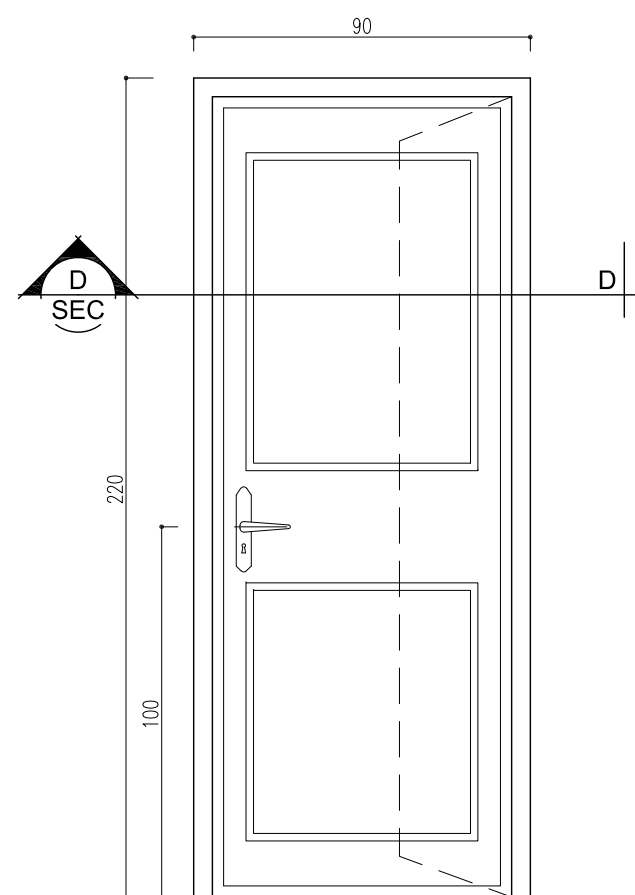


HDF DOOR – Type 1
 NUMBER: 6
 RIGHT HANDED: 2
 LEFT HANDED: 4

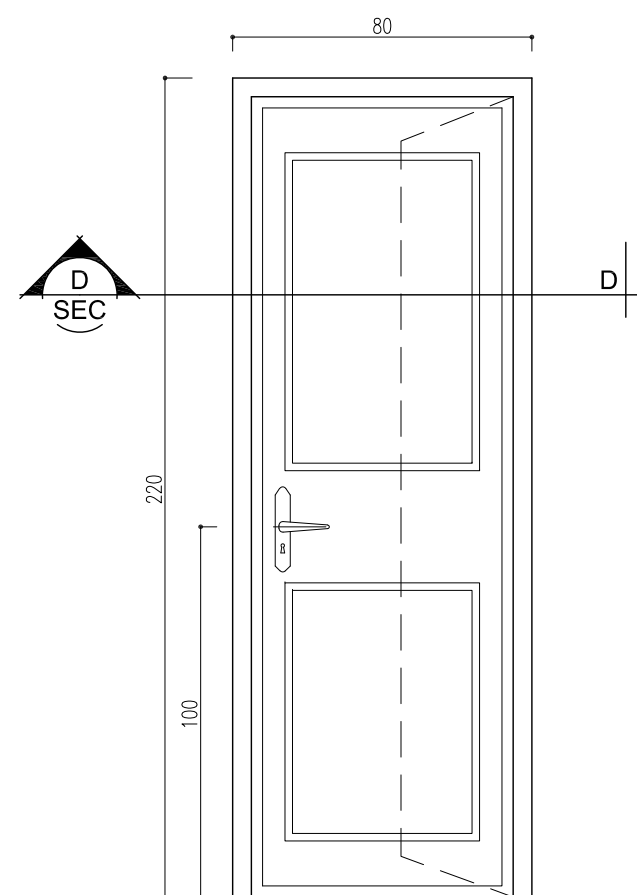

HDF DOOR – Type 2
 NUMBER: 2
 RIGHT HANDED: 2
 LEFT HANDED: –

Sc:1/20

HDF.D
T-2

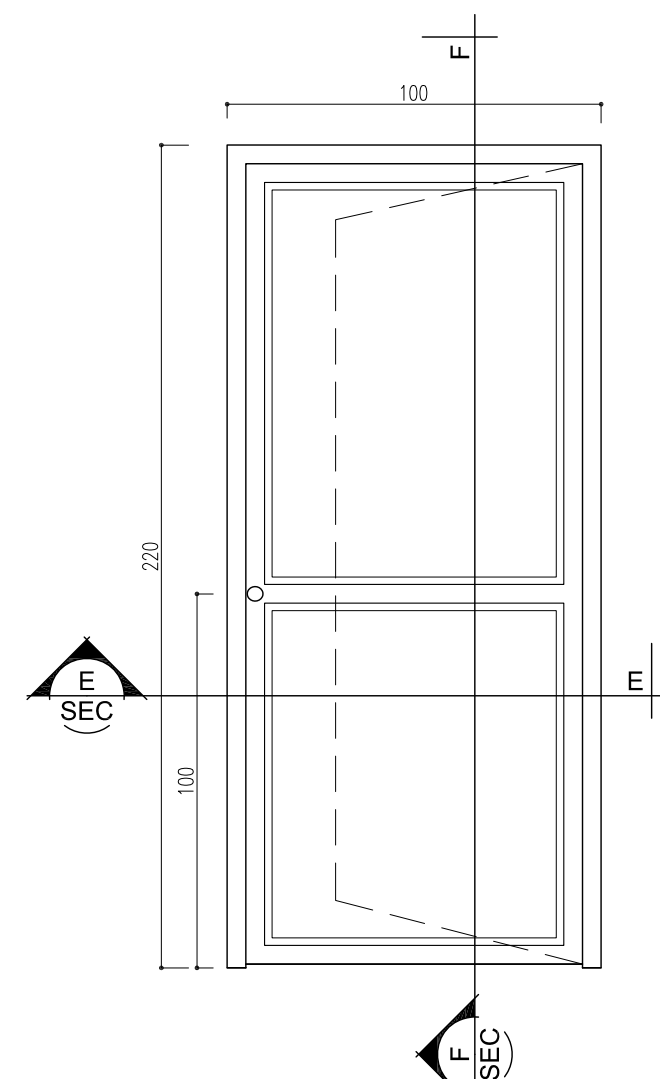

METAL DOOR - Type 1


NUMBER: 7

RIGHT HANDED: 3

LEFT HANDED: 4

Sc:1/20

M.D
-1

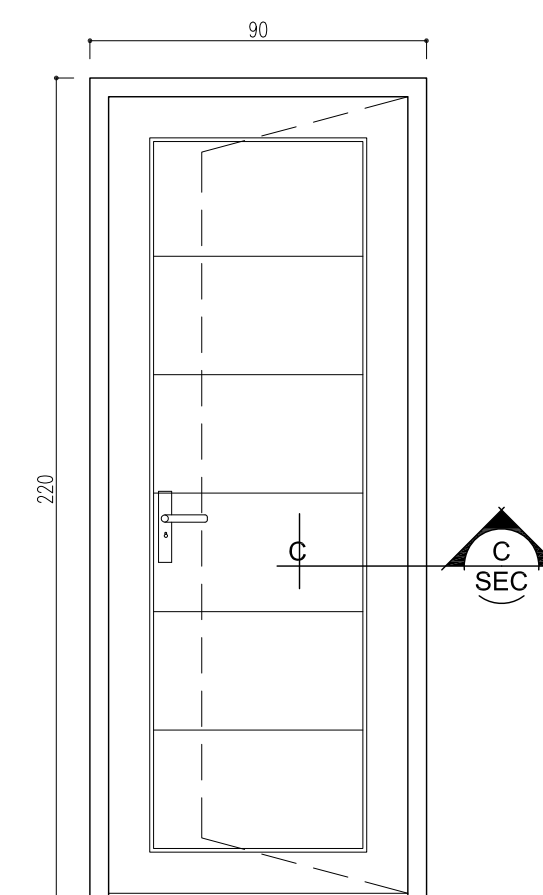


UPVC DOOR – Type 2


NUMBER: 1
RIGHT HANDED: 1
LEFT HANDED: –

Sc:1/20




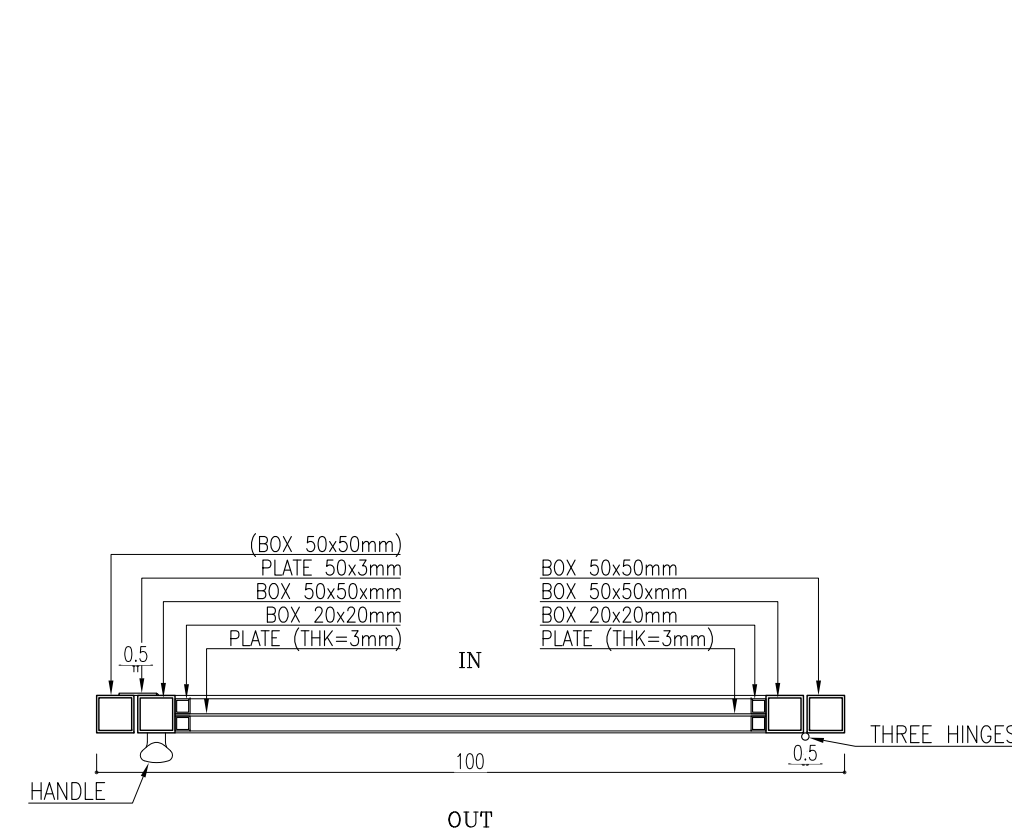

SECTION E-E

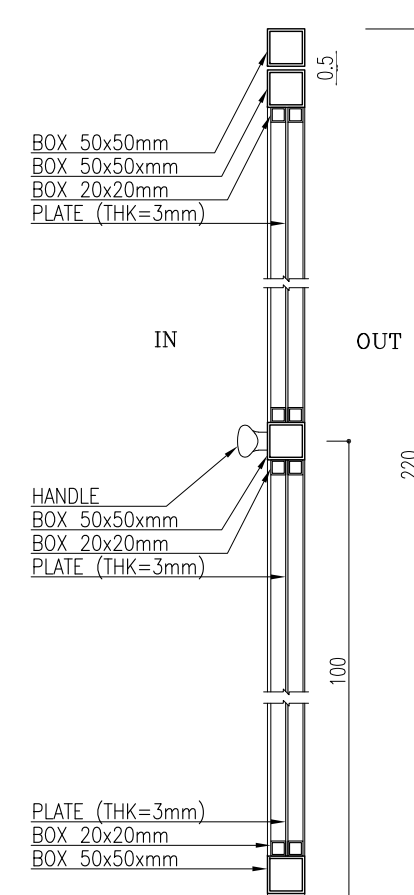


SECTION F-F

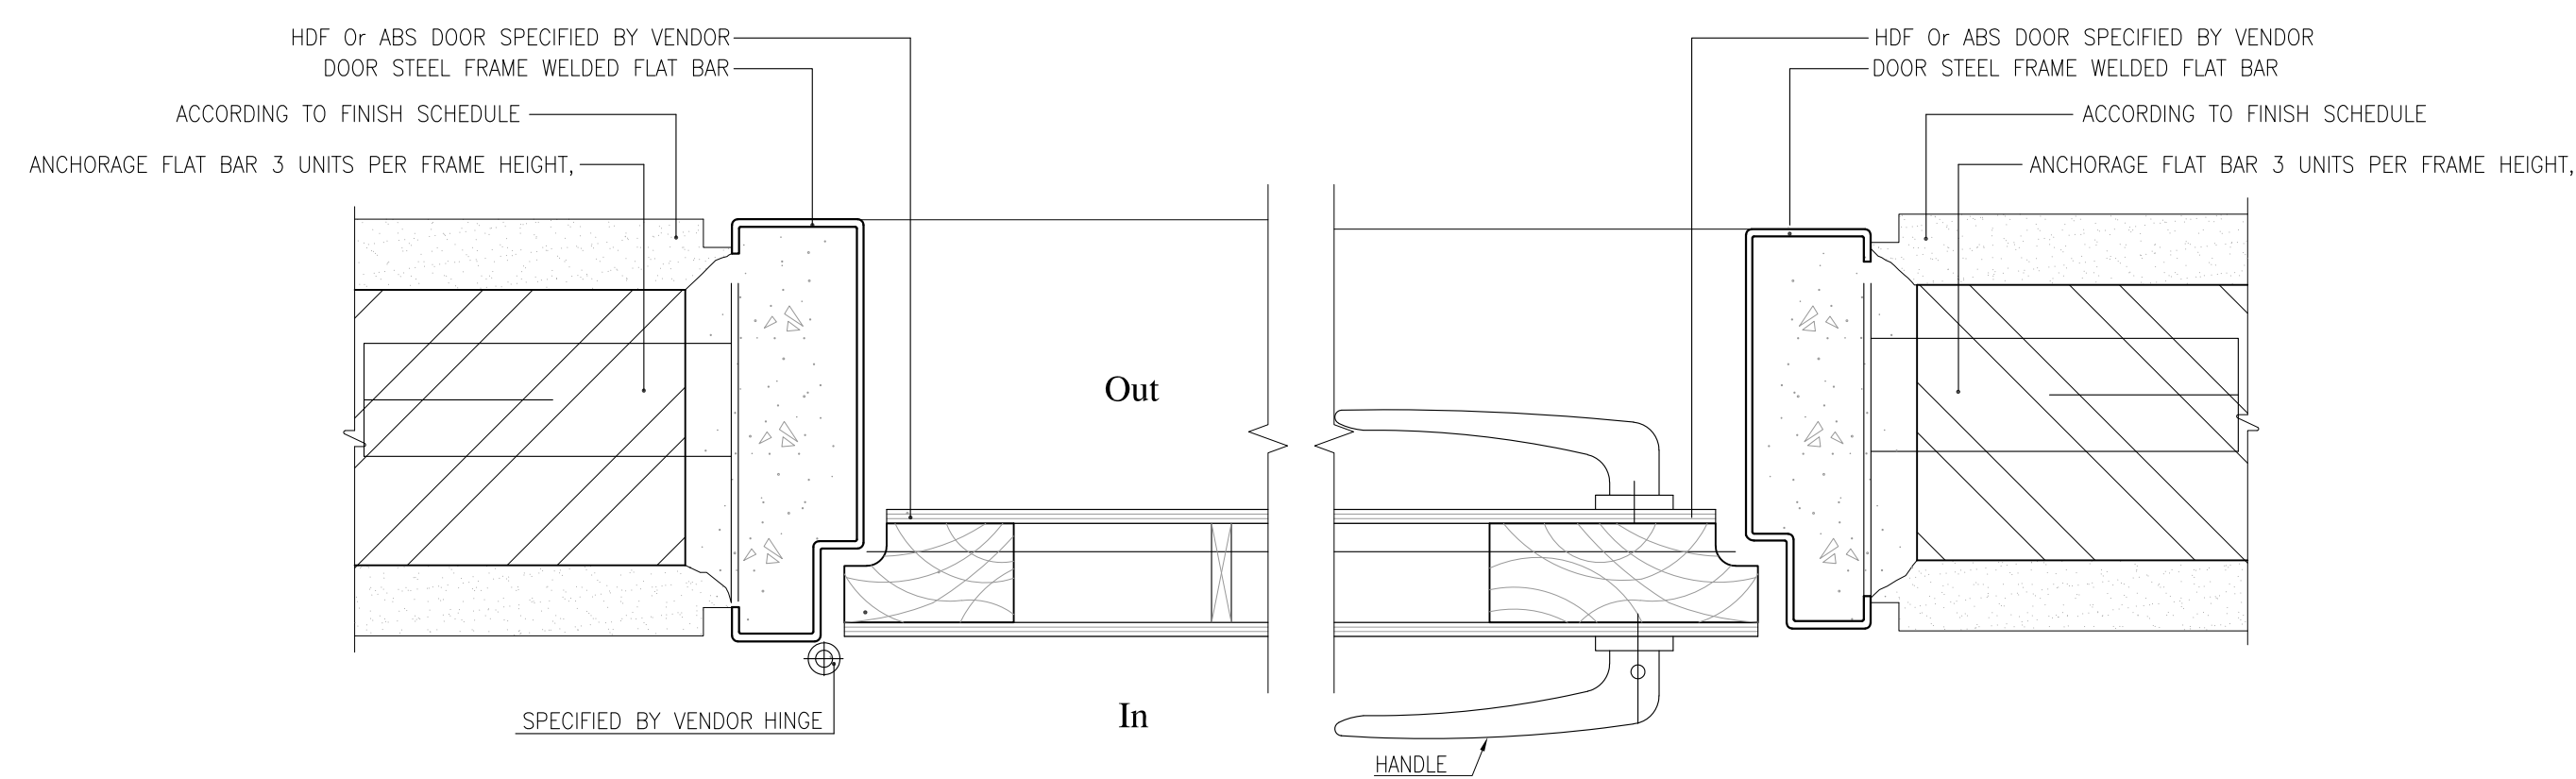


SECTION D-D


LINTEL SCHEDULE			
WIDTH a	SPAN b mm	PROFILE mm	
		a=200	a=100
VARIES— IT DEPENDS ON WALL THICKNESS AND IT'S FINISHING. REFER TO ARCHITECTURAL DWGS.	b≤1100	2L—60x60x6 	UNP 100 
	1100<b≤1500	2L—80x80x8 	UNP 100 
	1600<b≤2100	2L—100x100x10 	2UNP 80 
	2100<b≤3000	2UNP 160 	2UNP 100 
	3000<b≤3600	2UNP 180 	2UNP 100 

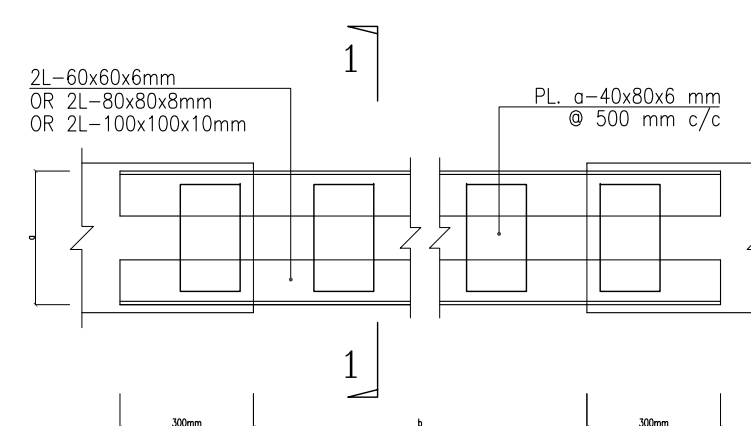


LINTEL PLAN -2L
Sc: N.T.S.

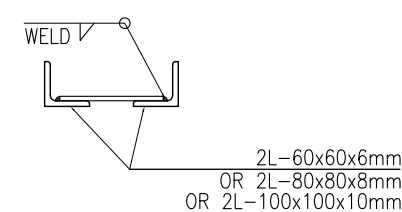

TYP. SECTION 1-1
Sc: 1:5

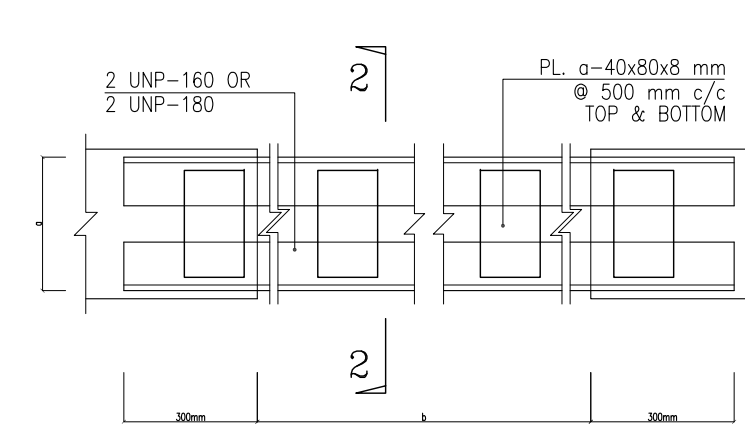

LINTEL PLAN -2 UNP
Sci: N.T.S.

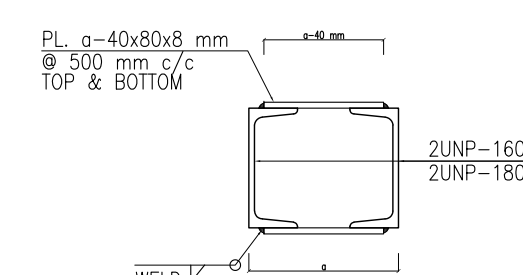

TYP. SECTION 2-2
Sc: 1:10

REFERENCE	
REFERENCE. TITLE	REFERENCE. No.
FOUNDATION DRAWING	12003-D-ST-DWG-312-WHS-003
STRUCTURE DRAWING	12003-D-ST-DWG-312-WHS-004

NOTES



1. ALL DIMENSIONS ARE IN CENTIMETER & ALL ELEVATIONS ARE IN METER.
2. ALL DIMENSIONS AND ELEVATIONS SHALL BE CHECKED BY THE CONTRACTOR PRIOR TO CONSTRUCTION.
3. F.F.L. IN ARCHITECTURAL DOCUMENT IS EQUALS TO 2518.50
4. CONTRACTOR SHALL COMPARE ALL ARCHITECTURAL, MECHANICAL, ELECTRICAL, PIPING AND STRUCTURAL DRAWINGS AND IN CASE OF ANY CONFLICTS OR DISCREPANCY, INFORM THE ENGINEER.
5. ALL OPENINGS FOR PIPING/CABLING SHALL BE CONSIDERED AS PER RELATED DRAWINGS BEFORE CONSTRUCTION.

LEGEND

AREA NAME :

- | | |
|----------------------|-------------------|
| ① WAREHOUSE | ⑥ LOUNGE ROOM |
| ② ENTRANCE | ⑦ SUPERVISOR ROOM |
| ③ PANTRY | ⑧ W.C |
| ④ MANAGER ROOM | ⑨ LOCKER & SHOWER |
| ⑤ PAYMENT ORDER ROOM | ⑩ PRAYER ROOM |

KEY PLAN

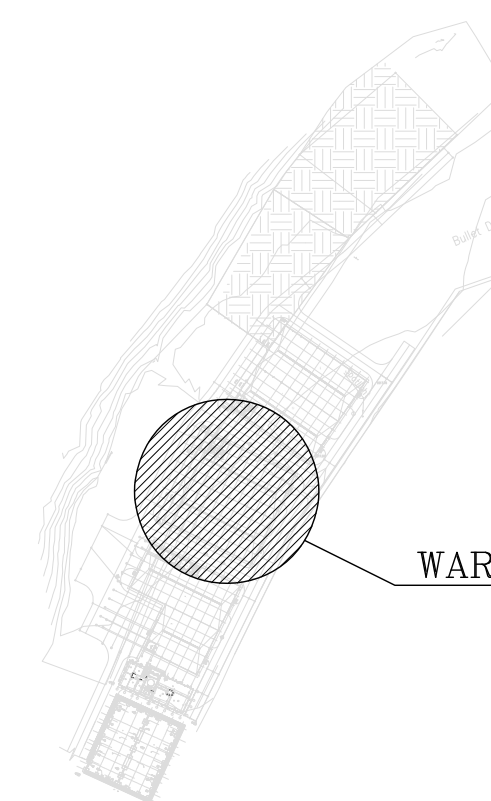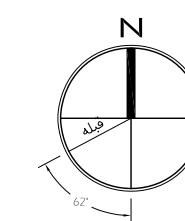

WAREHOUSES NO. 2-3

02	30.05.2023	ISSUED FOR CONSTRUCTION	M.M&M.KH	M.AHMADI	H.NOROUZI	-	
01	23.05.2023	ISSUED FOR APPROVAL	M.M&M.KH	M.AHMADI	H.NOROUZI	-	
00	09.02.2023	ISSUED FOR REVIEW AND COMMENT	M.M&M.KH	M.AHMADI	H.NOROUZI	-	
REV.	DATE	DESCRIPTION	PREPARED	CHECKED	APPROVED	AUTHORIZED	
Client:			MC:				



NICICO
NATIONAL IRANIAN
COPPER INDUSTRIES Co.



NIPEC  

Project:	Sarcheshmeh Copper Concentrator Expansion Plant (Phase.3)
----------	--


Title:	ARCHITECTURAL DETAIL DESIGN FOR SARCHESHMEH WAREHOUSES NO. 2-3
--------	---

Document Number: 12003-D-AR-DWG-312-WHS-002	DATE	SIZE	SCALE	SHEET NO.	REV.	
					CLIENT	VENDOR
	30.05.2023	A1	AS SHOWN	18 OF 25	02	02

[illegible]



N.T.S.C.	SUSPENDED CEILING PVC DECORATIVE THIS DETAIL SHOULD BE READ IN CONJUNCTION WITH SUSPENDED CEILING MANUFACTURER DETAILS.
----------	---

 

TYPICAL DETAILS OF PVC SUSPENDED CELING


N.T.S.C.	SUSPENDED CEILING PVC DECORATIVE THIS DETAIL SHOULD BE READ IN CONJUNCTION WITH SUSPENDED CEILING MANUFACTURER DETAILS.
----------	---

	A
	B
	C
	D
	E
ED	

1. ALL DIMENSIONS ARE IN CENTIMETER & ALL ELEVATIONS ARE IN METER.
2. ALL DIMENSIONS AND ELEVATIONS SHALL BE CHECKED BY THE CONTRACTOR PRIOR TO CONSTRUCTION.
3. F.F.L. IN ARCHITECTURAL DOCUMENT IS EQUALS TO 2518.50
4. CONTRACTOR SHALL COMPARE ALL ARCHITECTURAL, MECHANICAL, ELECTRICAL, PIPING AND STRUCTURAL DRAWINGS AND IN CASE OF ANY CONFLICTS OR DISCREPANCY, INFORM THE ENGINEER.
5. ALL OPENINGS FOR PIPING/CABLING SHALL BE CONSIDERED AS PER RELATED DRAWINGS BEFORE CONSTRUCTION.

AREA NAME :

- KEY PLAN

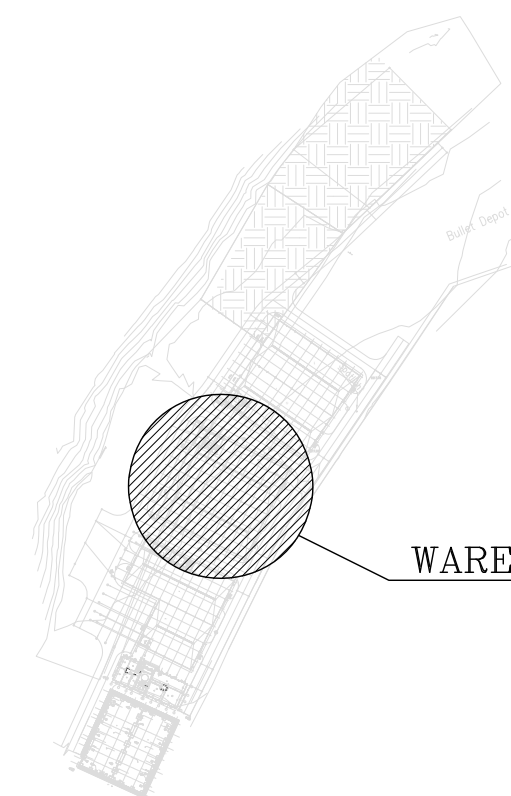


WAREHOUSES NO. 2-3

Client:	 NICICO NATIONAL IRANIAN COPPER INDUSTRIES Co.	MC:	 Shargan Consultant Engineers
Consultant:	 mobina Mobina Engineering Co.	Contractor:	NIPEC 

ARCHITECTURAL DETAIL DESIGN FOR
SARCHESHMEH WAREHOUSES NO. 2-3

Document Number: 12003-D-AR-DWG-312-WHS-002	DATE	SIZE	SCALE	SHEET NO.	REV.	
					CLIENT	VENDOR
	30.05.2023	A1	AS SHOWN	21 OF 25	02	02

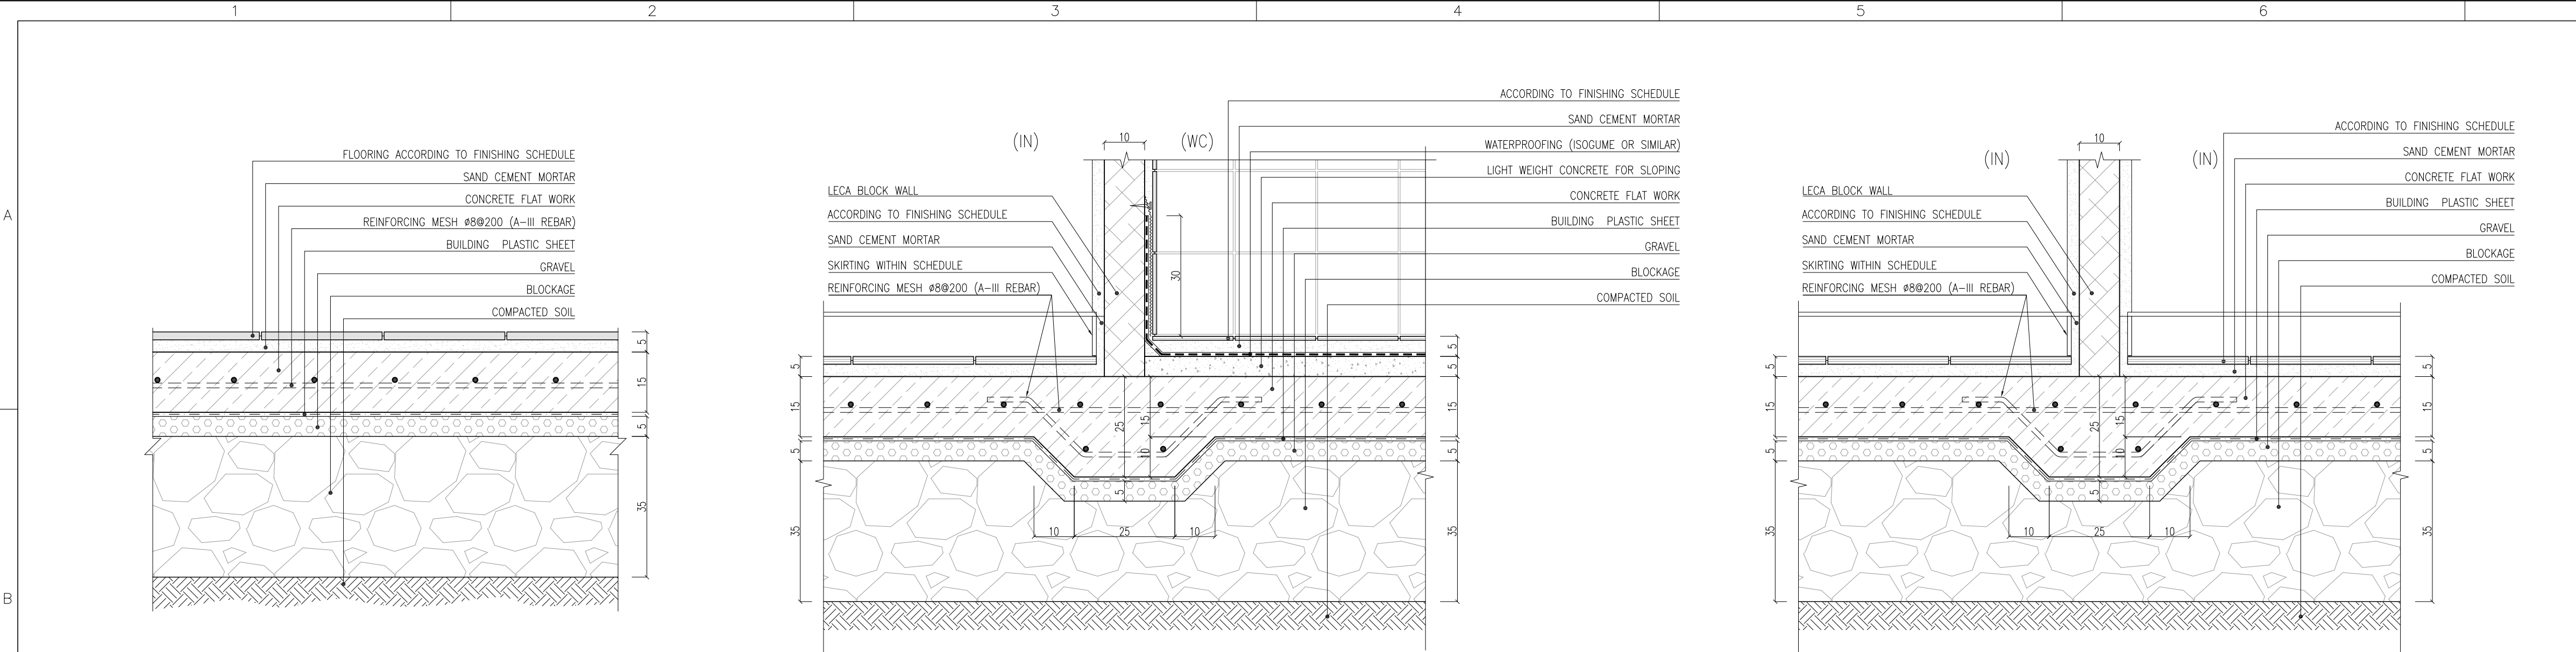

FLOORING DETAIL (GROUND FLOOR)


Sc:1/10

INTERNAL WALL DETAIL (GROUND FLOOR)

Sc:1/10

INTERNAL WALL DETAIL (GROUND FLOOR)

Sc:1/10

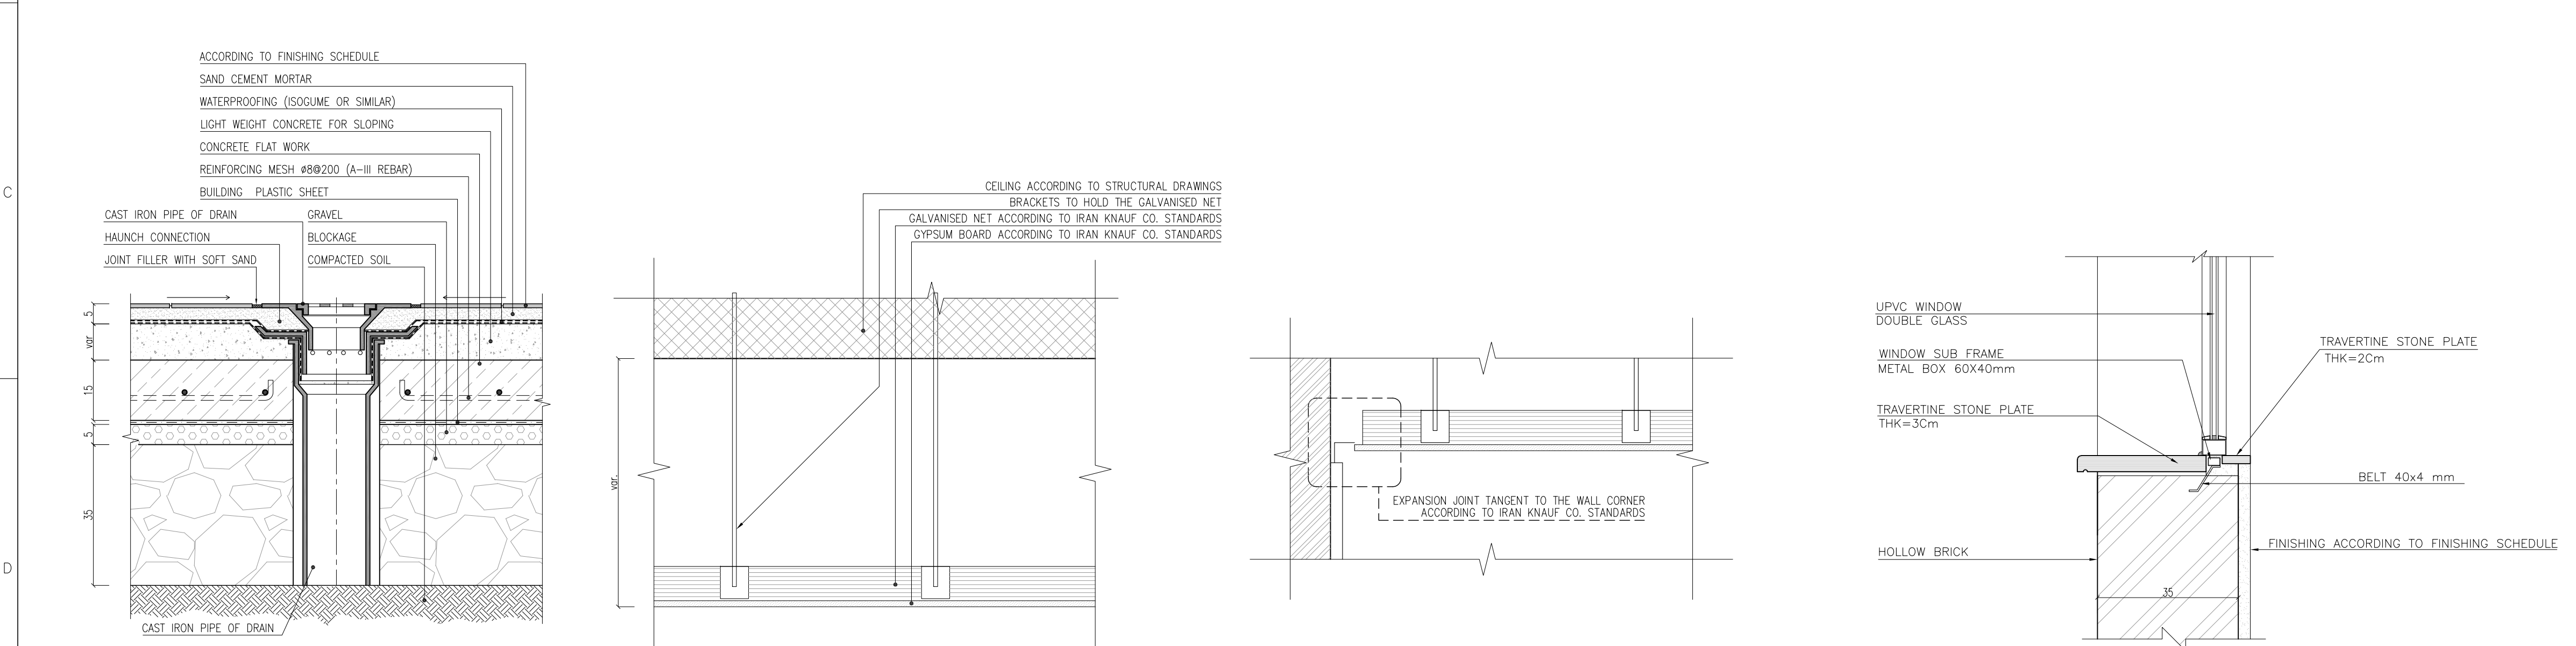

DRAIN DETAIL (GROUND FLOORS)

Sc:1/10

KNAUF SUSPENDED CEILING DETAILS


Sc:1/10

EXPANSION JOINT DETAIL OF SUSPENDED CEILING

Sc:1/10

WINDOW SILL TYPICAL DETAIL

Sc:1/10

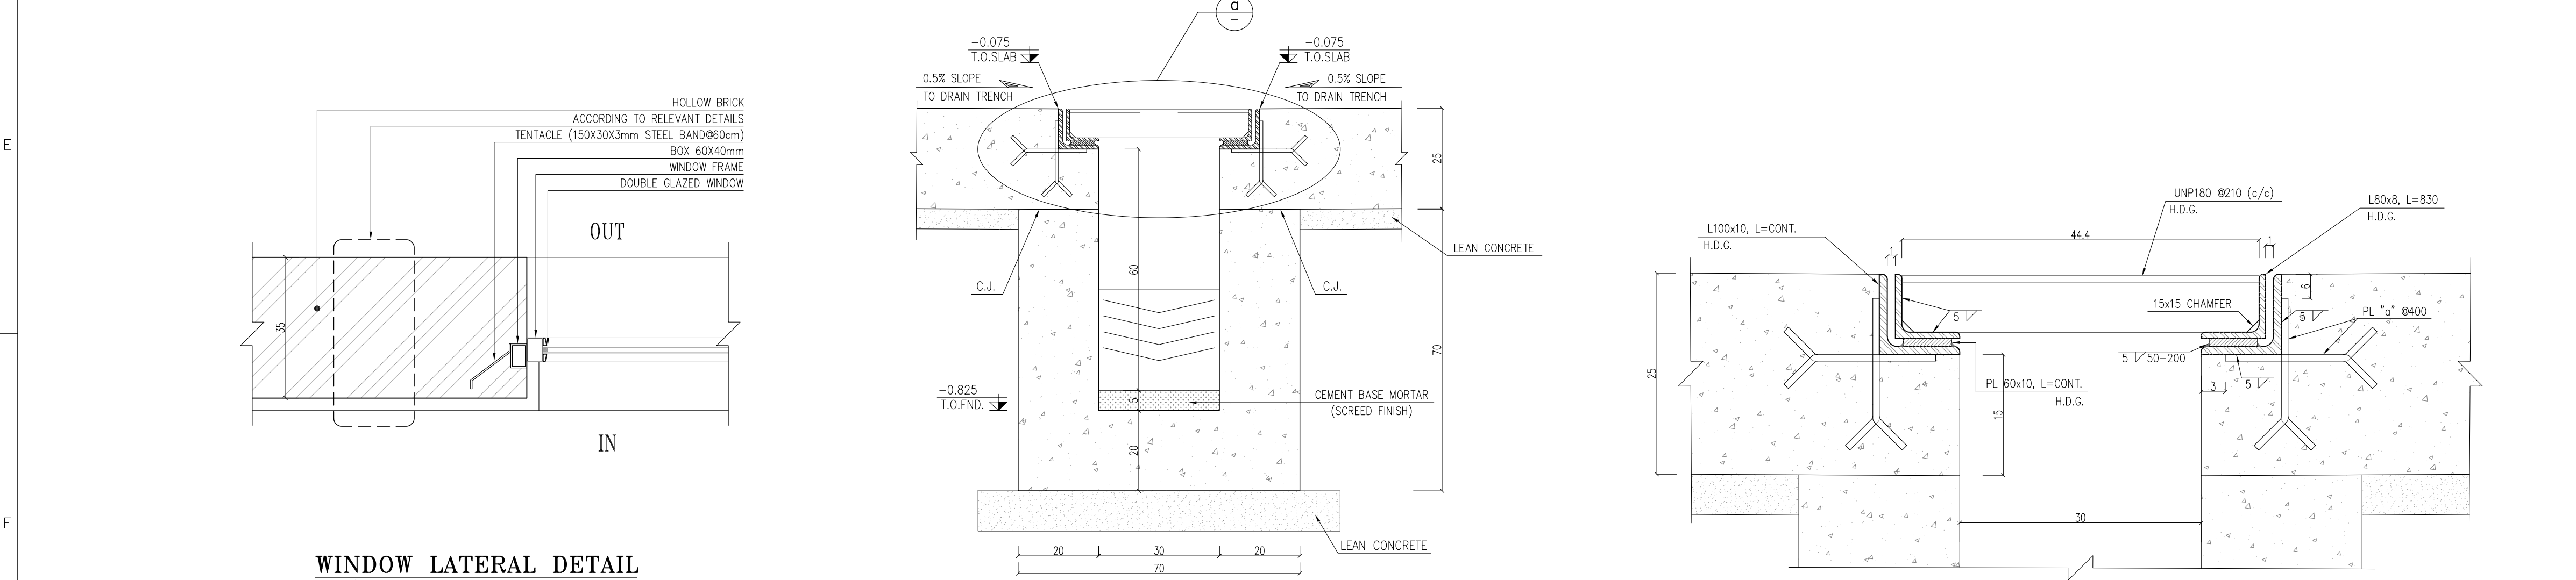

WINDOW LATERAL DETAIL


Sc:1/10


TYPICAL DETAILS FOR DRAIN TRENCH

Sc:1/10


DETAILS - a

Sc:1/5

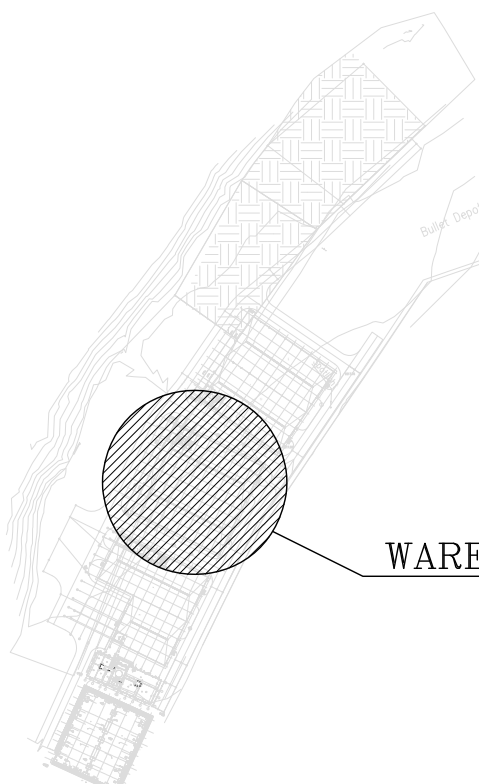
7		8																																																																																																																												
REFERENCE																																																																																																																														
REFERENCE. TITLE		REFERENCE. No.																																																																																																																												
FOUNDATION DRAWING		12003-D-ST-DWG-312-WHS-003																																																																																																																												
STRUCTURE DRAWING		12003-D-ST-DWG-312-WHS-004																																																																																																																												
NOTES																																																																																																																														
1. ALL DIMENSIONS ARE IN CENTIMETER & ALL ELEVATIONS ARE IN METER.																																																																																																																														
2. ALL DIMENSIONS AND ELEVATIONS SHALL BE CHECKED BY THE CONTRACTOR PRIOR TO CONSTRUCTION.																																																																																																																														
3. F.F.L. IN ARCHITECTURAL DOCUMENT IS EQUALS TO 2518.50																																																																																																																														
4. CONTRACTOR SHALL COMPARE ALL ARCHITECTURAL, MECHANICAL, ELECTRICAL, PIPING AND STRUCTURAL DRAWINGS AND IN CASE OF ANY CONFLICTS OR DISCREPANCY, INFORM THE ENGINEER.																																																																																																																														
5. ALL OPENINGS FOR PIPING/CABLING SHALL BE CONSIDERED AS PER RELATED DRAWINGS BEFORE CONSTRUCTION.																																																																																																																														
LEGEND																																																																																																																														
AREA NAME :																																																																																																																														
① WAREHOUSE		⑥ LOUNGE ROOM																																																																																																																												
② ENTRANCE		⑦ SUPERVISOR ROOM																																																																																																																												
③ PANTRY		⑧ W.C																																																																																																																												
④ MANAGER ROOM		⑨ LOCKER & SHOWER																																																																																																																												
⑤ PAYMENT ORDER ROOM		⑩ PRAYER ROOM																																																																																																																												
KEY PLAN																																																																																																																														
N 0° 90° 180° 270°  WAREHOUSES NO. 2-3 <tr><td></td><td></td><td></td><td></td></tr> <tr><td></td><td></td><td></td><td></td></tr> <tr><td>02</td><td>30.05.2023</td><td>ISSUED FOR CONSTRUCTION</td><td>M.MA&M.KH</td><td>M.AHMADI</td><td>H.NOROUZI</td><td>-</td></tr> <tr><td>01</td><td>23.05.2023</td><td>ISSUED FOR APPROVAL</td><td>M.MA&M.KH</td><td>M.AHMADI</td><td>H.NOROUZI</td><td>-</td></tr> <tr><td>00</td><td>09.02.2023</td><td>ISSUED FOR REVIEW AND COMMENT</td><td>M.MA&M.KH</td><td>M.AHMADI</td><td>H.NOROUZI</td><td>-</td></tr> <tr><td>REV.</td><td>DATE</td><td>DESCRIPTION</td><td>PREPARED</td><td>CHECKED</td><td>APPROVED</td><td>AUTHORIZED</td></tr> <tr><td colspan="3">Client:</td><td colspan="4">MC:</td></tr> <tr><td colspan="3"> NICICO NATIONAL IRANIAN COPPER INDUSTRIES Co. </td><td colspan="4"> Shargan Consultant Engineers </td></tr> <tr><td colspan="3">Consultant:</td><td colspan="4">Contractor:</td></tr> <tr><td colspan="3"> mobina Mobina Engineering Co. </td><td colspan="4"></td></tr> <tr><td colspan="7">Project:</td></tr> <tr><td colspan="7">Sarcheshmeh Copper Concentrator Expansion Plant (Phase.3)</td></tr> <tr><td colspan="7">Title:</td></tr> <tr><td colspan="7">ARCHITECTURAL DETAIL DESIGN FOR SARCHESHMEH WAREHOUSES NO. 2-3</td></tr> <tr><td colspan="3">Document Number:</td><td>DATE</td><td>SIZE</td><td>SCALE</td><td>SHEET NO.</td><td>REV.</td></tr> <tr><td colspan="3">12003-D-AR-DWG-312-WHS-002</td><td>30.05.2023</td><td>A1</td><td>AS SHOWN</td><td>22 OF 25</td><td>CLIENT VENDOR</td></tr> <tr><td colspan="3"></td><td></td><td></td><td></td><td>02</td><td>02</td></tr> <tr><td colspan="3">7</td><td colspan="4">8</td></tr>												02	30.05.2023	ISSUED FOR CONSTRUCTION	M.MA&M.KH	M.AHMADI	H.NOROUZI	-	01	23.05.2023	ISSUED FOR APPROVAL	M.MA&M.KH	M.AHMADI	H.NOROUZI	-	00	09.02.2023	ISSUED FOR REVIEW AND COMMENT	M.MA&M.KH	M.AHMADI	H.NOROUZI	-	REV.	DATE	DESCRIPTION	PREPARED	CHECKED	APPROVED	AUTHORIZED	Client:			MC:				 NICICO NATIONAL IRANIAN COPPER INDUSTRIES Co.			 Shargan Consultant Engineers				Consultant:			Contractor:				 mobina Mobina Engineering Co.			  				Project:							Sarcheshmeh Copper Concentrator Expansion Plant (Phase.3)							Title:							ARCHITECTURAL DETAIL DESIGN FOR SARCHESHMEH WAREHOUSES NO. 2-3							Document Number:			DATE	SIZE	SCALE	SHEET NO.	REV.	12003-D-AR-DWG-312-WHS-002			30.05.2023	A1	AS SHOWN	22 OF 25	CLIENT VENDOR							02	02	7			8			
02	30.05.2023	ISSUED FOR CONSTRUCTION	M.MA&M.KH	M.AHMADI	H.NOROUZI	-																																																																																																																								
01	23.05.2023	ISSUED FOR APPROVAL	M.MA&M.KH	M.AHMADI	H.NOROUZI	-																																																																																																																								
00	09.02.2023	ISSUED FOR REVIEW AND COMMENT	M.MA&M.KH	M.AHMADI	H.NOROUZI	-																																																																																																																								
REV.	DATE	DESCRIPTION	PREPARED	CHECKED	APPROVED	AUTHORIZED																																																																																																																								
Client:			MC:																																																																																																																											
 NICICO NATIONAL IRANIAN COPPER INDUSTRIES Co.			 Shargan Consultant Engineers																																																																																																																											
Consultant:			Contractor:																																																																																																																											
 mobina Mobina Engineering Co.			  																																																																																																																											
Project:																																																																																																																														
Sarcheshmeh Copper Concentrator Expansion Plant (Phase.3)																																																																																																																														
Title:																																																																																																																														
ARCHITECTURAL DETAIL DESIGN FOR SARCHESHMEH WAREHOUSES NO. 2-3																																																																																																																														
Document Number:			DATE	SIZE	SCALE	SHEET NO.	REV.																																																																																																																							
12003-D-AR-DWG-312-WHS-002			30.05.2023	A1	AS SHOWN	22 OF 25	CLIENT VENDOR																																																																																																																							
						02	02																																																																																																																							
7			8																																																																																																																											

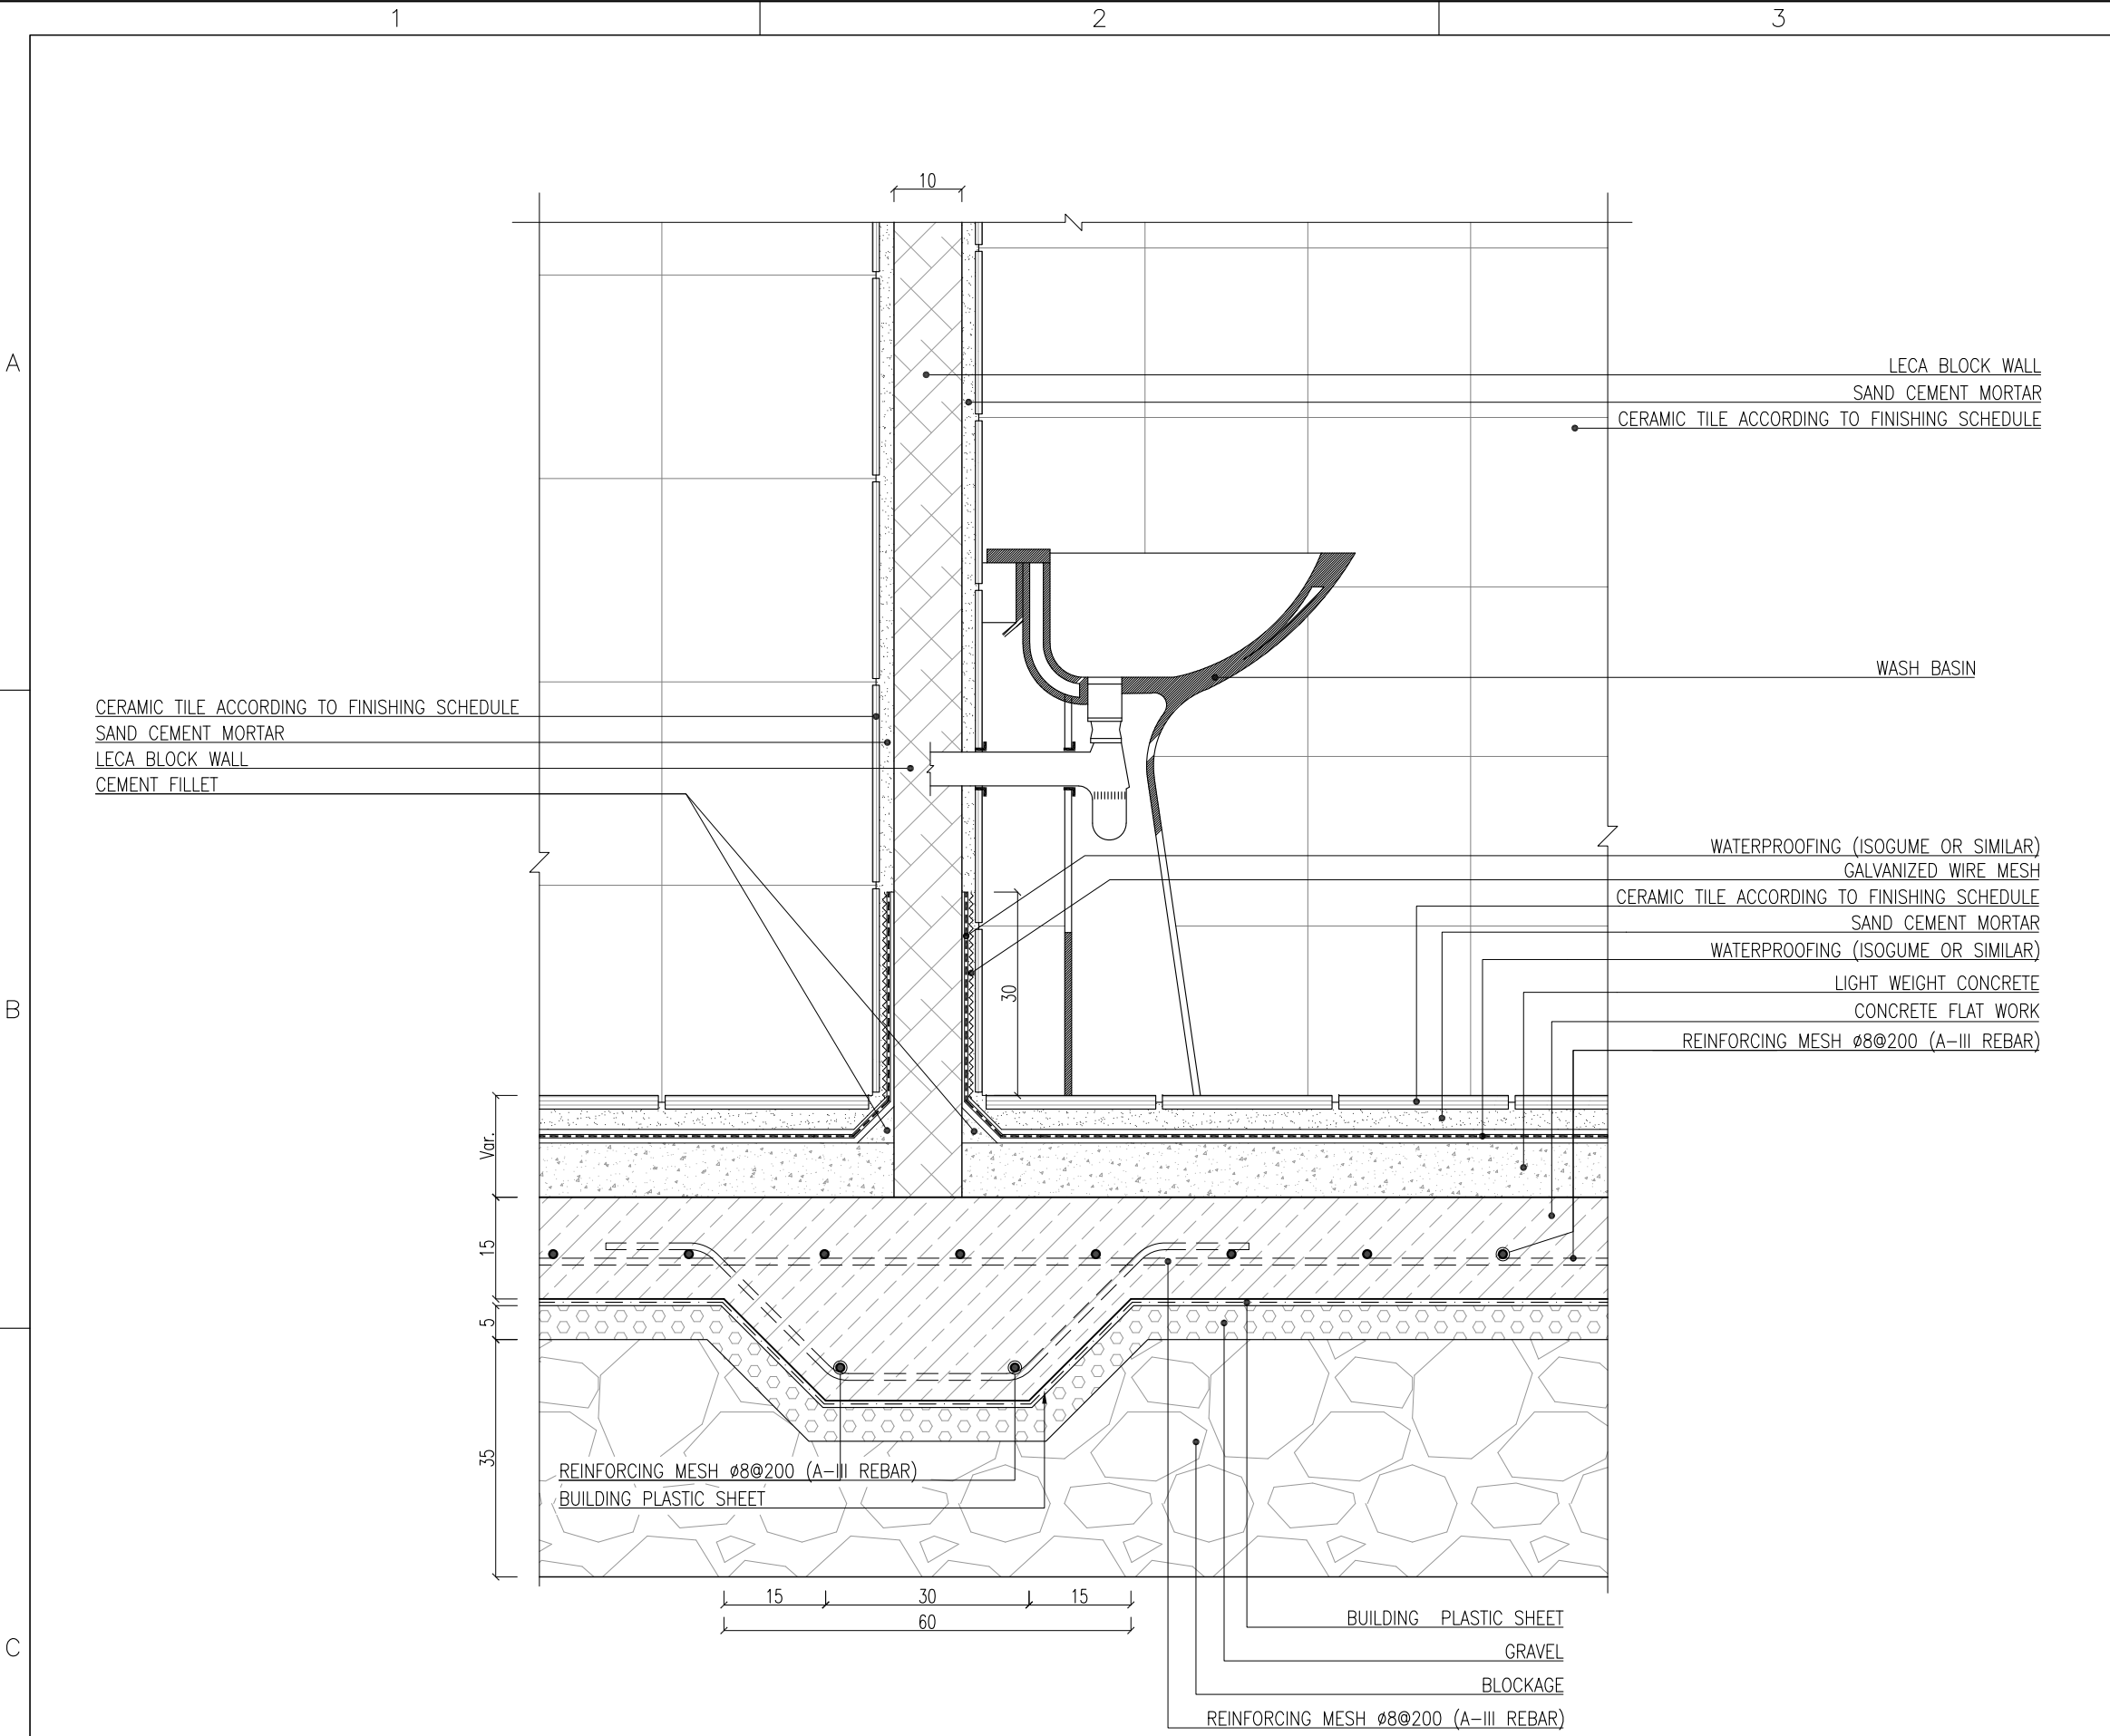


BASIN INSTALLATION DETAIL
Sc:1/10

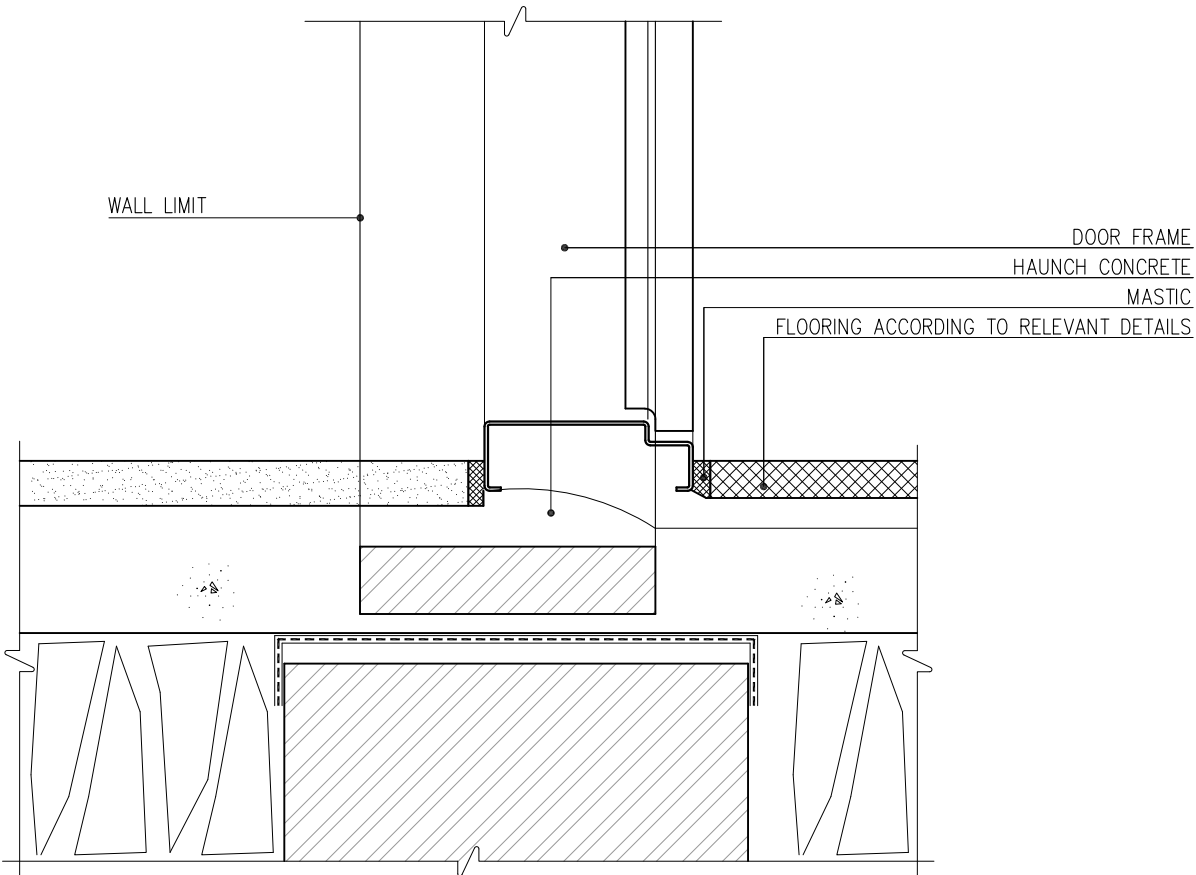

THRESHOLD DETAIL (GROUND FLOOR)
Sc: N.T.S.

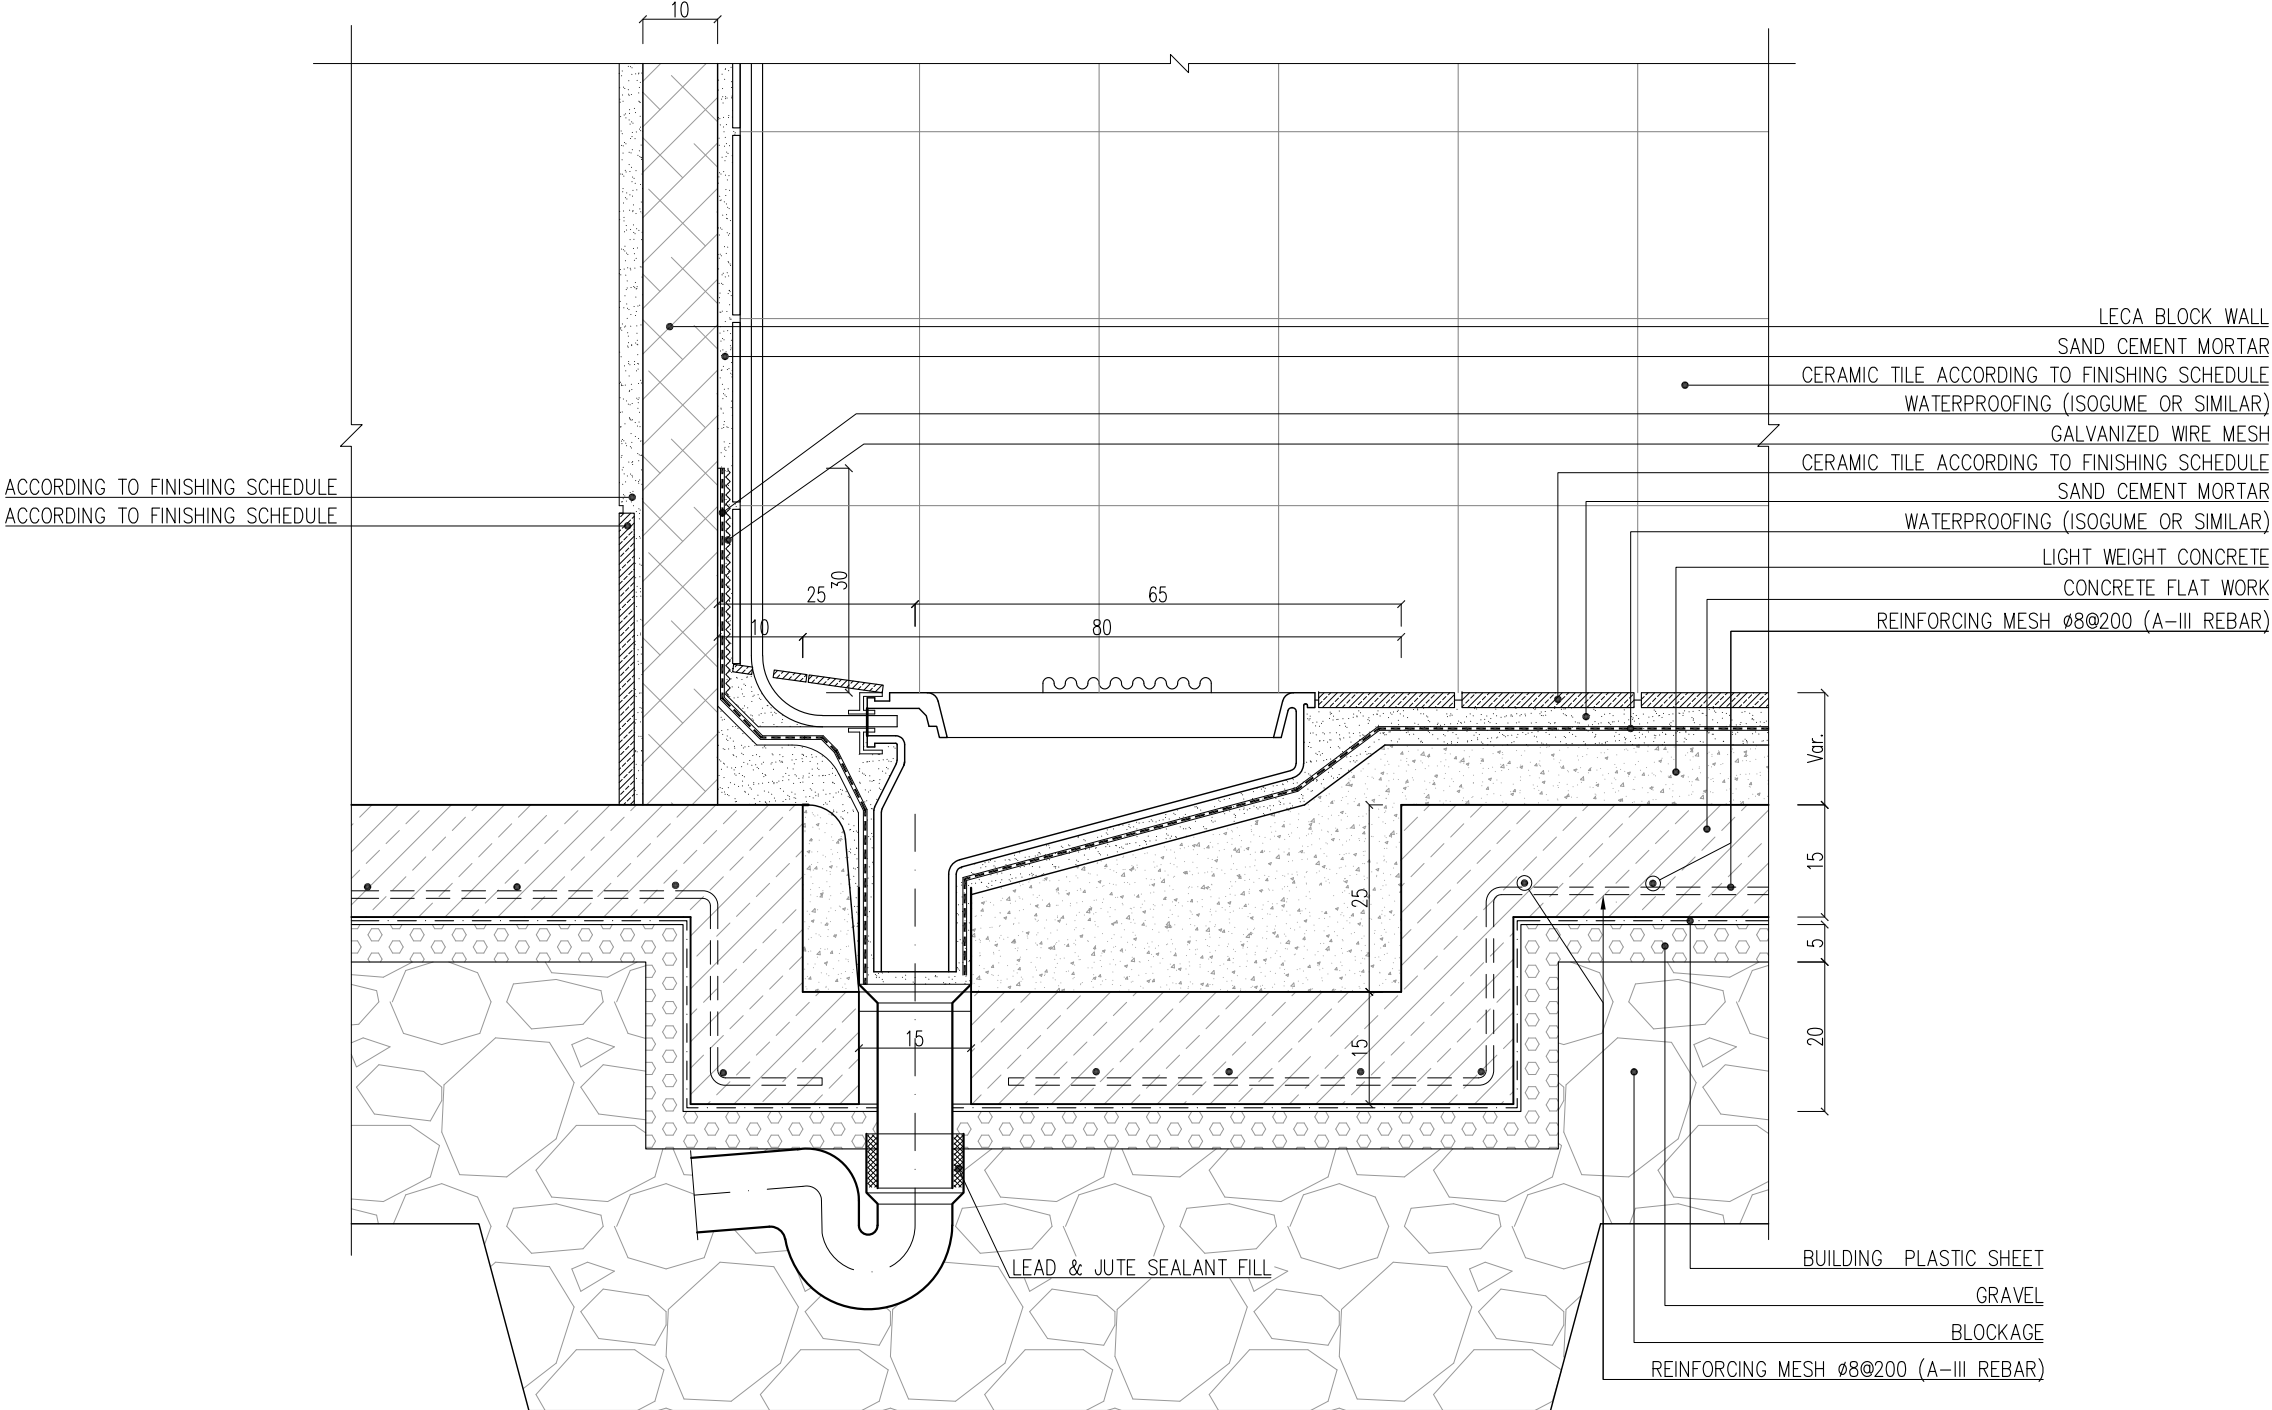

TOILET BOWL INSTALLATION DETAIL
Sc:1/10

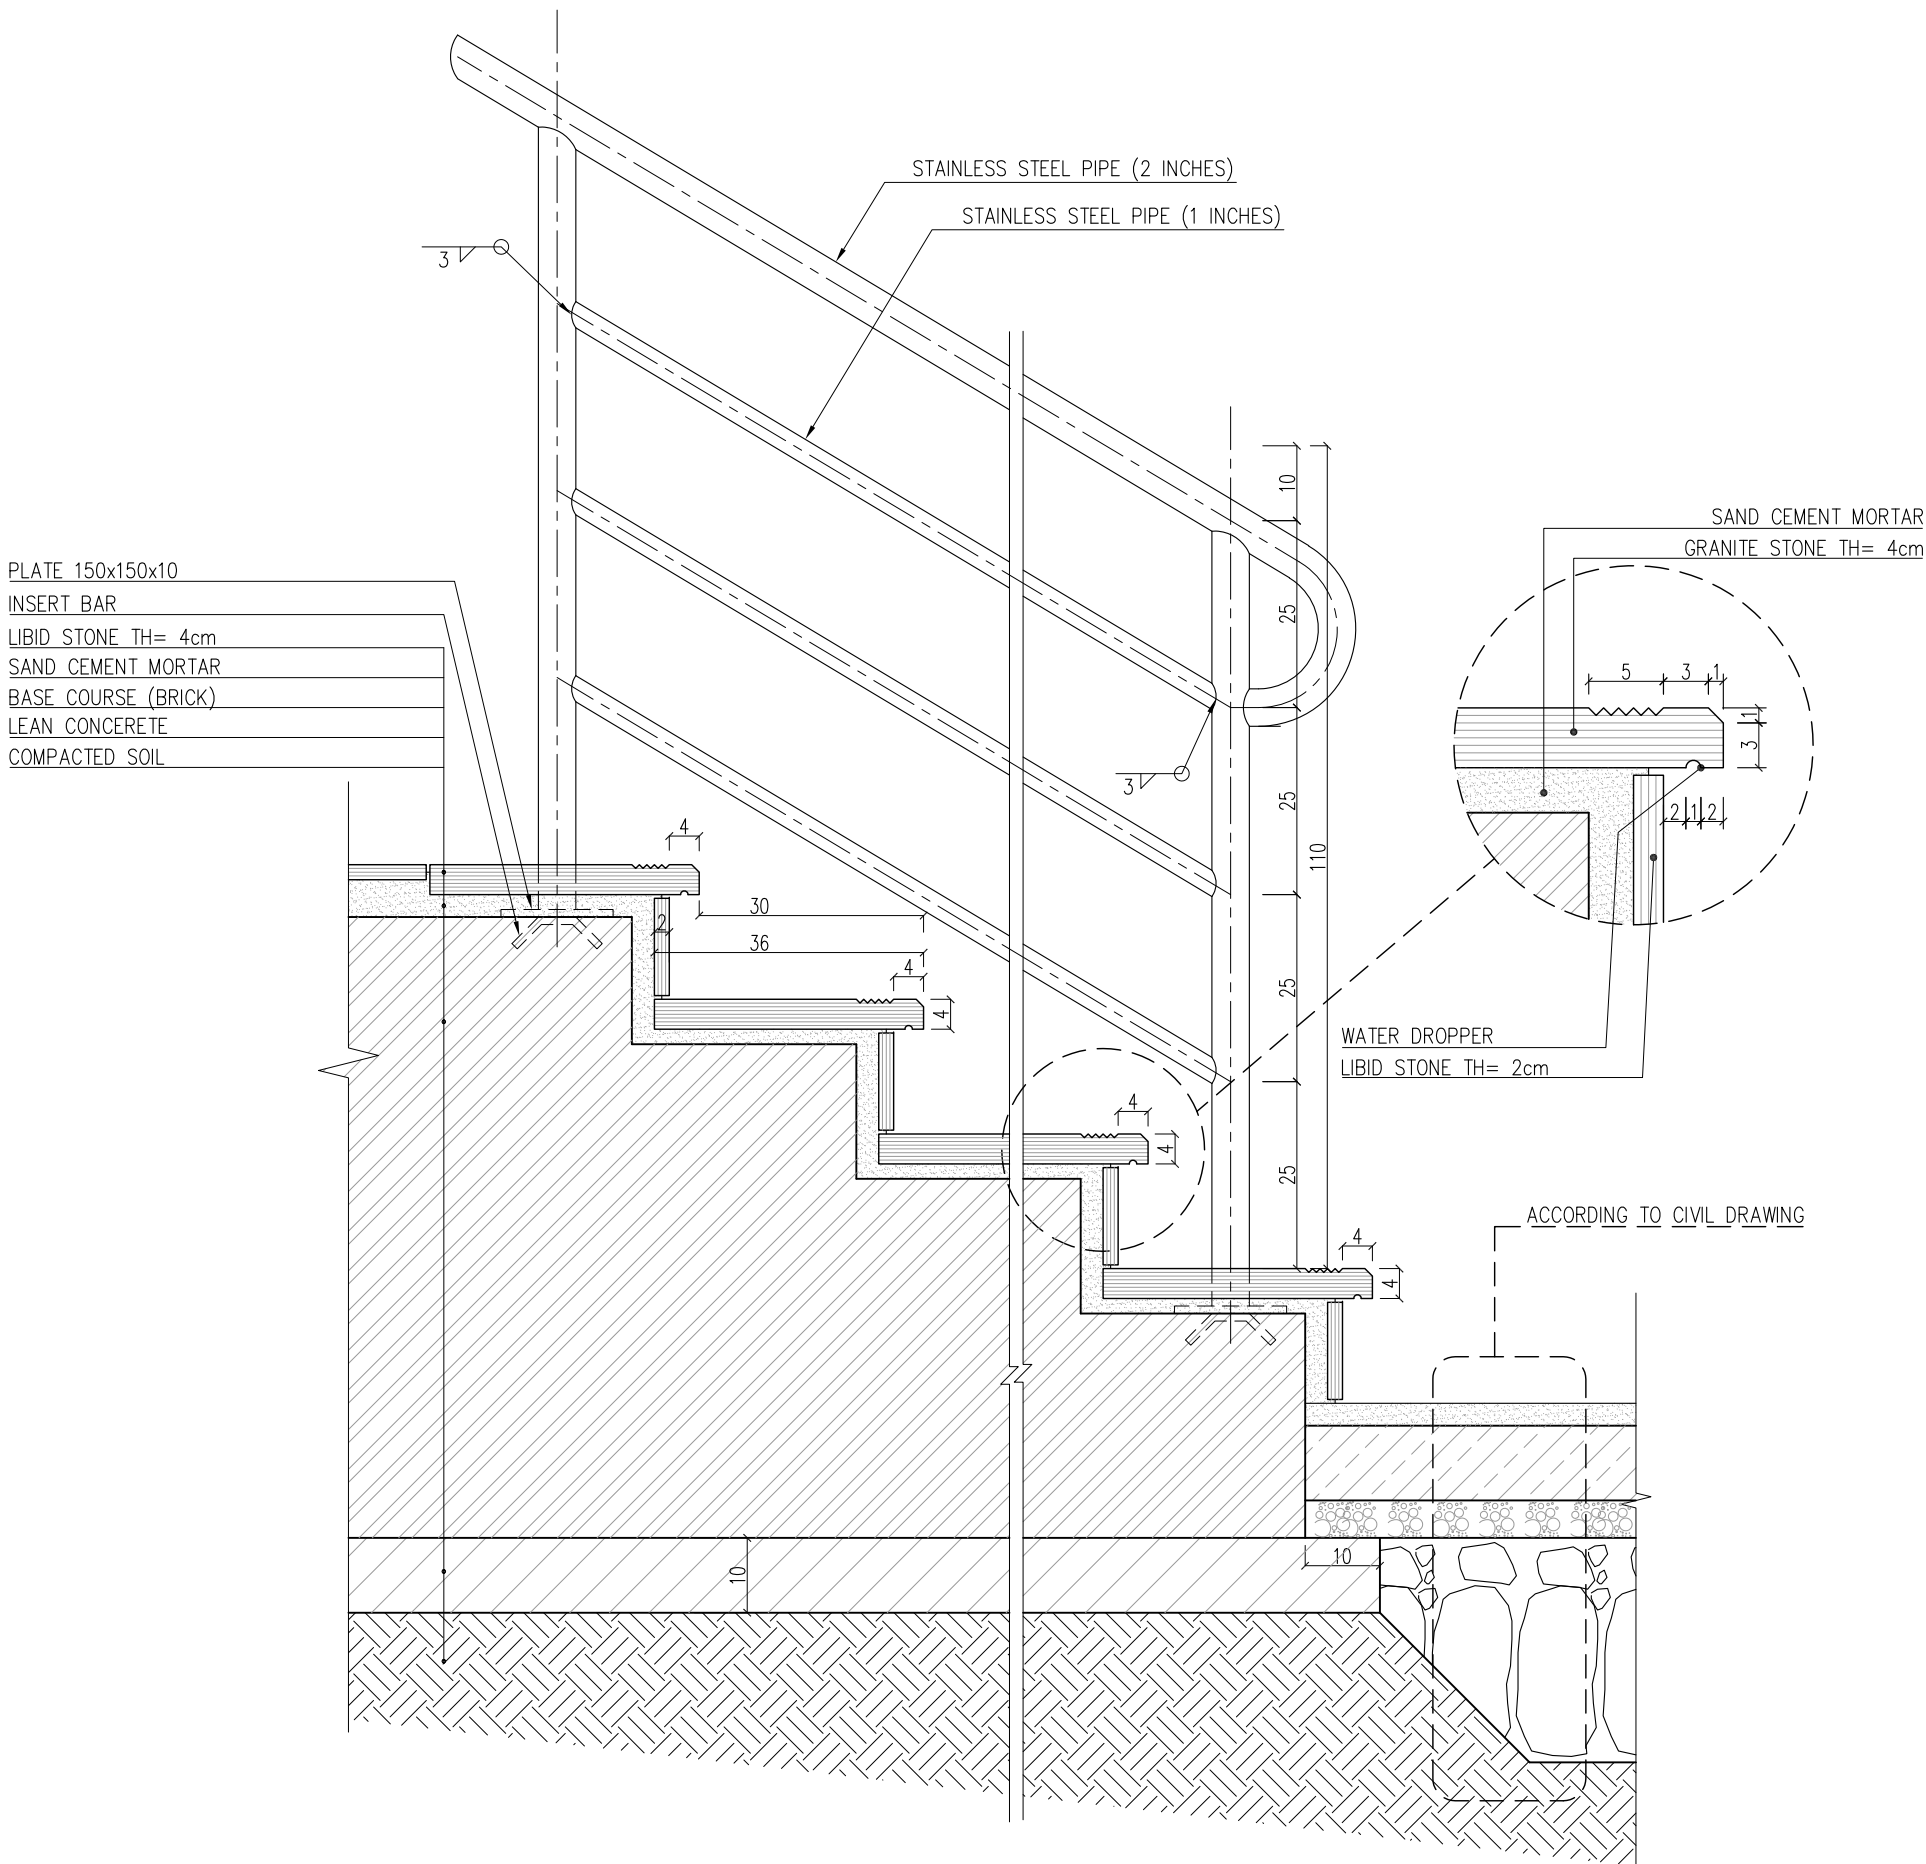


EXTERNAL STAIR DETAIL
Sc:1/10


REFERENCE	
REFERENCE. TITLE	REFERENCE. No.
FOUNDATION DRAWING	12003-D-ST-DWG-312-WHS-003
STRUCTURE DRAWING	12003-D-ST-DWG-312-WHS-004

NOTES	
1. ALL DIMENSIONS ARE IN CENTIMETER & ALL ELEVATIONS ARE IN METER.	
2. ALL DIMENSIONS AND ELEVATIONS SHALL BE CHECKED BY THE CONTRACTOR PRIOR TO CONSTRUCTION.	
3. F.F.L. IN ARCHITECTURAL DOCUMENT IS EQUALS TO 2518.50	
4. CONTRACTOR SHALL COMPARE ALL ARCHITECTURAL, MECHANICAL, ELECTRICAL, PIPING AND STRUCTURAL DRAWINGS AND IN CASE OF ANY CONFLICTS OR DISCREPANCY, INFORM THE ENGINEER.	
5. ALL OPENINGS FOR PIPING/CABLING SHALL BE CONSIDERED AS PER RELATED DRAWINGS BEFORE CONSTRUCTION.	

LEGEND	
AREA NAME :	
① WAREHOUSE	⑥ LOUNGE ROOM
② ENTRANCE	⑦ SUPERVISOR ROOM
③ PANTRY	⑧ W.C
④ MANAGER ROOM	⑨ LOCKER & SHOWER
⑤ PAYMENT ORDER ROOM	⑩ PRAYER ROOM

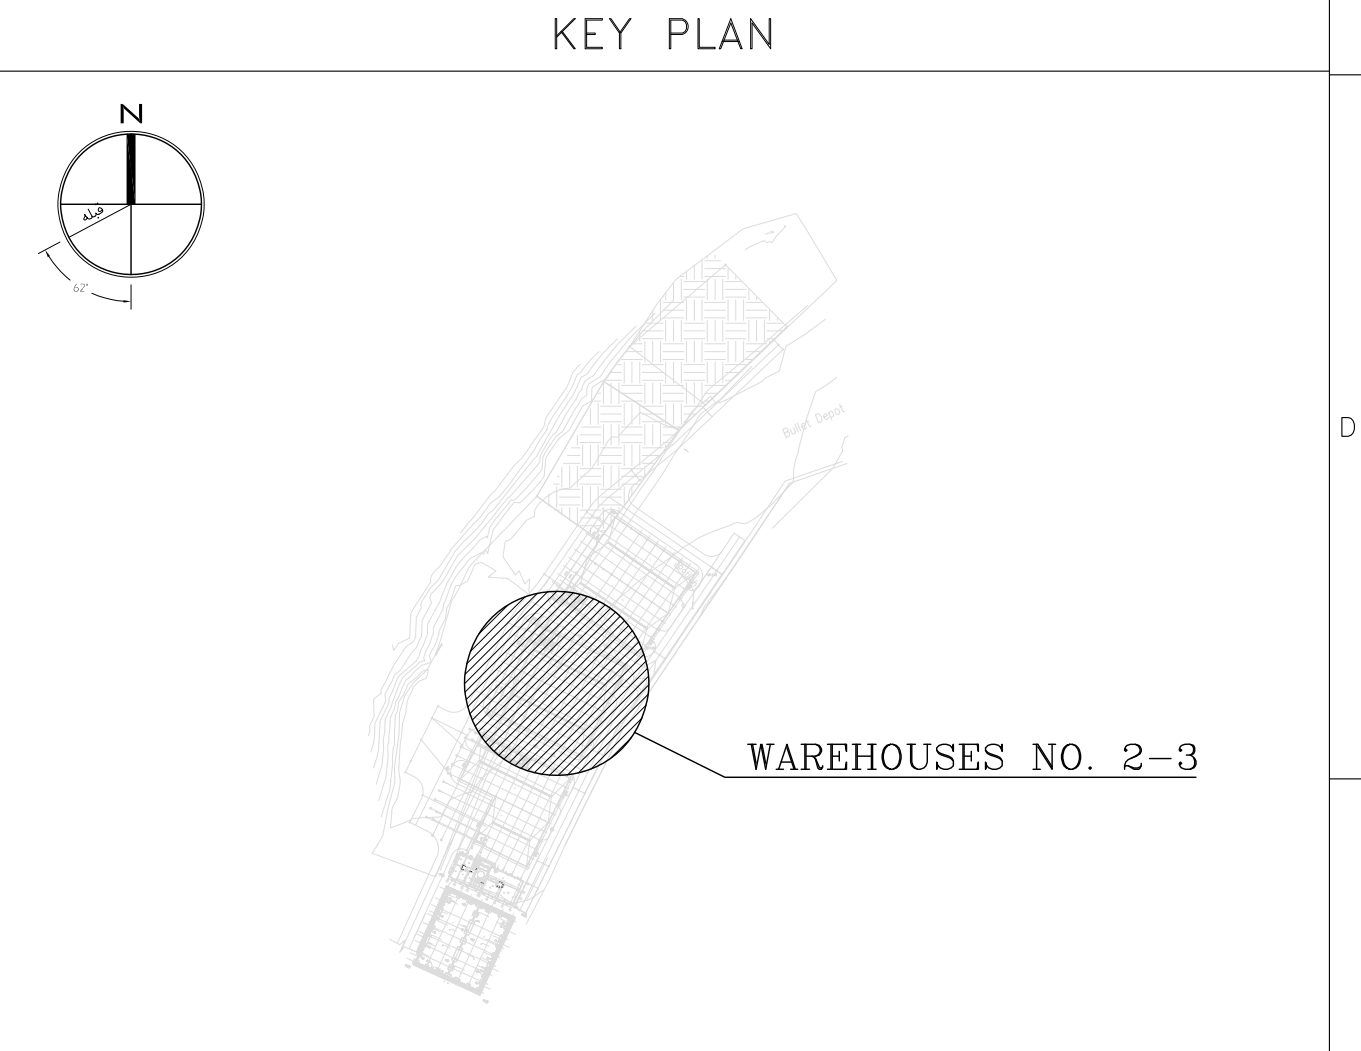


02	30.05.2023	ISSUED FOR CONSTRUCTION	M.MA&M.KH	M.AHMADI	H.NOROUZI	-	
01	23.05.2023	ISSUED FOR APPROVAL	M.MA&M.KH	M.AHMADI	H.NOROUZI	-	
00	09.02.2023	ISSUED FOR REVIEW AND COMMENT	M.MA&M.KH	M.AHMADI	H.NOROUZI	-	
REV.	DATE	DESCRIPTION	PREPARED	CHECKED	APPROVED	AUTHORIZED	
Client:			MC:				
 NICICO NATIONAL IRANIAN COPPER INDUSTRIES Co.							
Consultant:			Contractor:				
 Mobina Engineering Co.							
Project:							
Sarcheshmeh Copper Concentrator Expansion Plant (Phase.3)							
Title:							
ARCHITECTURAL DETAIL DESIGN FOR SARCHESHMEH WAREHOUSES NO. 2-3							
Document Number:			DATE	SIZE	SCALE	SHEET NO.	REV.
12003-D-AR-DWG-312-WHS-002			30.05.2023	A1	AS SHOWN	23 OF 25	02 02

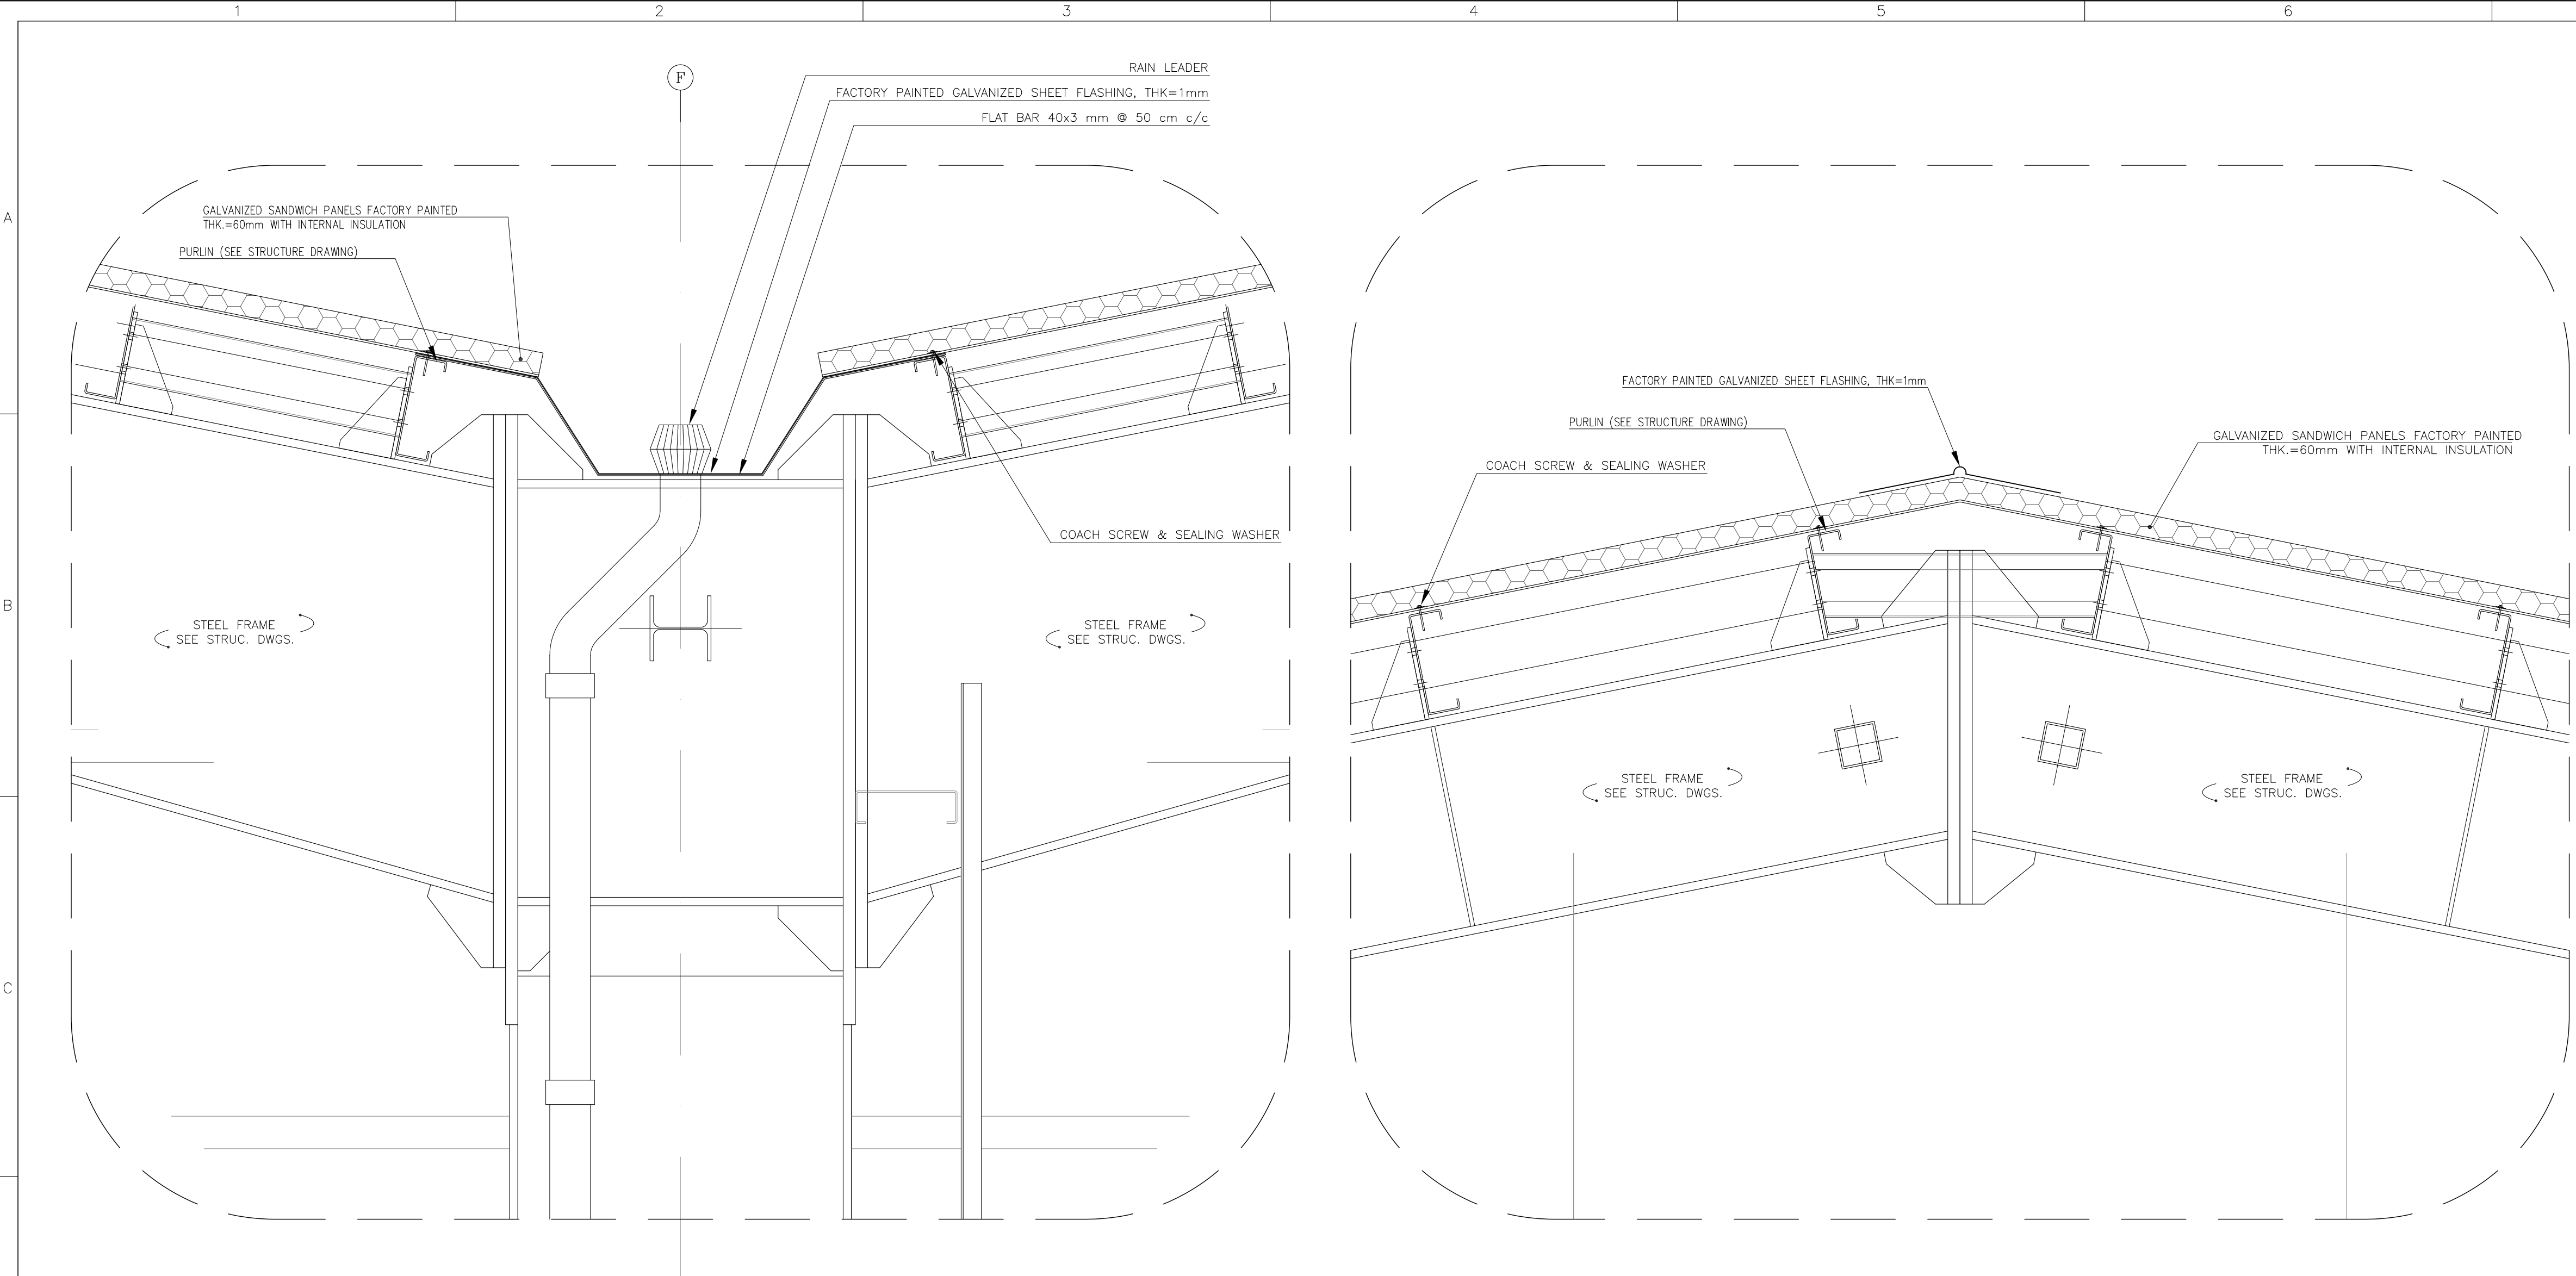


DETAIL-1
Sc:1/10


DETAIL-2
Sc:1/10

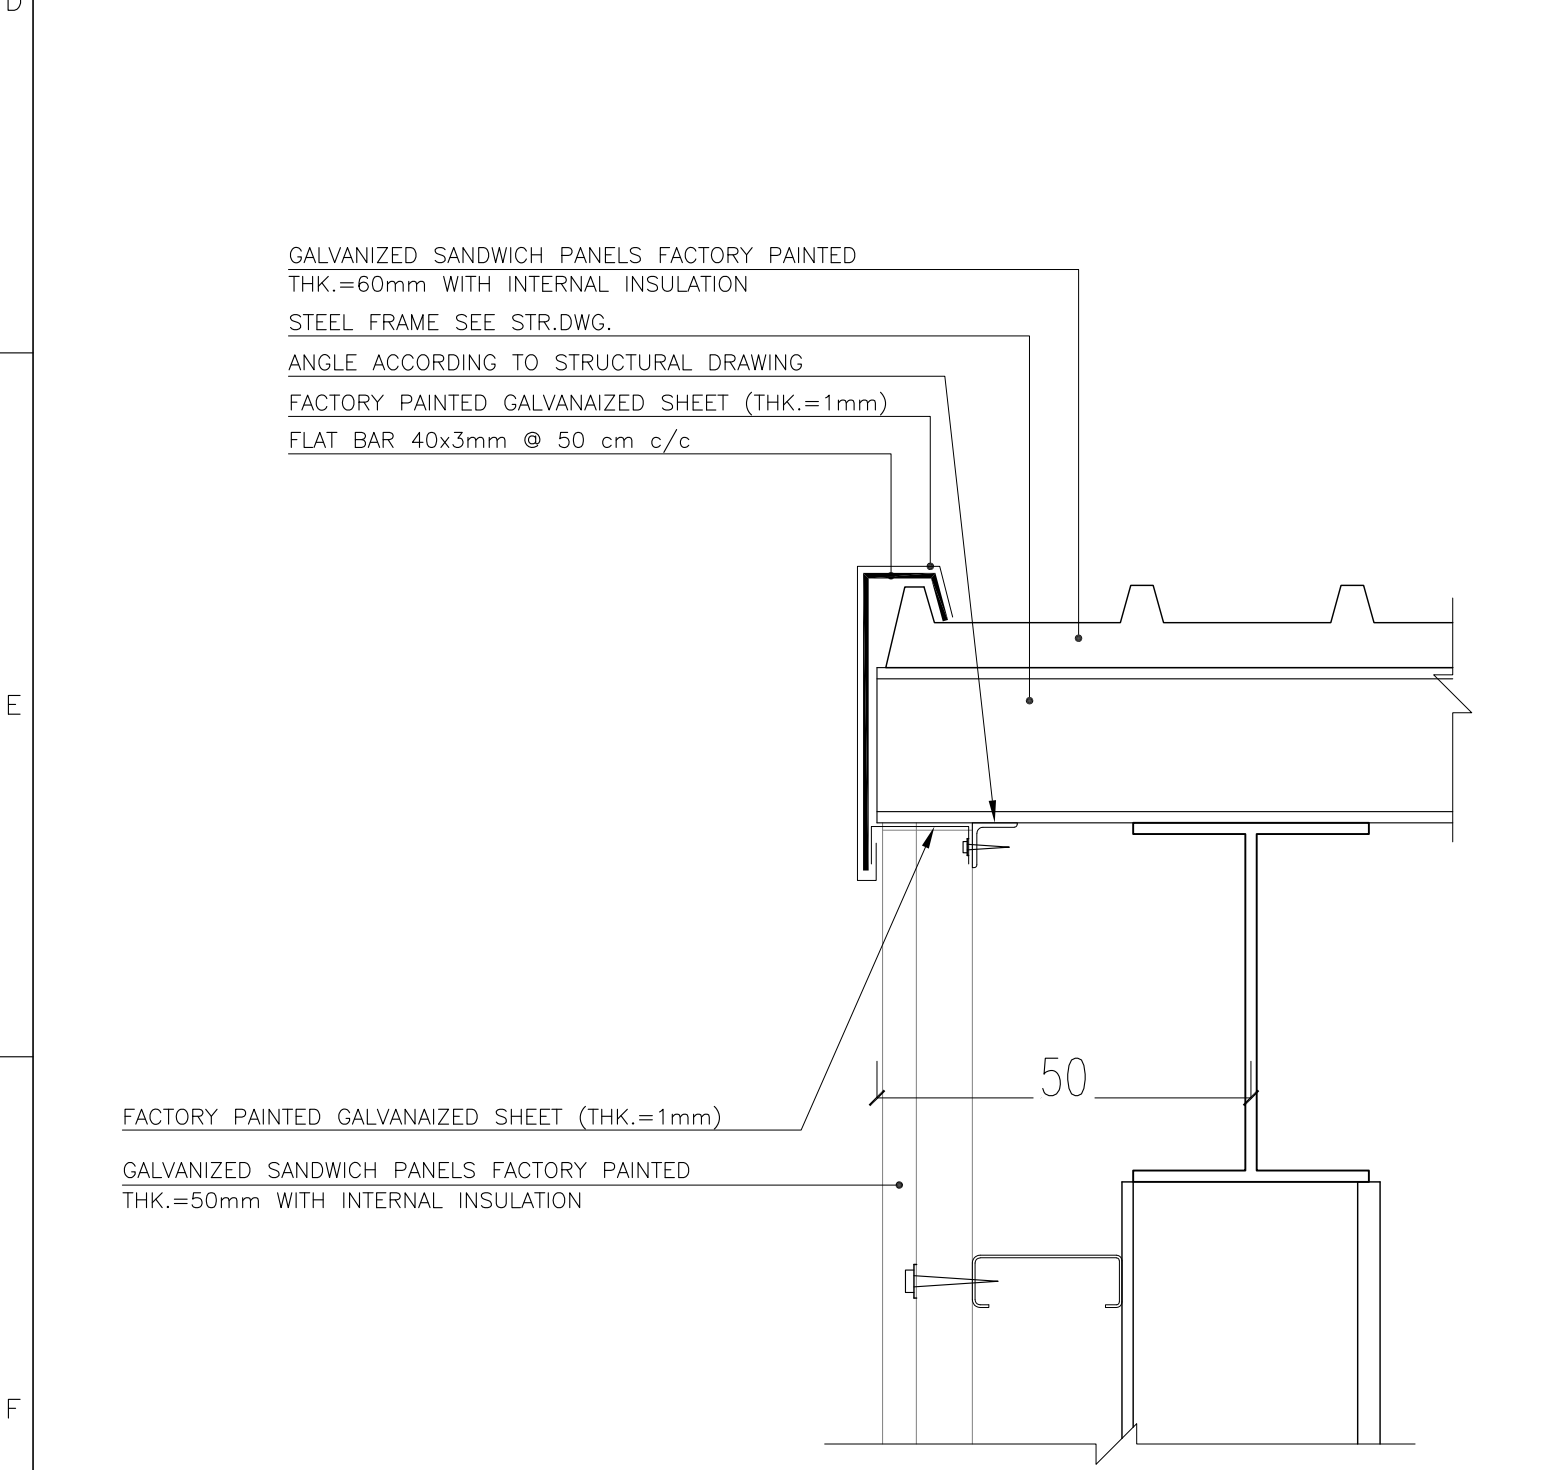

DETAIL-3
Sc:1/10

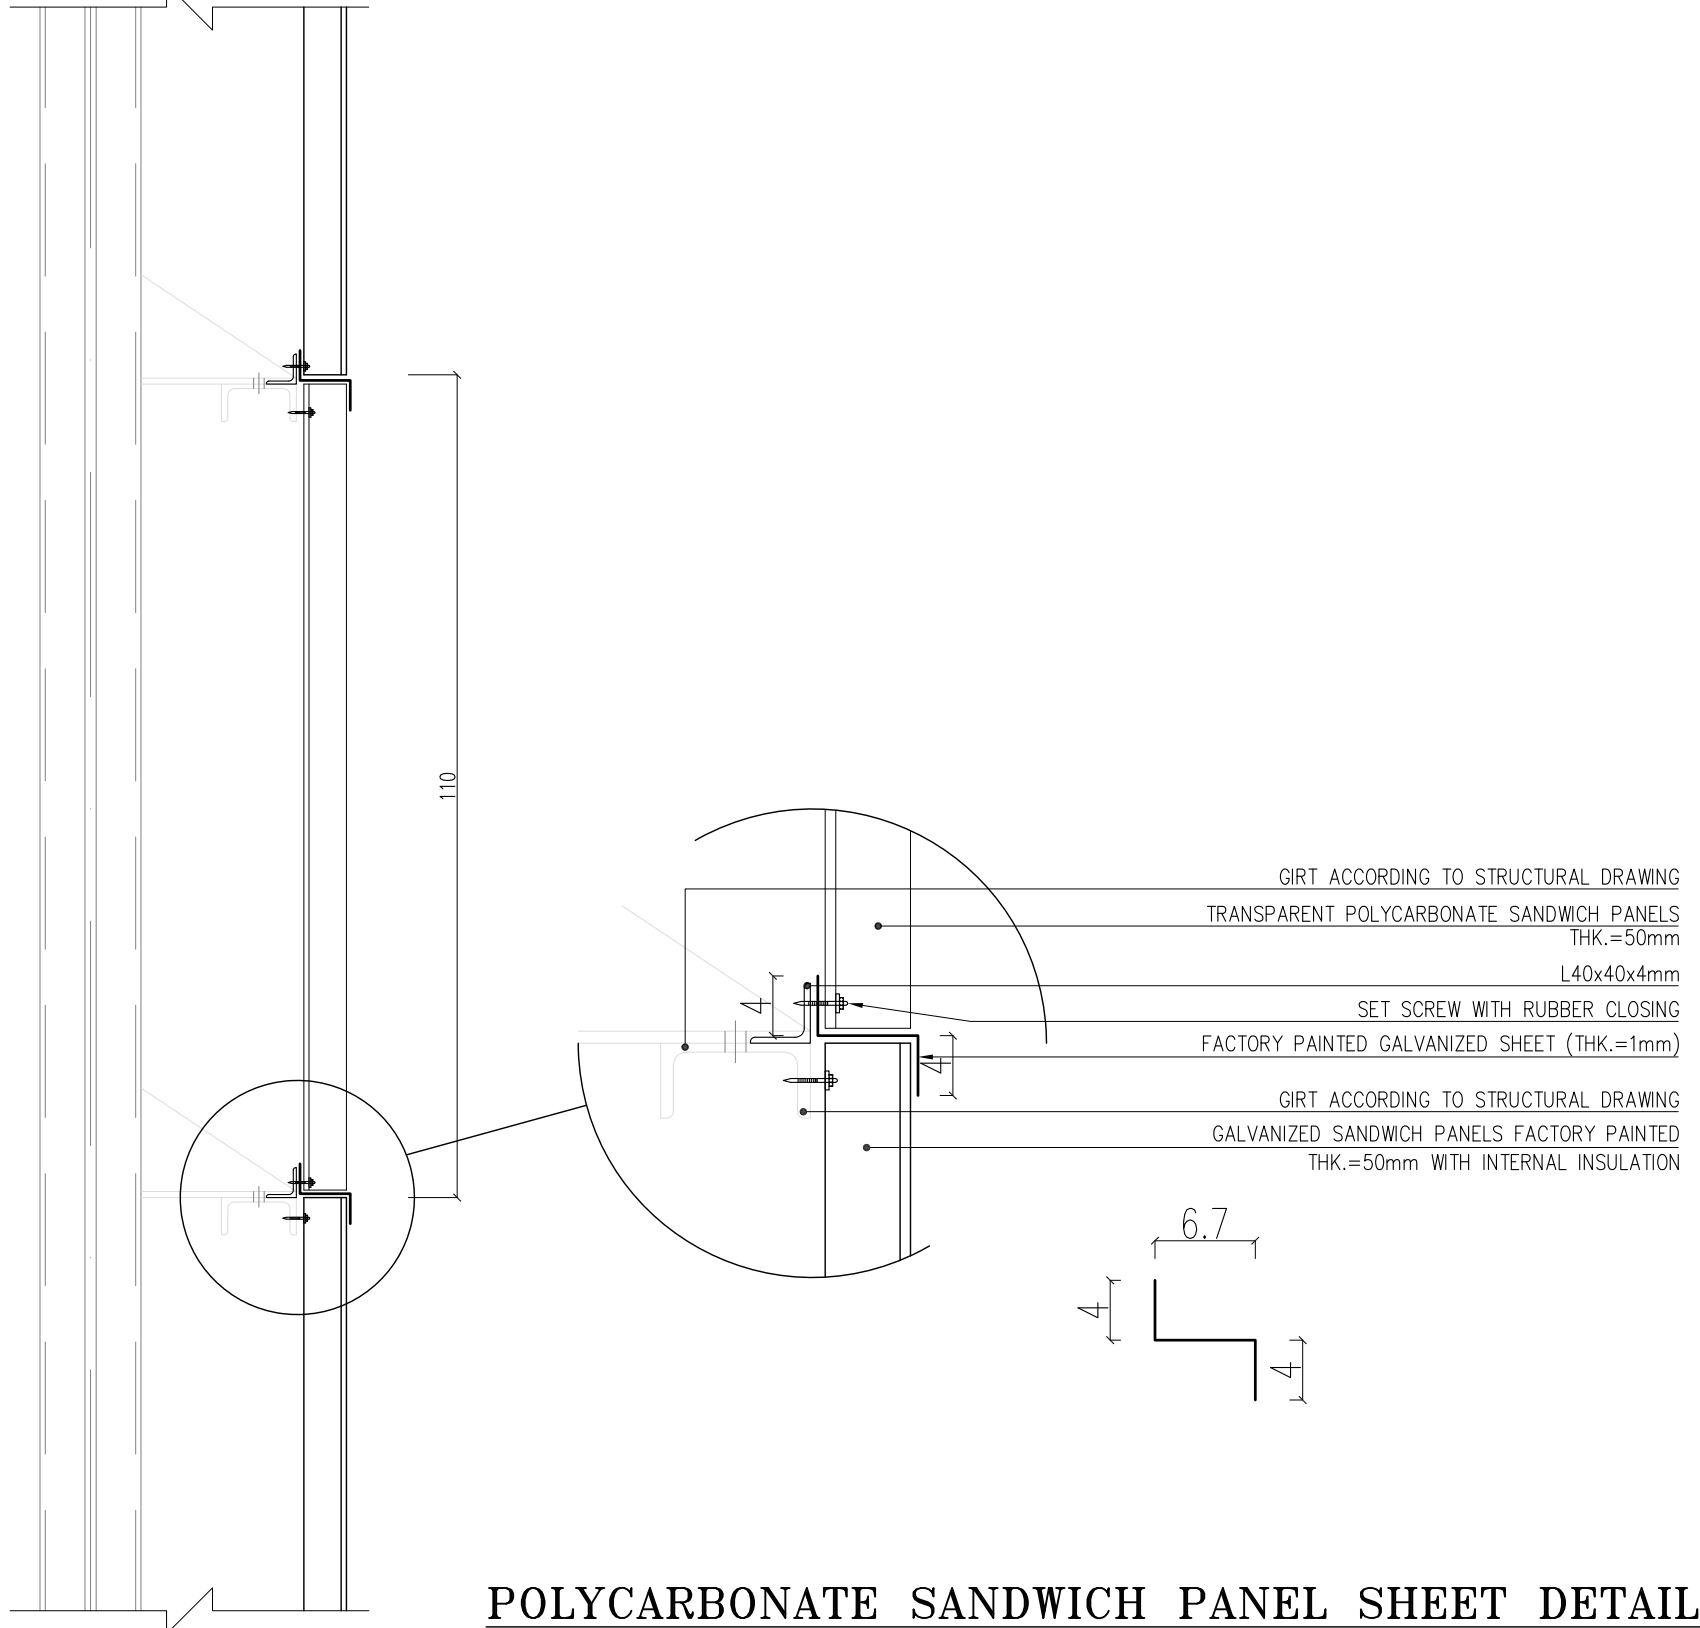

POLYCARBONATE SANDWICH PANEL SHEET DETAIL
Sc:1/10

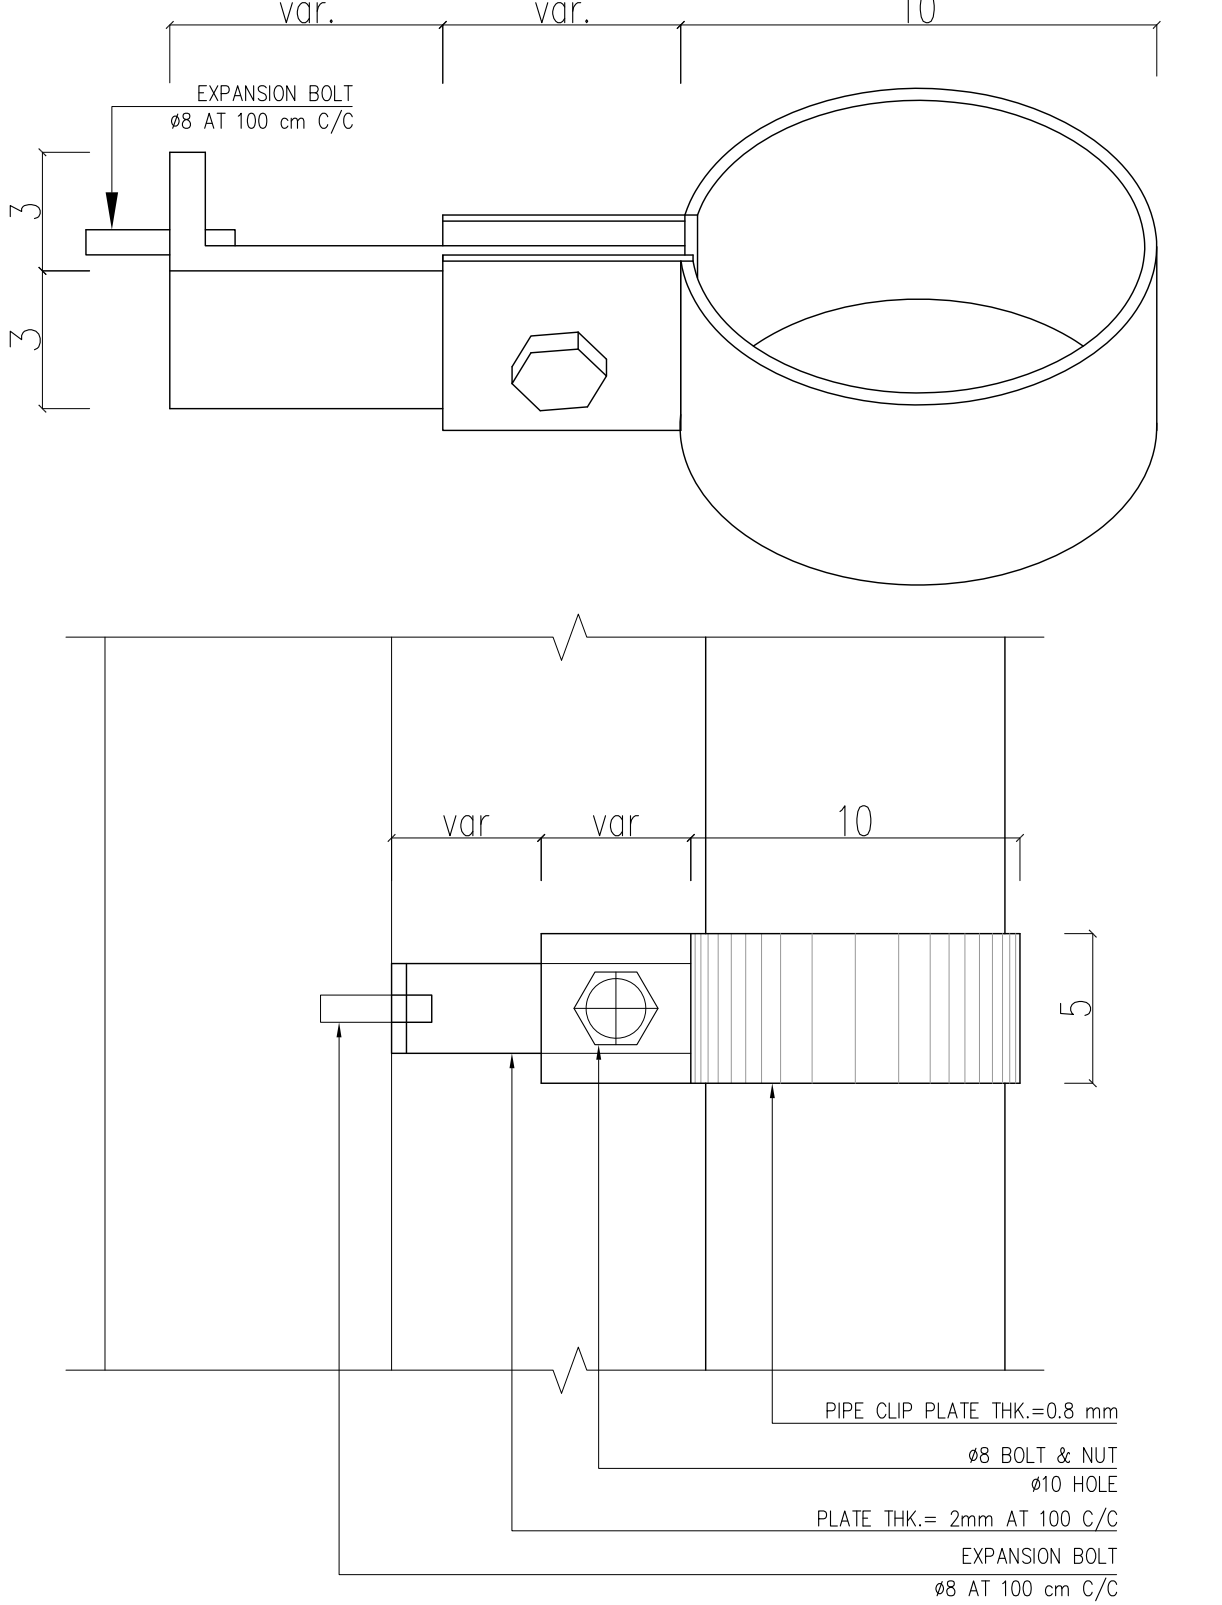


TYPICAL PIPE CLIP ON WALL
Sc: N.T.S.




REFERENCE	
REFERENCE. TITLE	REFERENCE. No.
FOUNDATION DRAWING	12003-D-ST-DWG-312-WHS-003
STRUCTURE DRAWING	12003-D-ST-DWG-312-WHS-004

NOTES	
1. ALL DIMENSIONS ARE IN CENTIMETER & ALL ELEVATIONS ARE IN METER.	
2. ALL DIMENSIONS AND ELEVATIONS SHALL BE CHECKED BY THE CONTRACTOR PRIOR TO CONSTRUCTION.	
3. F.F.L. IN ARCHITECTURAL DOCUMENT IS EQUALS TO 2518.50	
4. CONTRACTOR SHALL COMPARE ALL ARCHITECTURAL, MECHANICAL, ELECTRICAL, PIPING AND STRUCTURAL DRAWINGS AND IN CASE OF ANY CONFLICTS OR DISCREPANCY, INFORM THE ENGINEER.	
5. ALL OPENINGS FOR PIPING/CABLING SHALL BE CONSIDERED AS PER RELATED DRAWINGS BEFORE CONSTRUCTION.	






LEGEND	
AREA NAME :	
① WAREHOUSE	⑥ LOUNGE ROOM
② ENTRANCE	⑦ SUPERVISOR ROOM
③ PANTRY	⑧ W.C
④ MANAGER ROOM	⑨ LOCKER & SHOWER
⑤ PAYMENT ORDER ROOM	⑩ PRAYER ROOM

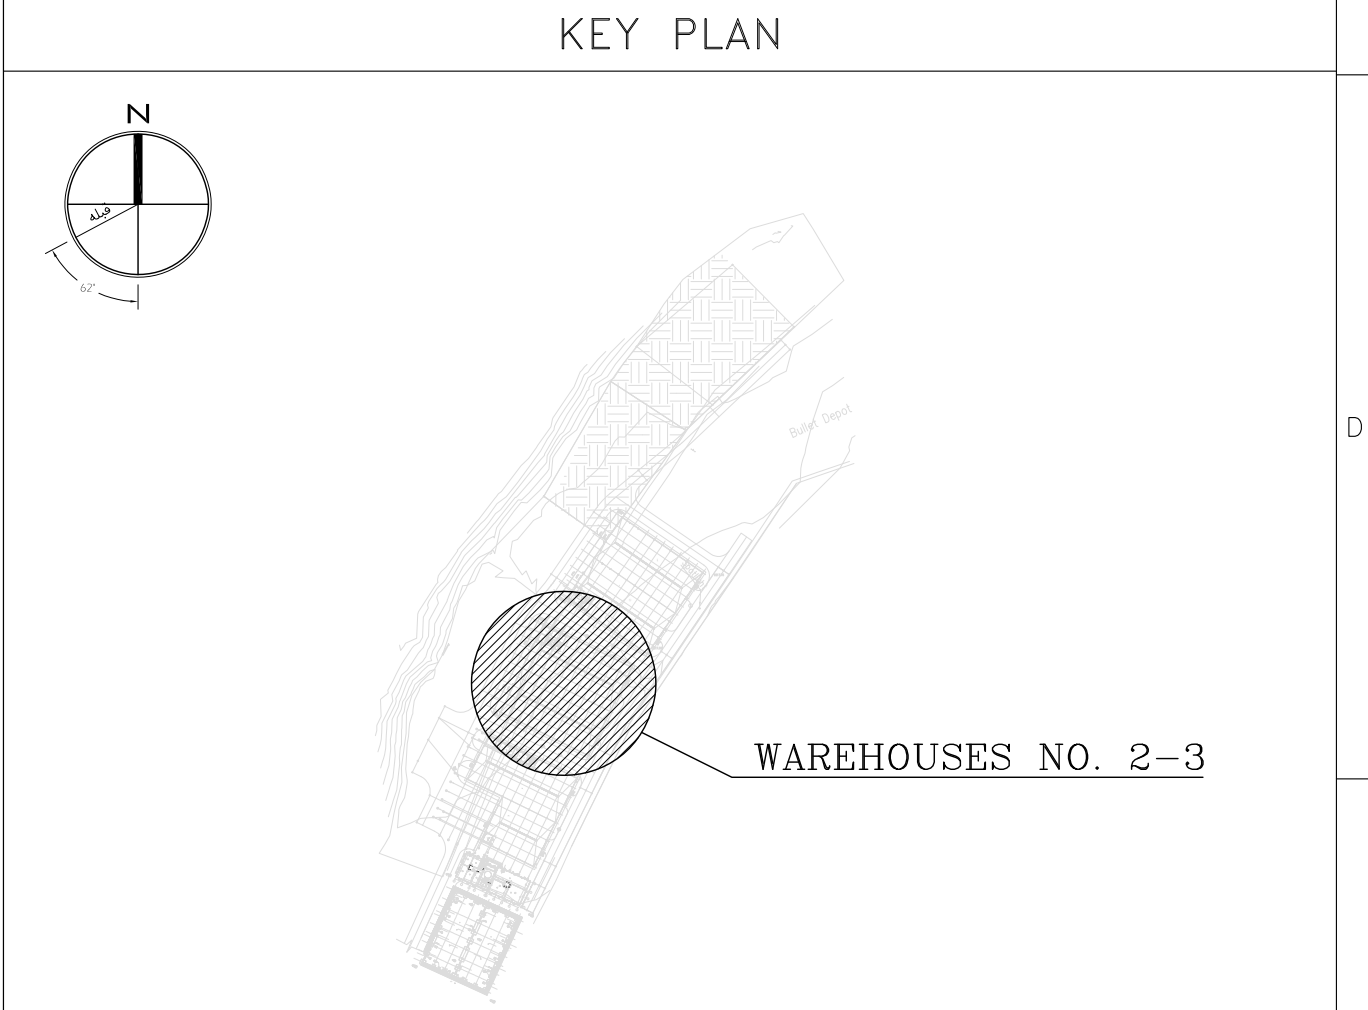

02	30.05.2023	ISSUED FOR CONSTRUCTION	M.MA&M.KH	M.AHMADI	H.NOROUZI	-	
01	23.05.2023	ISSUED FOR APPROVAL	M.MA&M.KH	M.AHMADI	H.NOROUZI	-	
00	09.02.2023	ISSUED FOR REVIEW AND COMMENT	M.MA&M.KH	M.AHMADI	H.NOROUZI	-	
REV.	DATE	DESCRIPTION	PREPARED	CHECKED	APPROVED	AUTHORIZED	
Client:			MC:				
 NICICO NATIONAL IRANIAN COPPER INDUSTRIES Co.			 Shargan Consultant Engineers				
Consultant:			Contractor:				
 mobina Mobina Engineering Co.			 NIPEC				
Project:							
Sarcheshmeh Copper Concentrator Expansion Plant (Phase.3)							
Title:							
ARCHITECTURAL DETAIL DESIGN FOR SARCHESHMEH WAREHOUSES NO. 2-3							
Document Number:			DATE	SIZE	SCALE	SHEET NO.	REV.
12003-D-AR-DWG-312-WHS-002			30.05.2023	A1	AS SHOWN	24 OF 25	CLIENT VENDOR 02 02

   

Sc: 1/10

     

Sc: 1/10

F